

PIPE SCHEDULE									
FLOW STREAM	ABBREVIATION	LOCATION	SIZE	MATERIAL	SCHEDULE/CLASS	LINING	JOINT TYPE	INSULATION	SPEC SECTION
BIOFILTER AIR	BFA	ABOVE GRADE	ALL	FRP	N/A	NONE	FLANGED	NONE	11961
		ALL	ALL	HDPE	DR17	NONE	BUTT FUSED	NONE	2620
CITY WATER	CW	BELOW GRADE	≤ 3"	COPPER	TYPE K	NONE	SOLDERED	NONE	11961
			> 3"	DUCTILE IRON	CLASS 52	CEMENT	MECHANICAL JOINT	NONE	11961
DRAIN	D	BELOW GRADE	ALL	PVC	SDR 35	NONE	PUSH ON	NONE	2625
INTERNAL RECYCLE	IR	ALL	ALL	DUCTILE IRON	CLASS 52	CEMENT	MECHANICAL JOINT	NONE	11961
LIME SLURRY	LS	ALL	ALL	PVC	SCH 80	NONE	SOLVENT WELD	NONE	11961
				HDPE	SDR 11	NONE	BUTT FUSED	NONE	2620
PLANT WATER	PW	INDOOR	≤ 3"	COPPER	TYPE K	NONE	SOLDERED	NONE	11961
		ALL	> 3"	DUCTILE IRON	CLASS 52	CEMENT	MECHANICAL JOINT	NONE	2618
POLYMER	PO	INDOOR	ALL	PVC	SCH 40	NONE	SOLVENT WELD	NONE	11961
PRIMARY EFFLUENT	PE	BELOW GRADE	ALL	DUCTILE IRON	CLASS 52	CEMENT	MECHANICAL JOINT	NONE	2618
PRIMARY INFLUENT	PI	BELOW GRADE	ALL	DUCTILE IRON	CLASS 52	CEMENT	MECHANICAL JOINT	NONE	2618
PRIMARY SLUDGE	PS	ABOVE GRADE	ALL	DUCTILE IRON	CLASS 52	GLASS	FLANGED	NONE	11961
		BELOW GRADE	ALL	DUCTILE IRON	CLASS 52	GLASS	MECHANICAL JOINT	NONE	11961
PROCESS AIR	PA	ALL	ALL	STAINLESS STEEL	SCH 10S	NONE	WELDED	NONE	15066
RETURN ACTIVATED SLUDGE	RAS	ABOVE GRADE	ALL	DUCTILE IRON	CLASS 52	GLASS	FLANGED	NONE	11961
		BELOW GRADE	ALL	DUCTILE IRON	CLASS 52	GLASS	MECHANICAL JOINT	NONE	2618
SANITARY FORCE MAIN	SFM	BELOW GRADE	ALL	PVC	SDR 21	NONE	PUSH ON	NONE	2625
SANITARY SEWER	SS	BELOW GRADE	ALL	PVC	SDR 35	NONE	PUSH ON	NONE	2622
SCUM	SC	ALL	ALL	DUCTILE IRON	CLASS 52	CEMENT	MECHANICAL JOINT	NONE	11961
SECONDARY EFFLUENT	SE	ALL	ALL	DUCTILE IRON	CLASS 52	CEMENT	MECHANICAL JOINT	NONE	11961
SODIUM BISULFITE	SB	ALL	ALL	PVC	SCH 80	NONE	SOLVENT WELD	INSUL. & HEAT TRACE	11961
				PVC	SCH 80	NONE	SOLVENT WELD	NONE	11961
SODIUM HYPOCHLORITE	SH	ALL	ALL	HDPE	SDR 11	NONE	BUTT FUSED	NONE	2620
				DUCTILE IRON	CLASS 52	GLASS	FLANGED	NONE	11961
THICKENED SLUDGE	TS	ABOVE GRADE	ALL	DUCTILE IRON	CLASS 52	GLASS	MECHANICAL JOINT	NONE	11961
		BELOW GRADE	ALL	DUCTILE IRON	CLASS 52	GLASS	MECHANICAL JOINT	NONE	11961
WASTE ACTIVATED SLUDGE	WAS	ABOVE GRADE	ALL	DUCTILE IRON	CLASS 52	GLASS	FLANGED	NONE	11961
		BELOW GRADE	ALL	DUCTILE IRON	CLASS 52	GLASS	MECHANICAL JOINT	NONE	2618

PREPARED BY



REGISTERED PROFESSIONAL



SUBCONSULTANT

PROJECT

Taunton Wastewater Treatment Facility Improvements Phase 1

Taunton, MA

TITLE

Pipe Schedule

NO.	REVISIONS	DATE
DRAWN BY: BM		
DESIGNED BY: MA		
CHECKED BY: SR		
ISSUE DATE: 7/2/2021		
BETA JOB NO.: 6050		

SCALE

 
NONE

UNLESS OTHERWISE NOTED OR CHANGED BY REPRODUCTION


SHEET NO.

M-0.1

NO.	REVISIONS	DATE
DRAWN BY:	BM	
DESIGNED BY:	BM	
CHECKED BY:	SR	
ISSUE DATE:	7/2/2021	
BETA JOB NO.:	6050	



7/2/2021 10:33 AM J:\TAUNTON\WTF DESIGN\AUTOCAD\PLAN SET\PHASE 1\HEADWORKS - PROP. PLANS & SECTIONS.DWG (BETA STD BW.CTE)

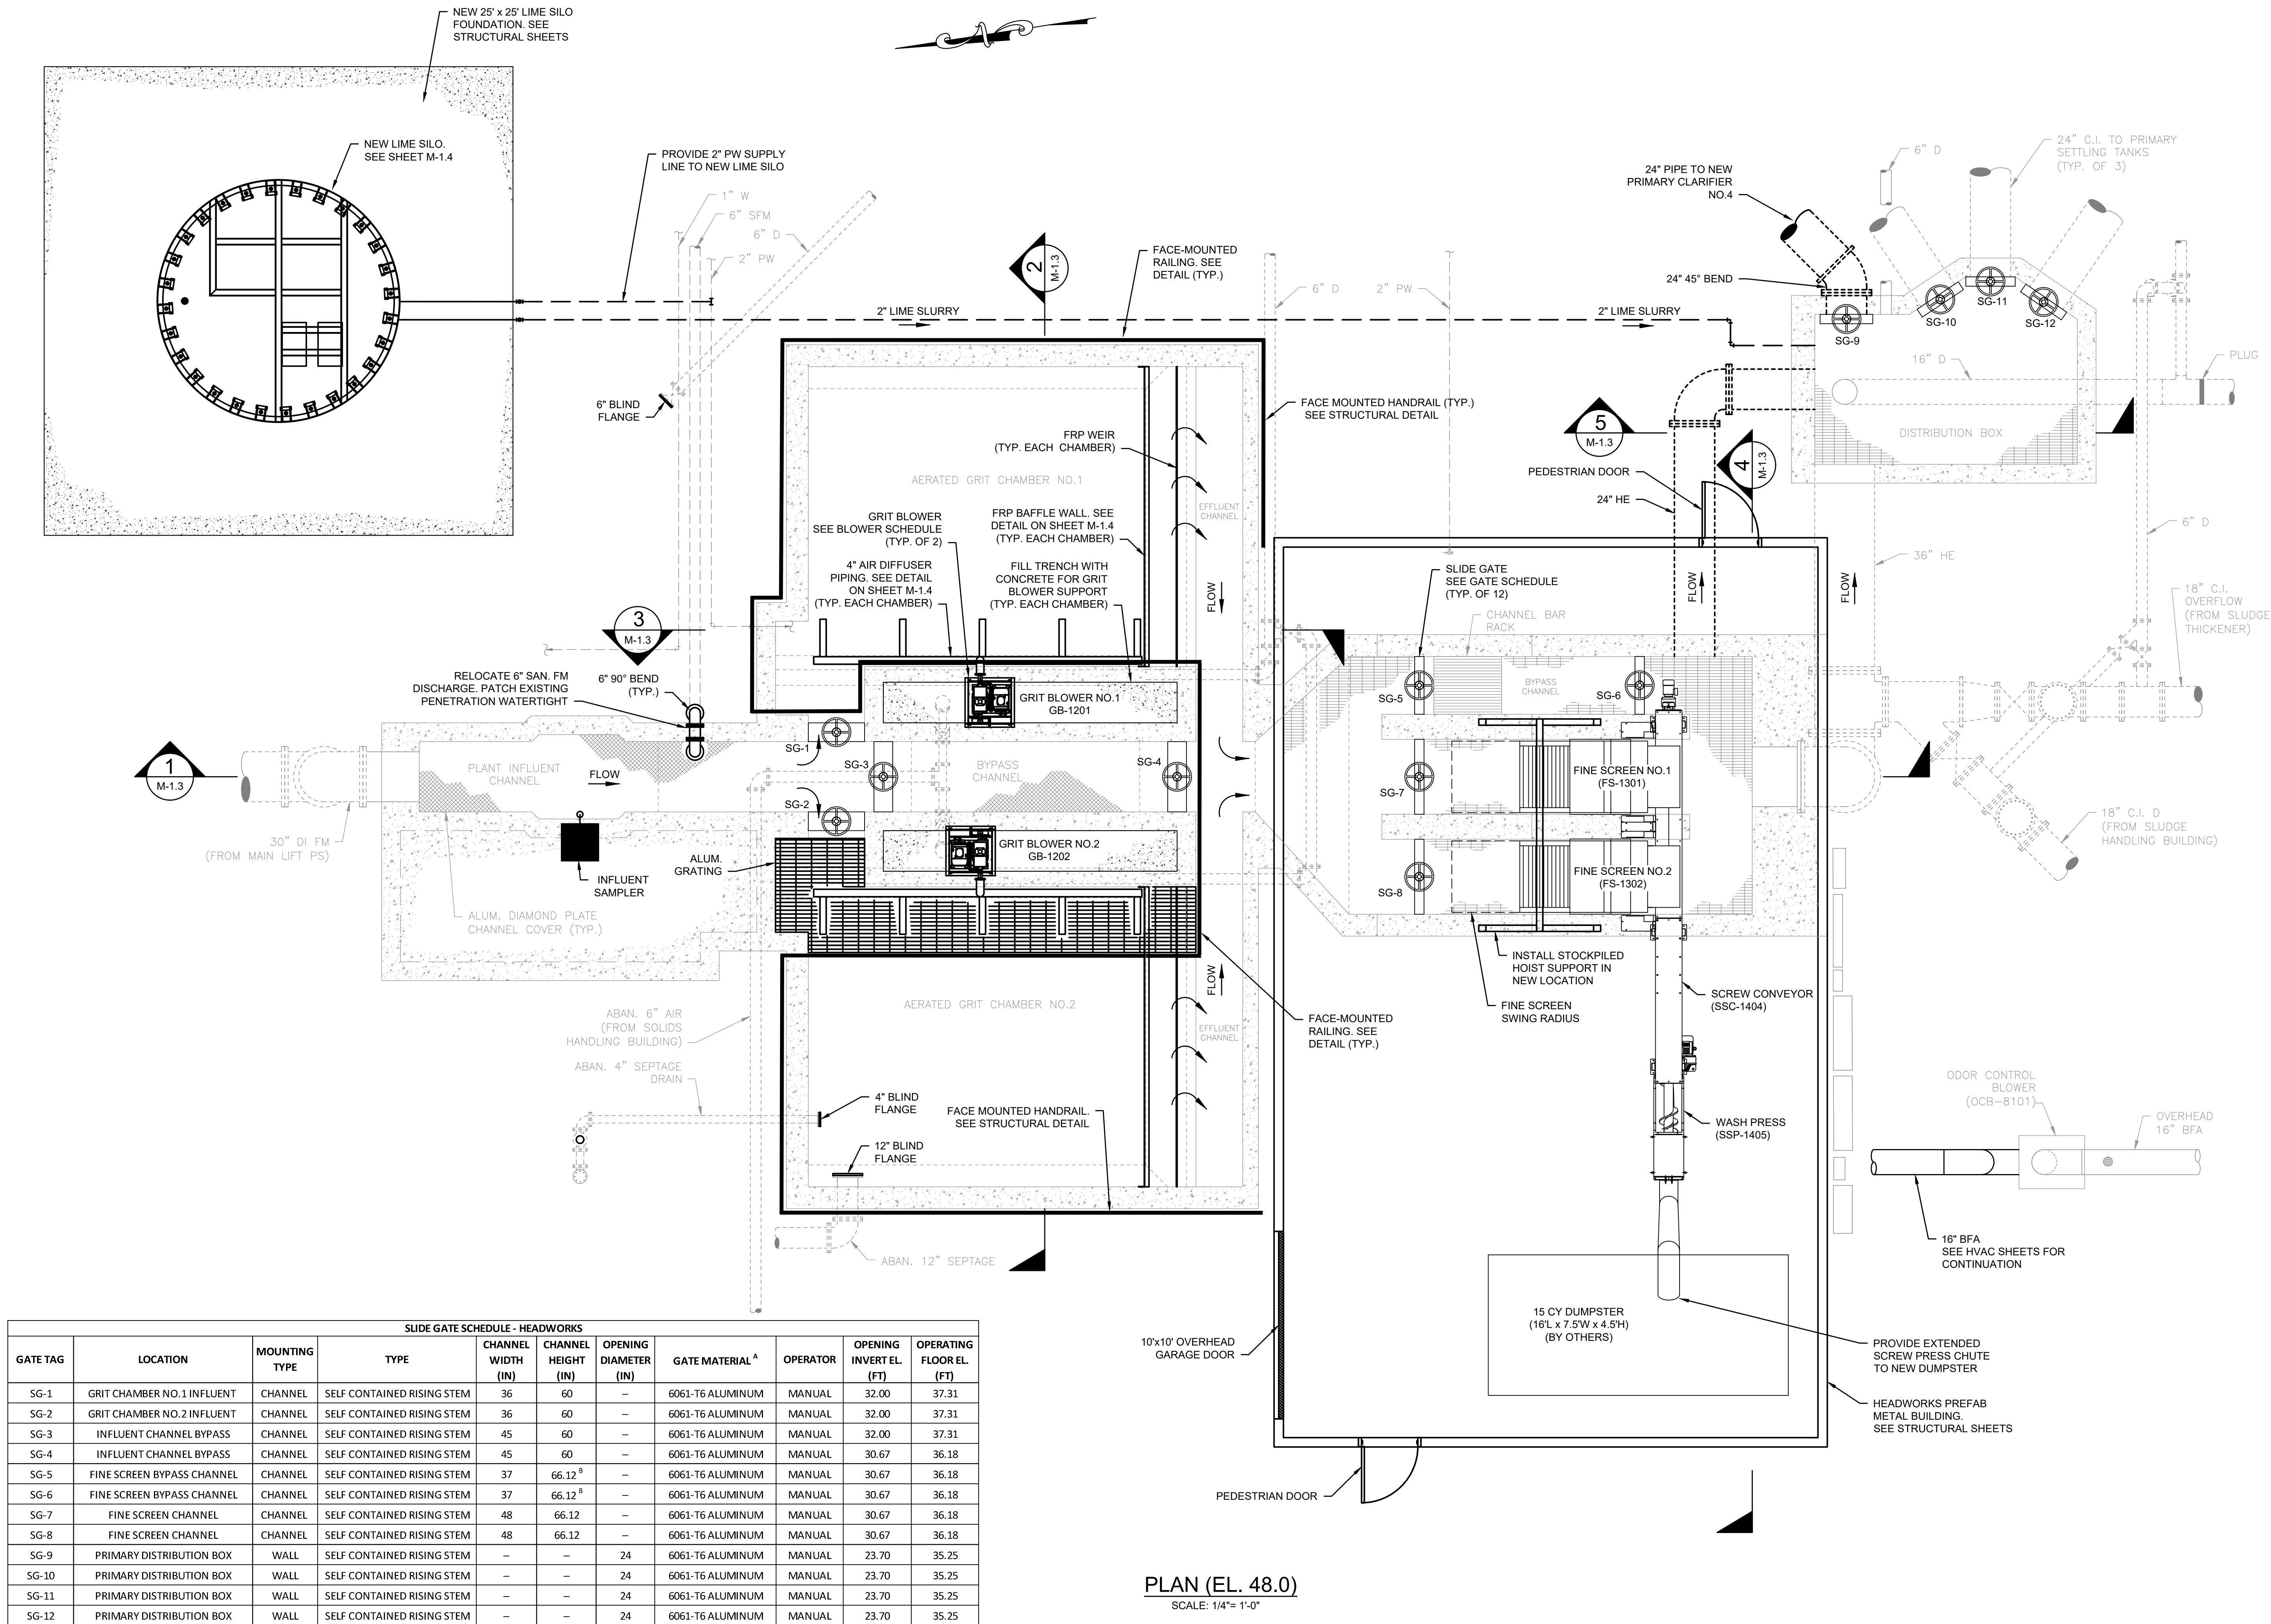

PLAN (EL. 48.0)
SCALE: 1/4"= 1'-0"

PREPARED BY



REGISTERED PROFESSIONAL



SUBCONSULTANT

PROJECT

**Taunton Wastewater
Treatment Facility
Improvements
Phase 1**

Taunton, MA

TITLE

**Headworks
Plan**

NO.	REVISIONS	DATE

DRAWN BY: BM

DESIGNED BY: MA

CHECKED BY: SR

ISSUE DATE: 7/2/2021

BETA JOB NO.: 6050

SCALE










AS SHOWN

UNLESS OTHERWISE NOTED OR CHANGED BY REPRODUCTION

SHEET NO.

M-1.2


7/2/2021 10:33 AM J:\TAUNTON\WMTF DESIGN\AUTOCAD\PLAN SET\PHASE 1\HEADWORKS - PROP. PLANS & SECTIONS.DWG (BETA STD BW.CTE)

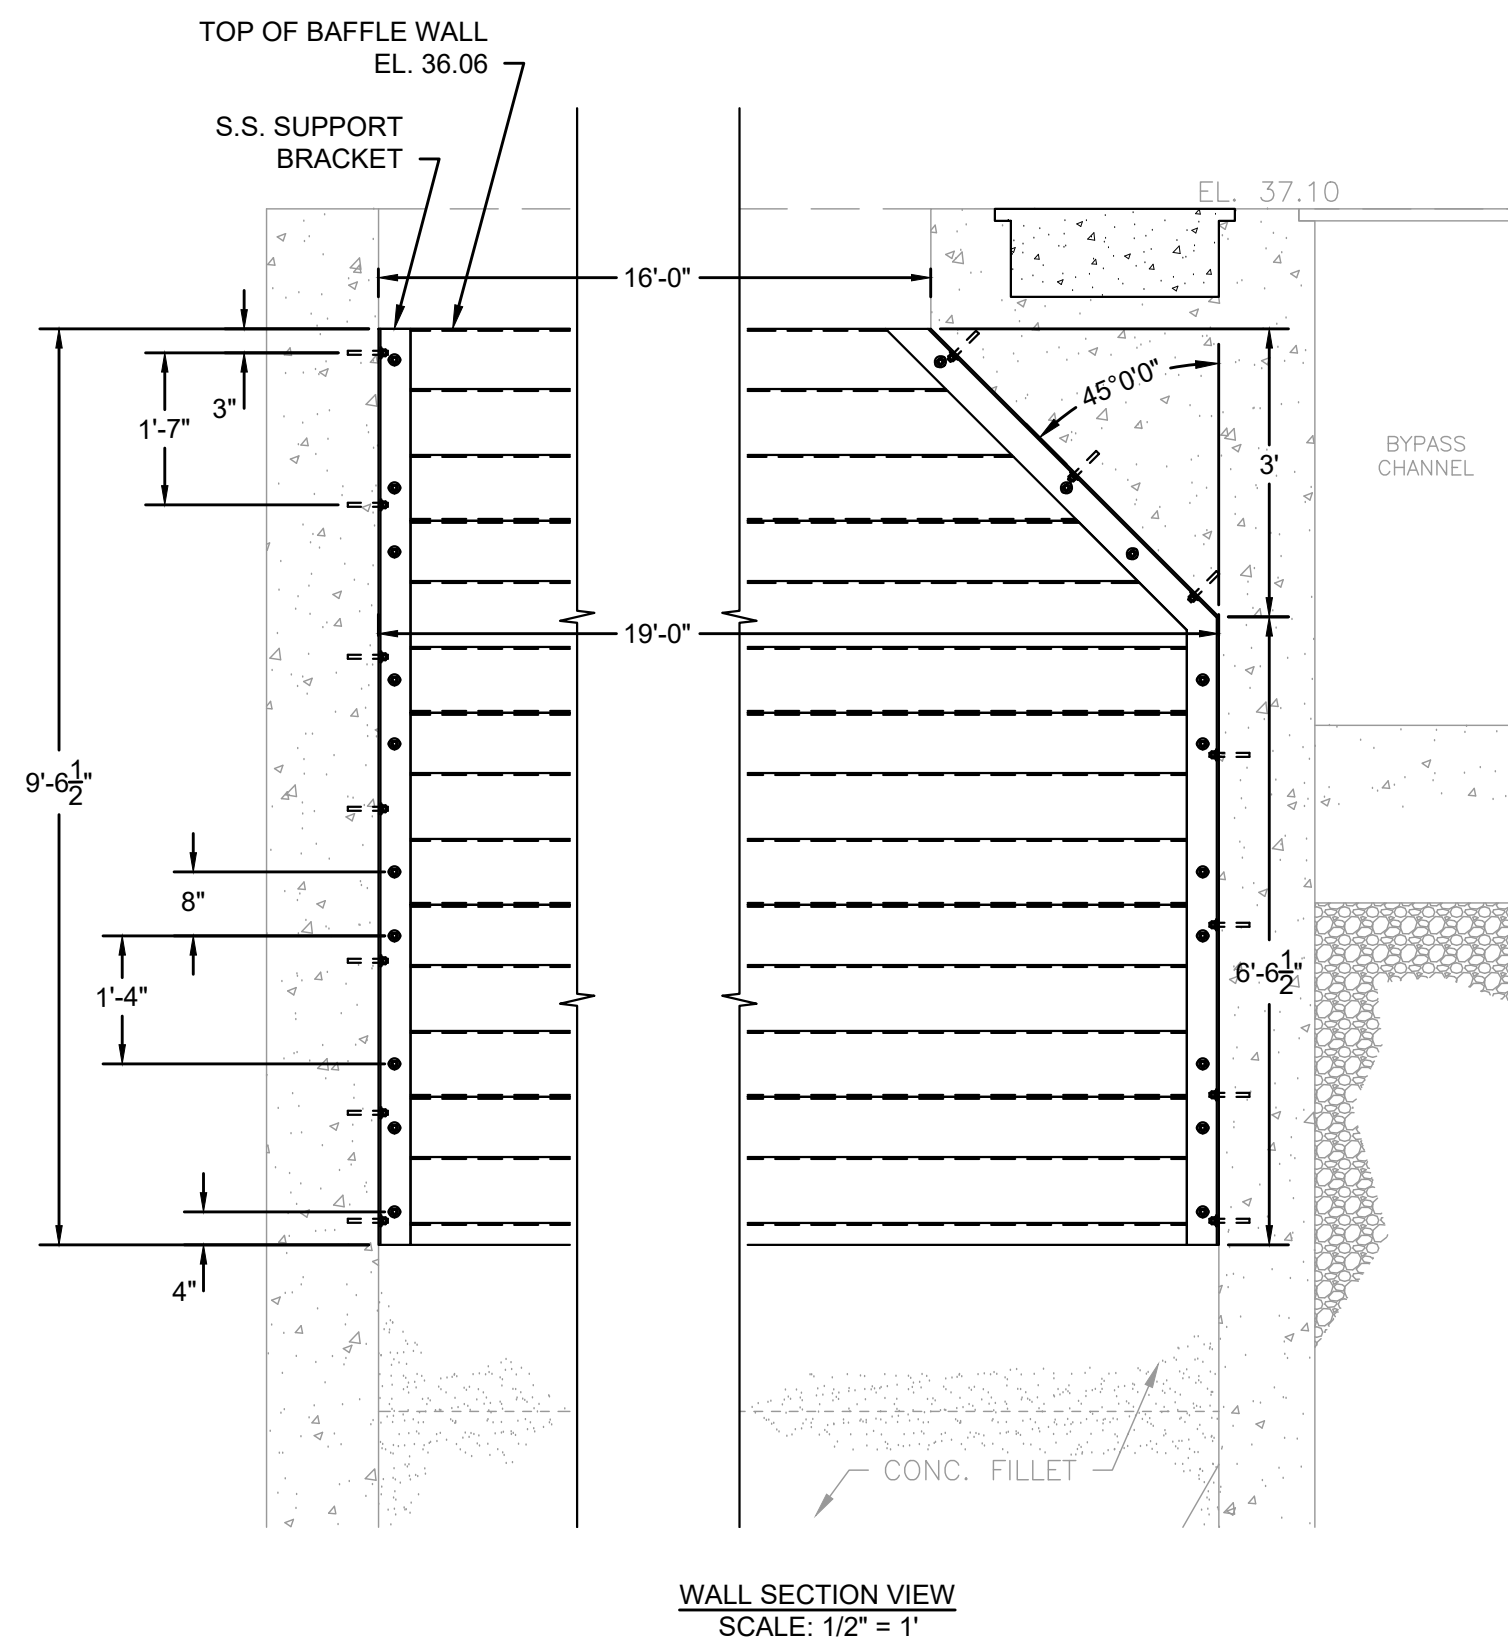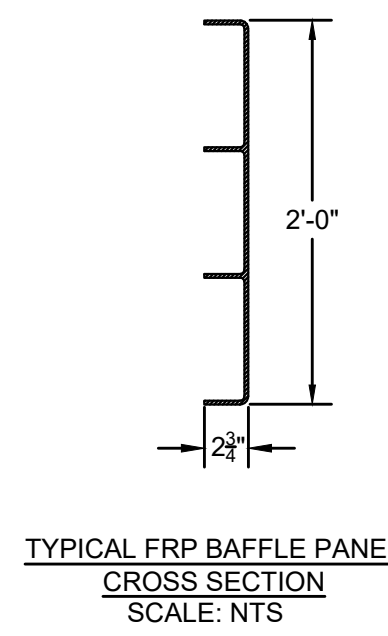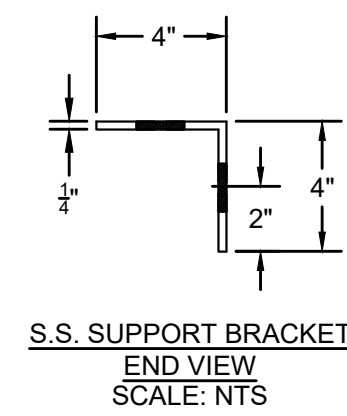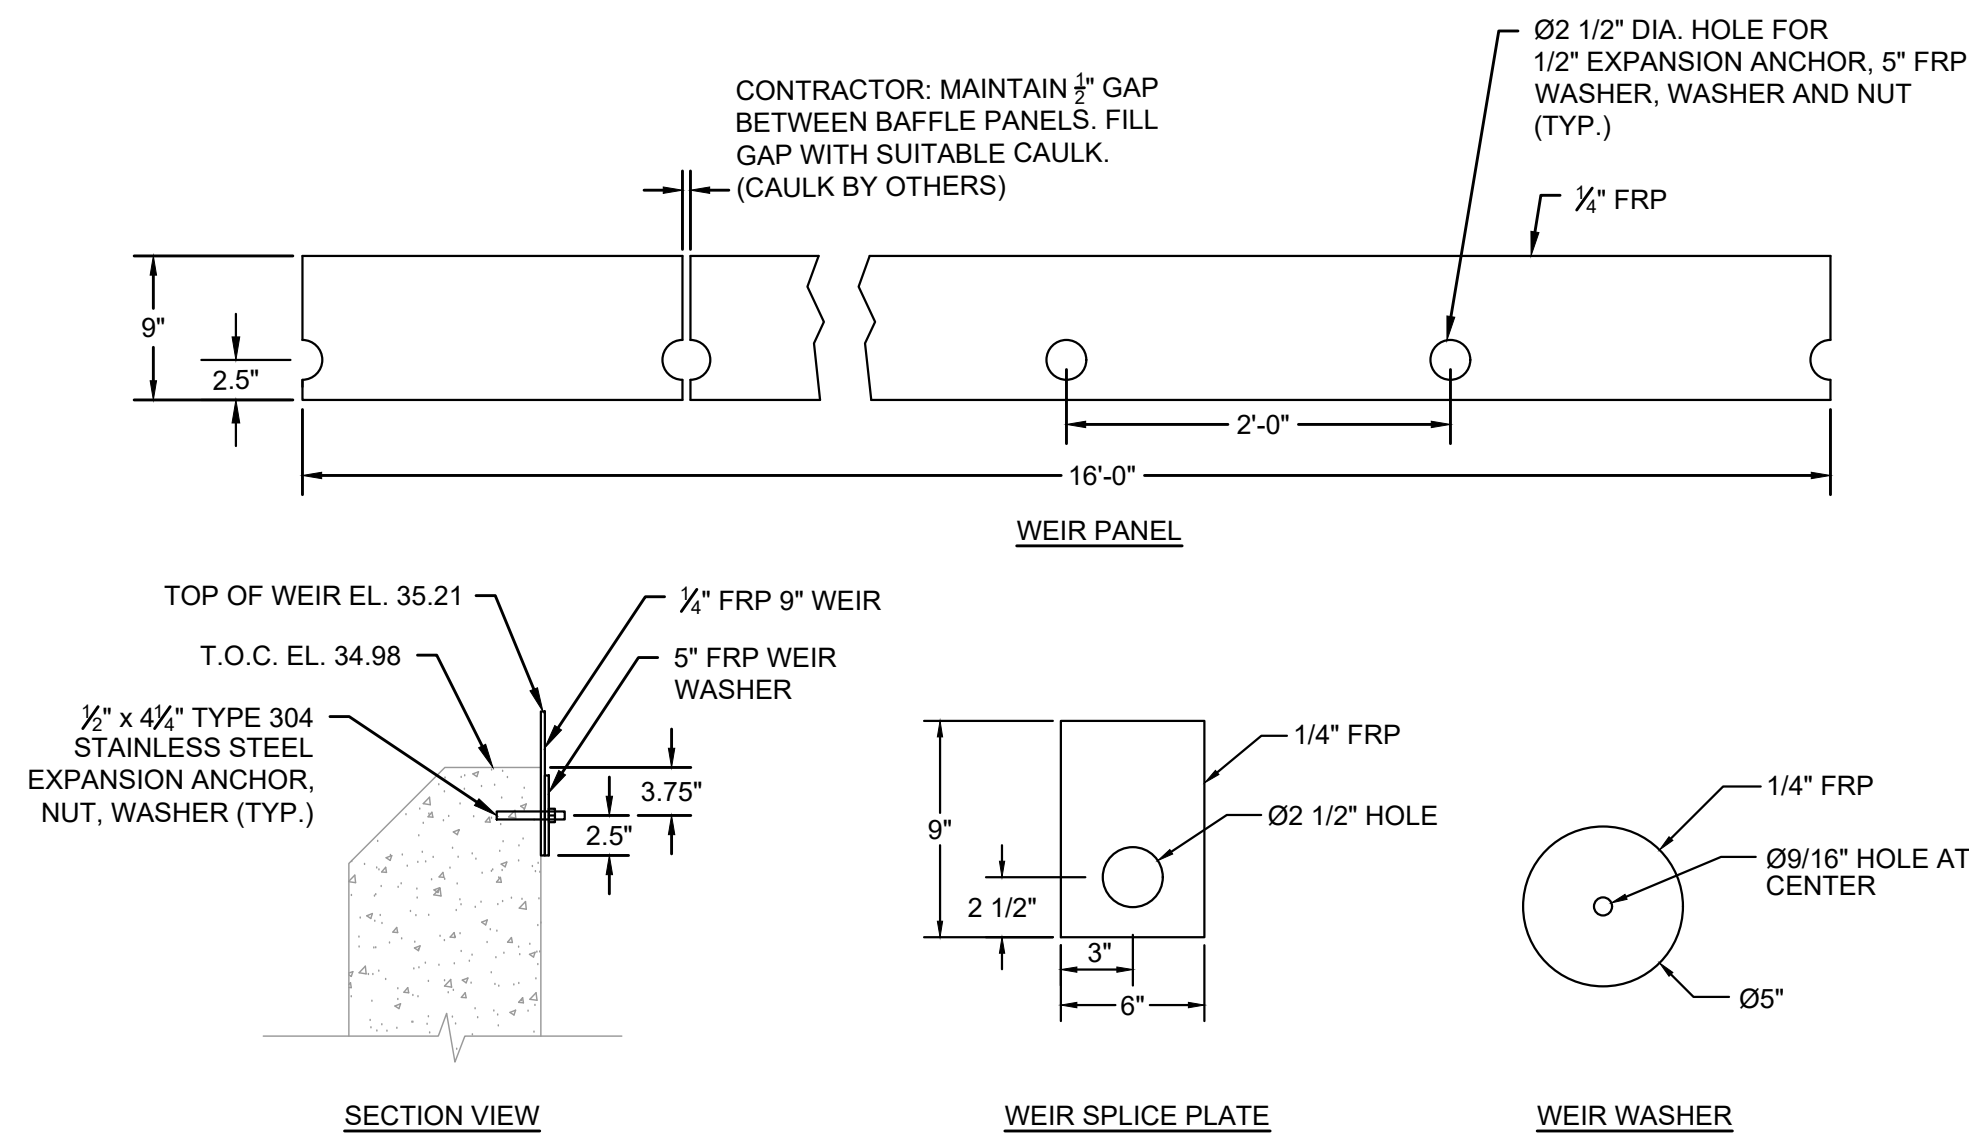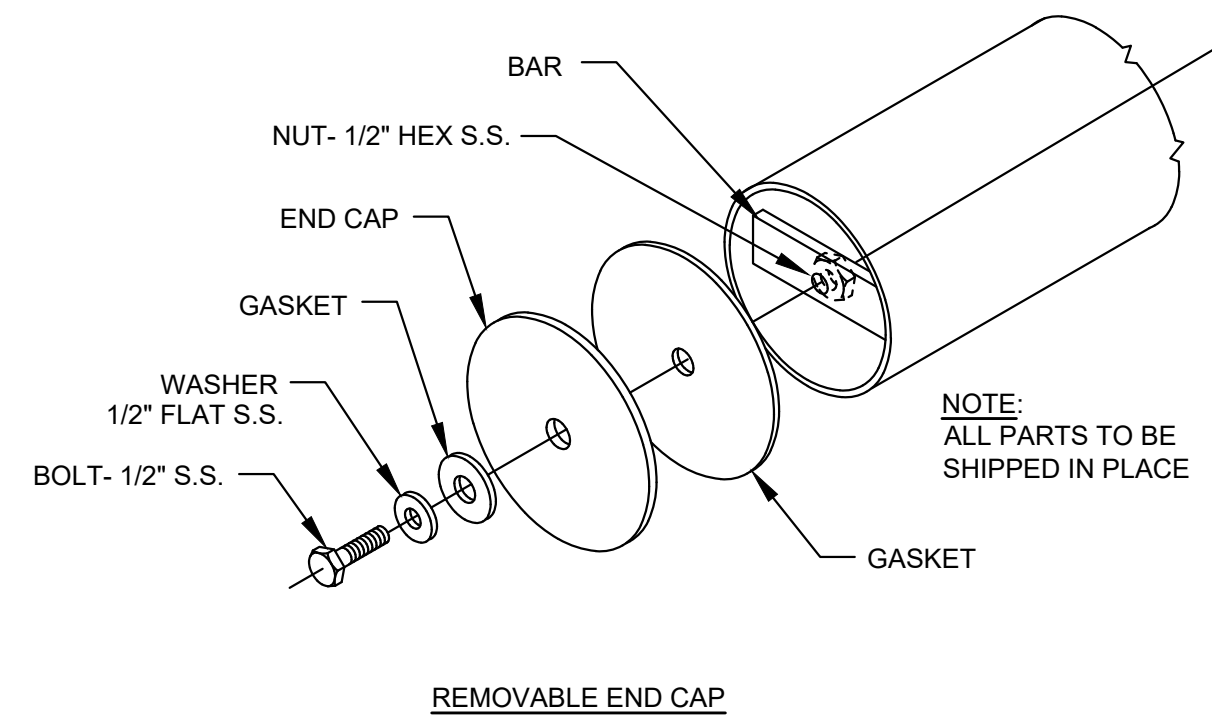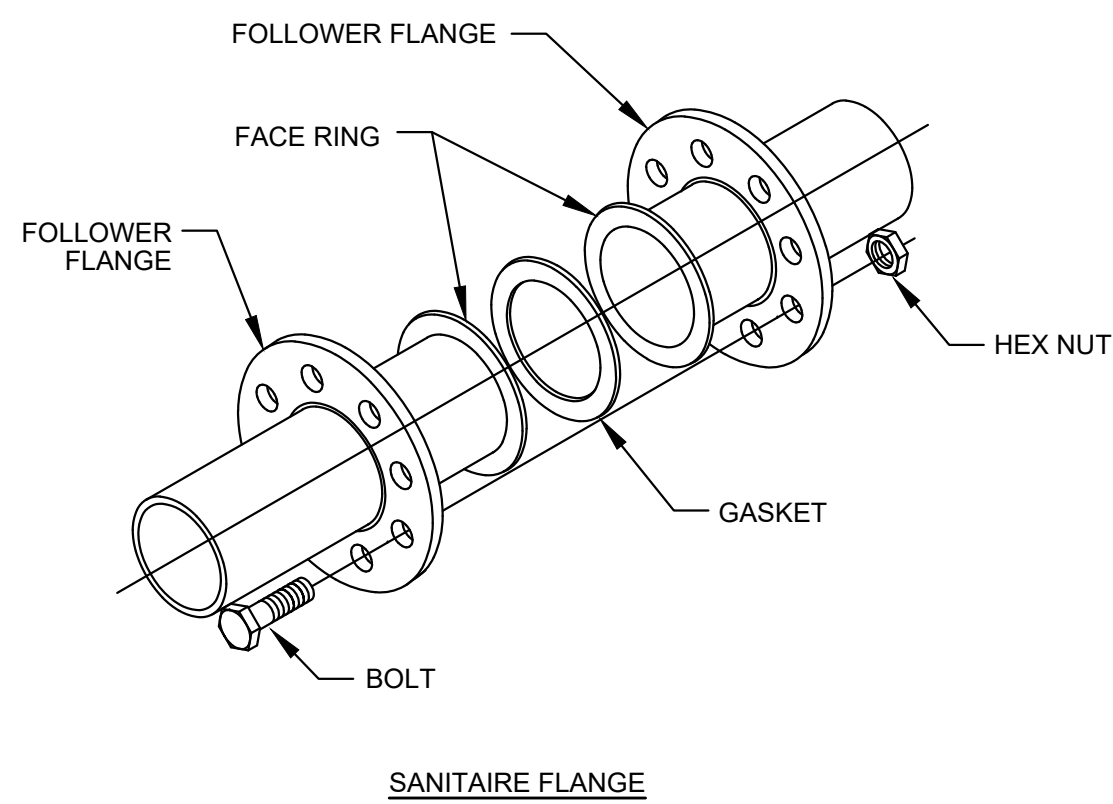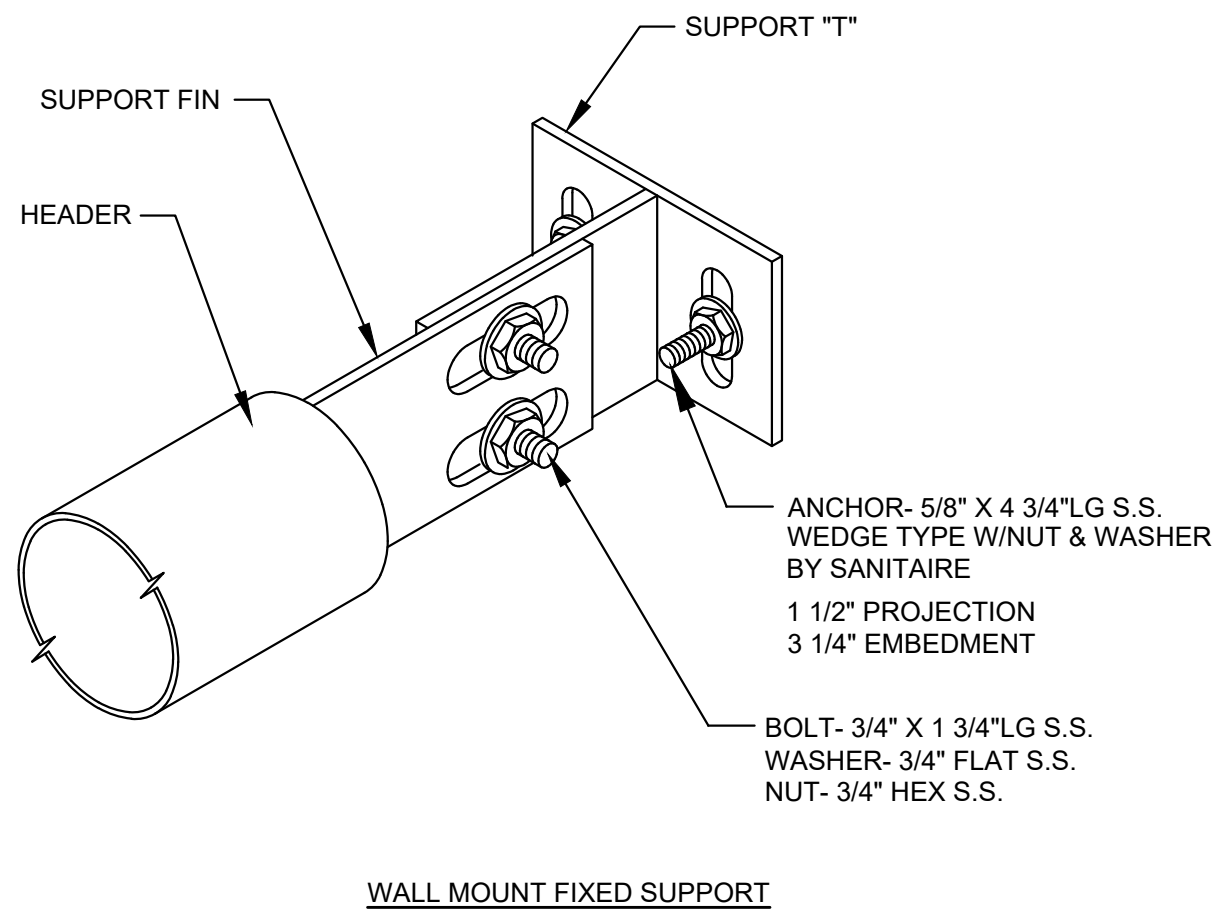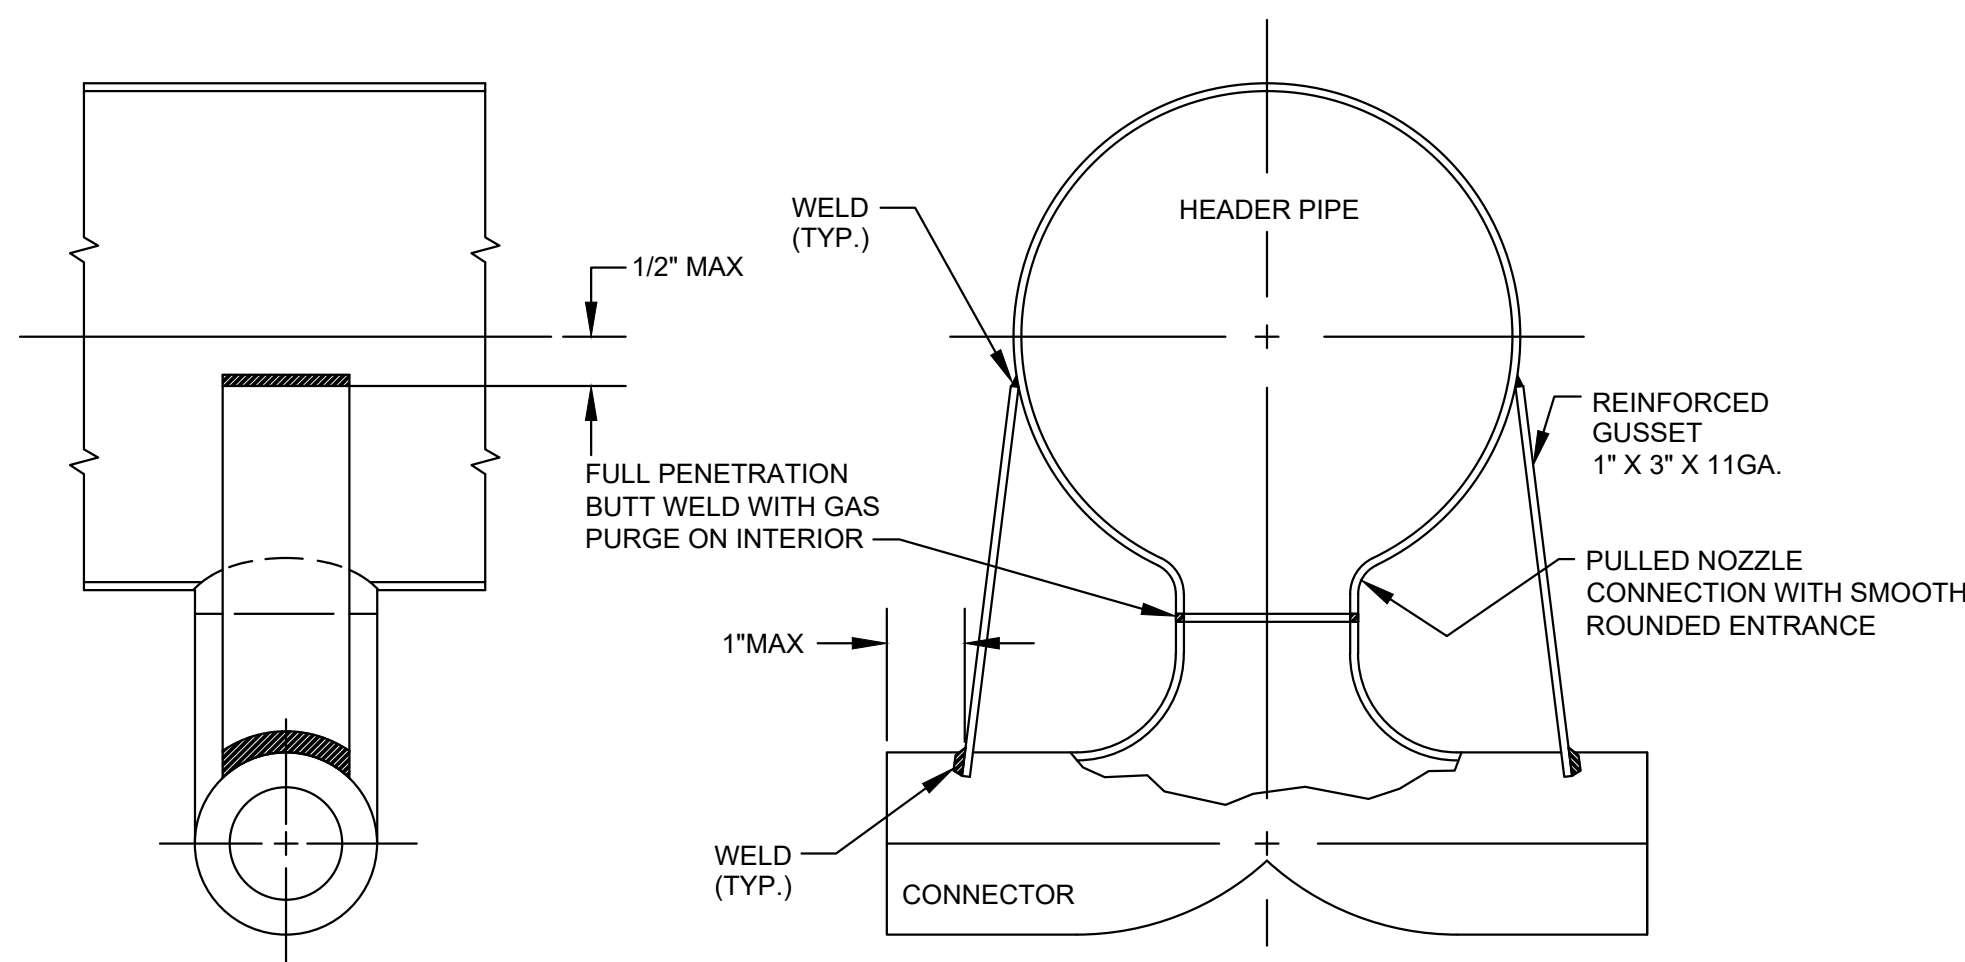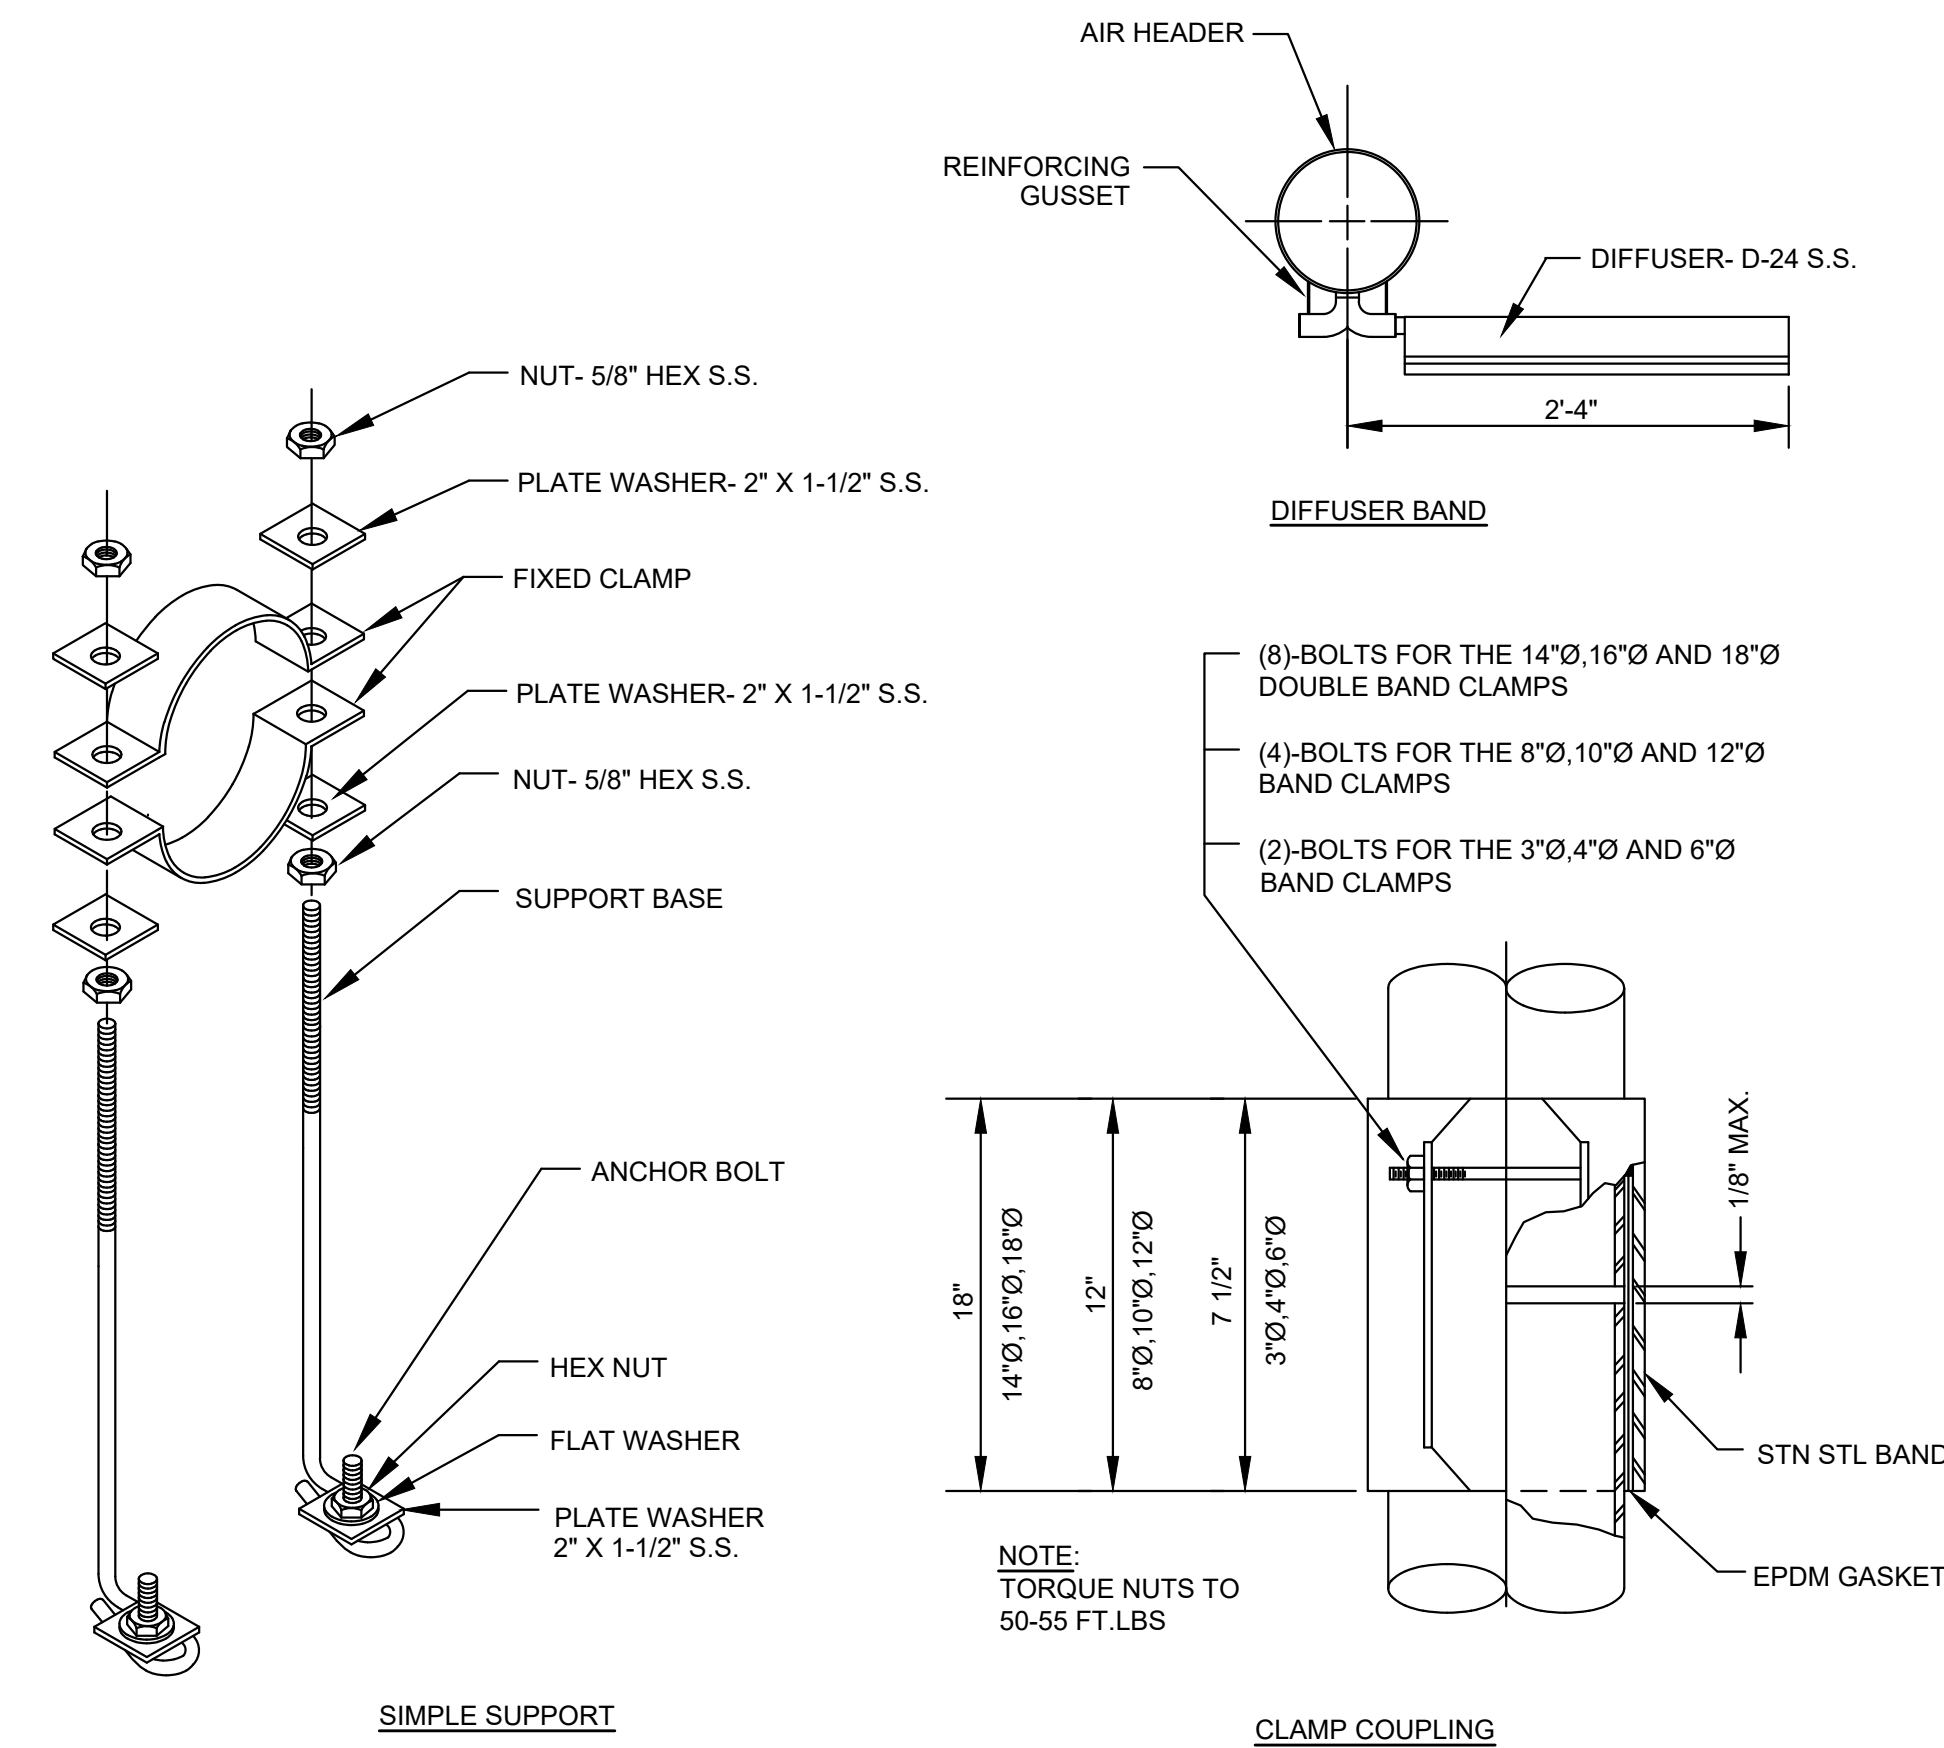

PREPARED BY



REGISTERED PROFESSIONAL

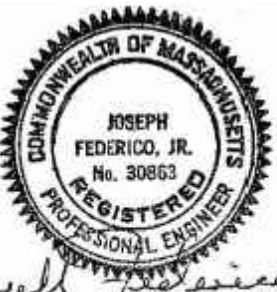

SUBCONSULTANT

PROJECT

Taunton Wastewater Treatment Facility Improvements Phase 1

Taunton, MA

TITLE

Headworks Details

NO.	REVISIONS	DATE

DRAWN BY:	BM
DESIGNED BY:	MA
CHECKED BY:	SR
ISSUE DATE:	7/2/2021
BETA JOB NO.:	6050

SCALE



AS SHOWN

UNLESS OTHERWISE NOTED OR CHANGED BY REPRODUCTION

SHEET NO.

M-1.4

7/2/2021 10:34 AM J:\TAUNTON\WMTF DESIGN\AUTOCAD\PLAN SET\PHASE 1\PRIMARY CLARIFIERS & SLUDGE PS - EXIST. PLANS & SECTIONS.DWG (BETA STD BW.CTB)

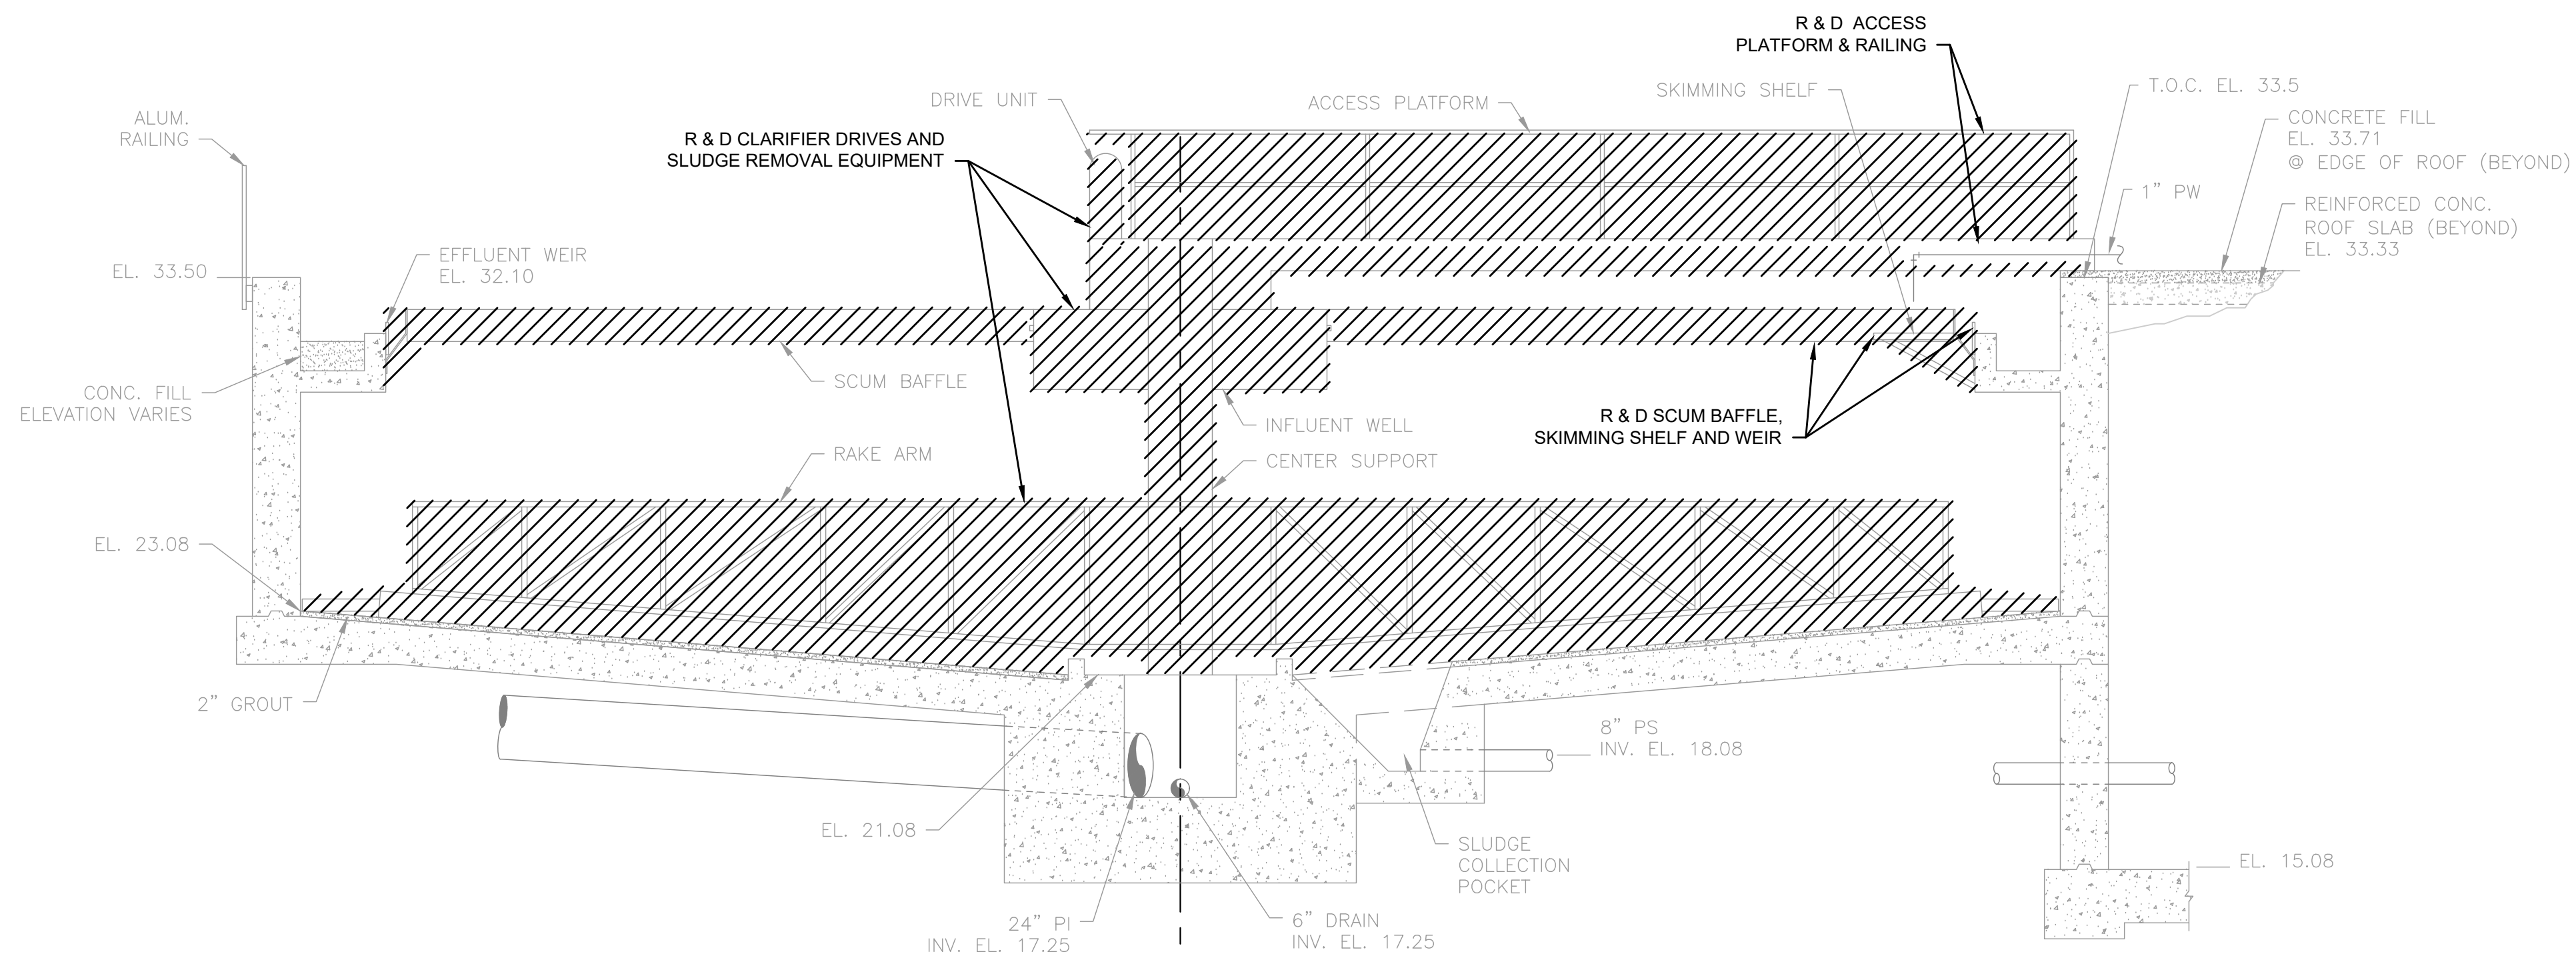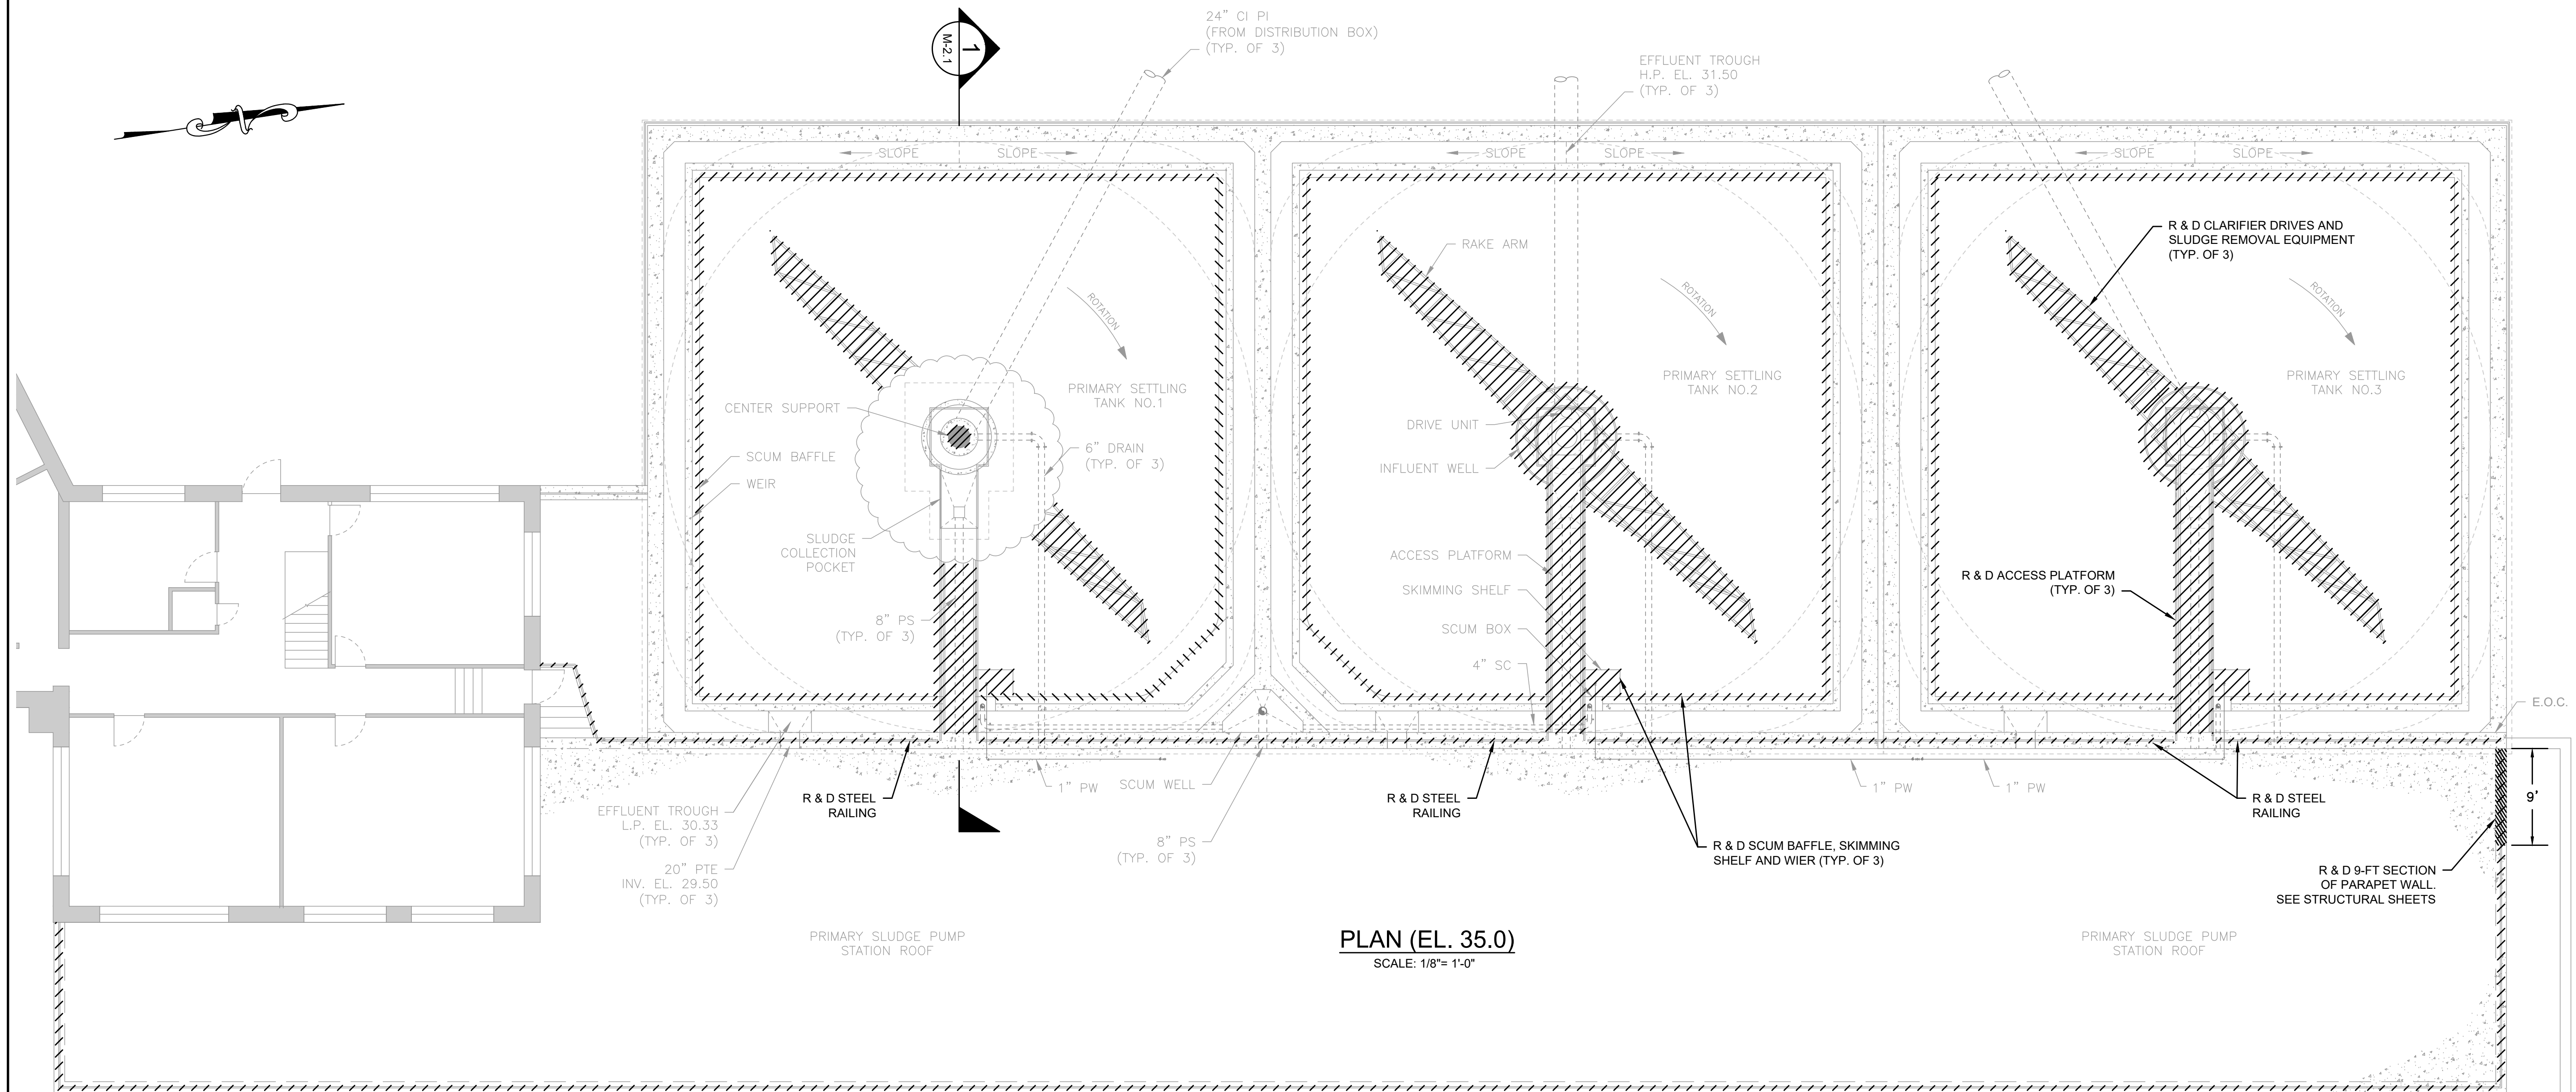

PREPARED BY



REGISTERED PROFESSIONAL



SUBCONSULTANT

PROJECT

**Taunton Wastewater
Treatment Facility
Improvements
Phase 1**

Taunton, MA

TITLE

**Primary Clarifiers
Demolition Plan & Section**

NO.	REVISIONS	DATE

SCALE


AS SHOWN

UNLESS OTHERWISE NOTED OR CHANGED BY REPRODUCTION


SHEET NO.

M-2.1

7/2/2021 10:34 AM J:\TAUNTON\WMTF DESIGN\AUTOCAD\PLAN SET\PHASE 1\PRIMARY CLARIFIERS & SLUDGE PS - EXIST. PLANS & SECTIONS.DWG (BETA STD BW.CTB)

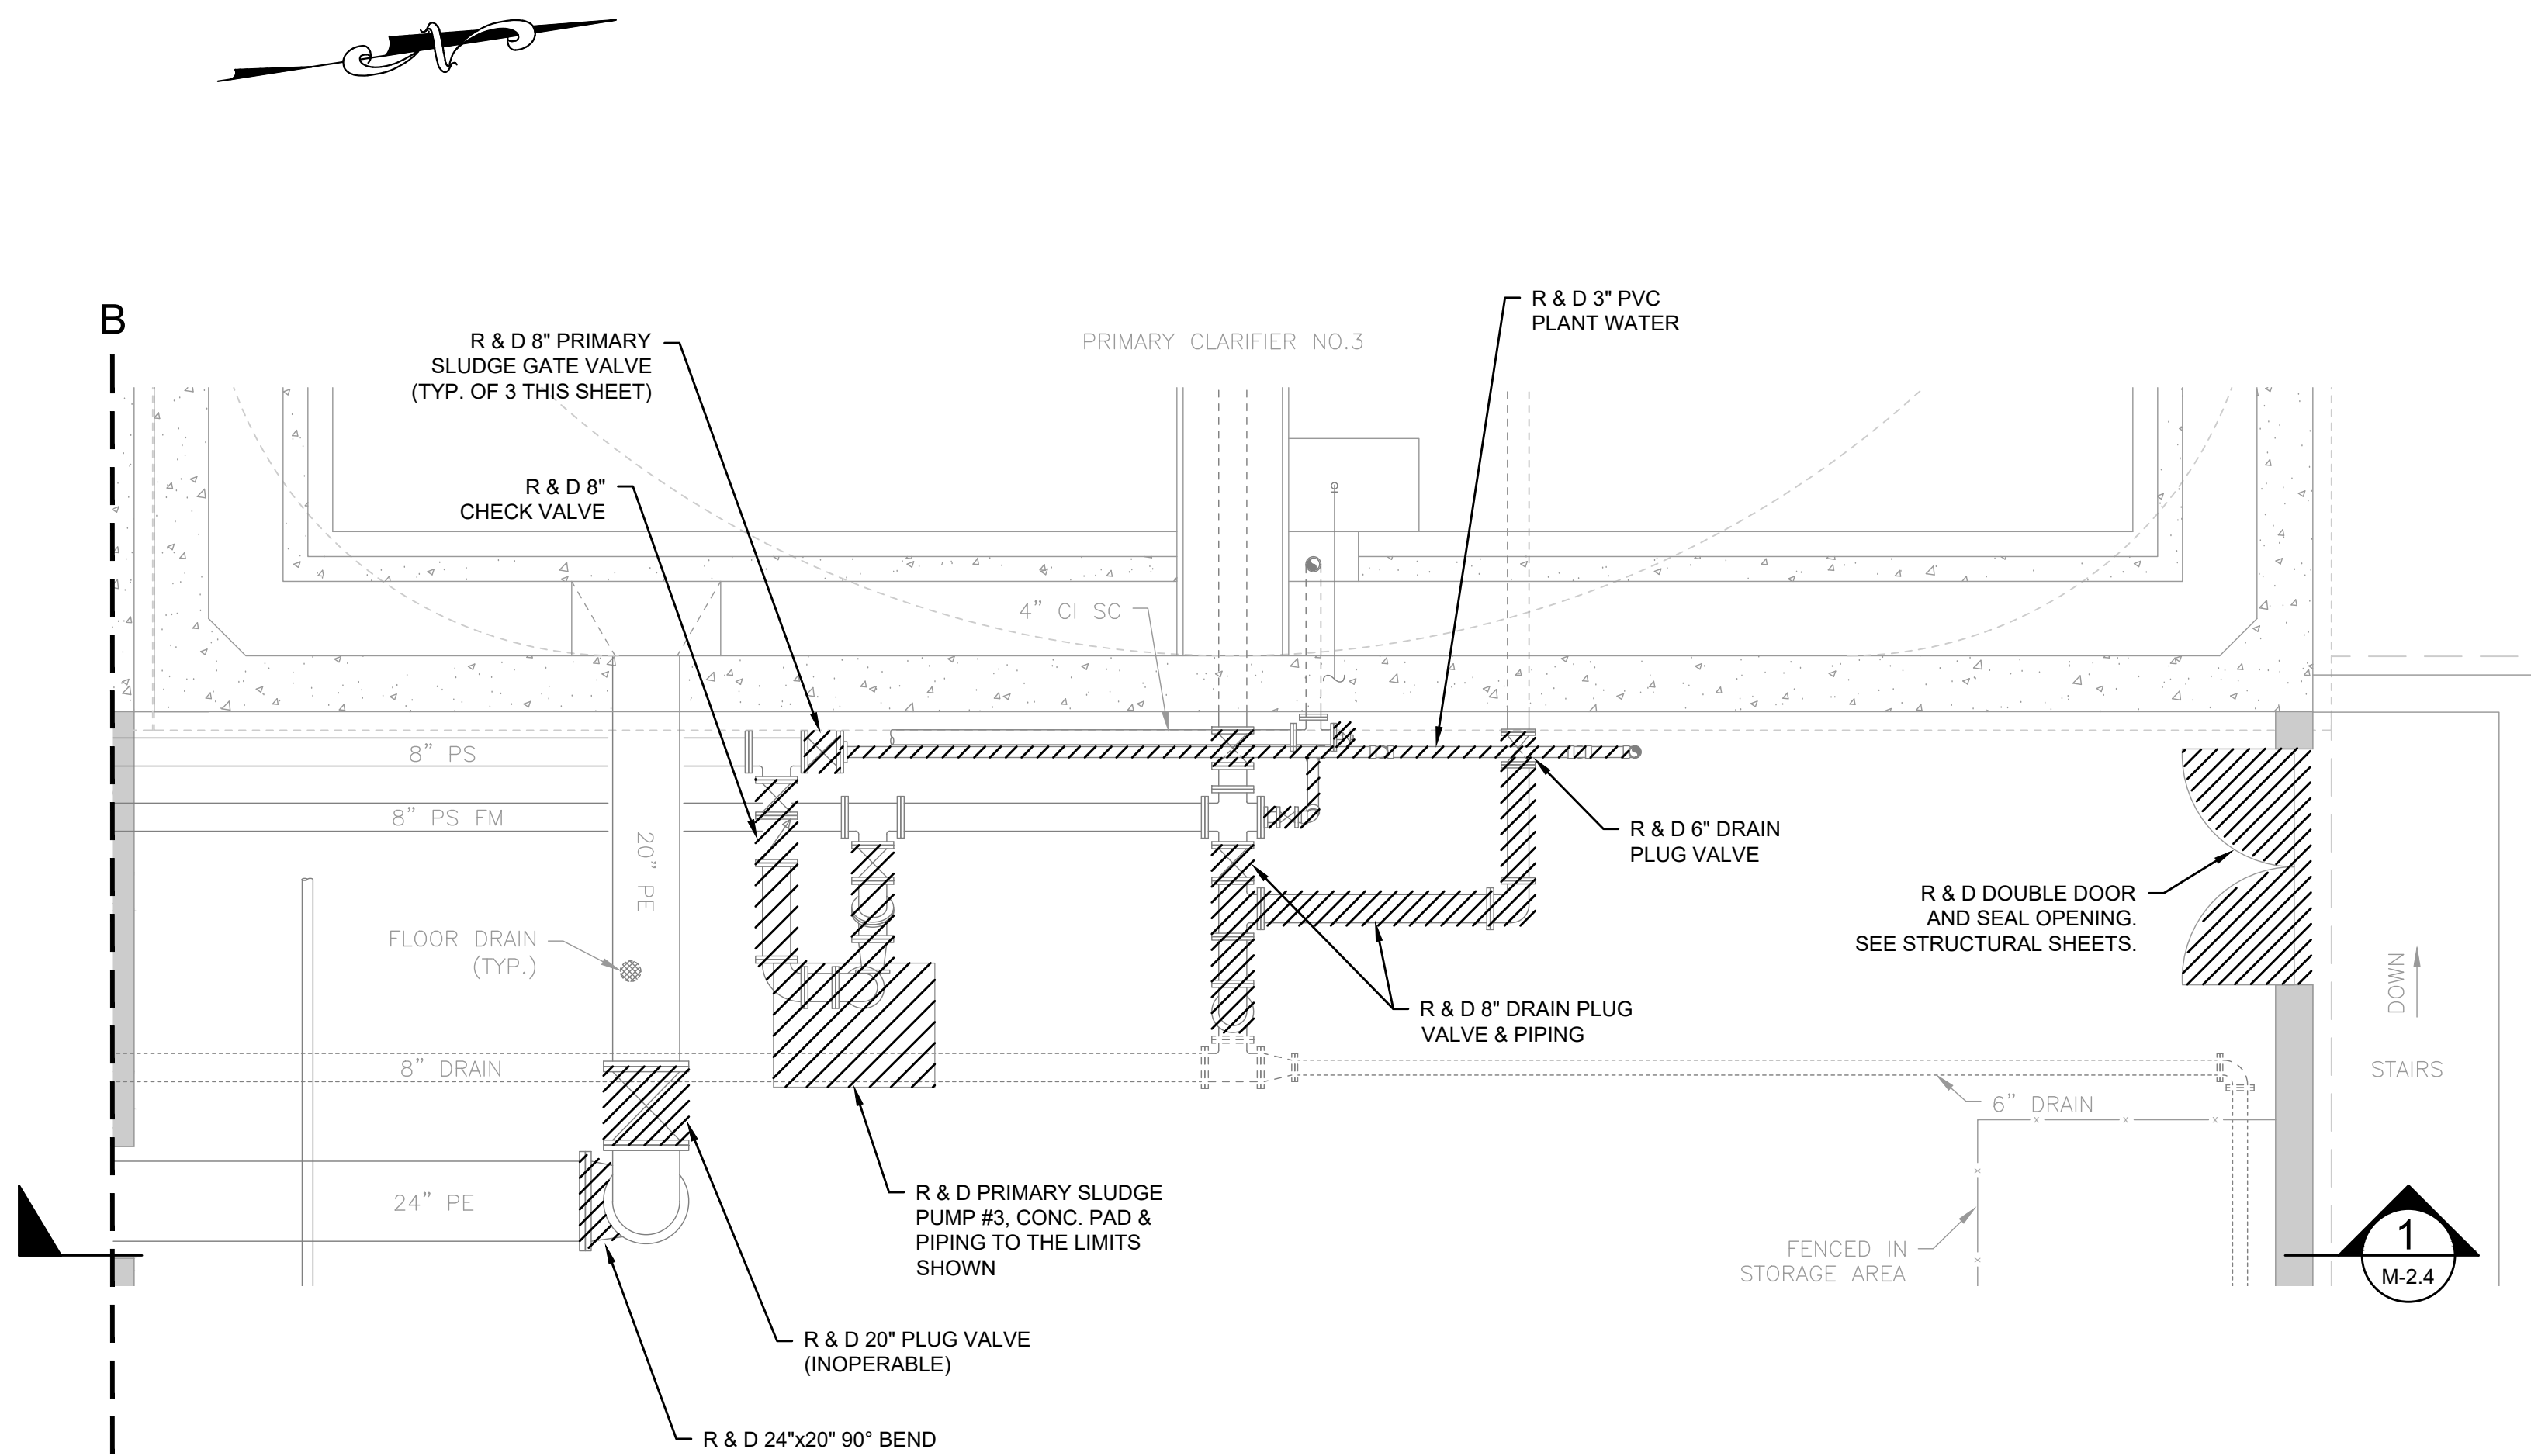


MATCH LINE A-A SHEET M-2.3

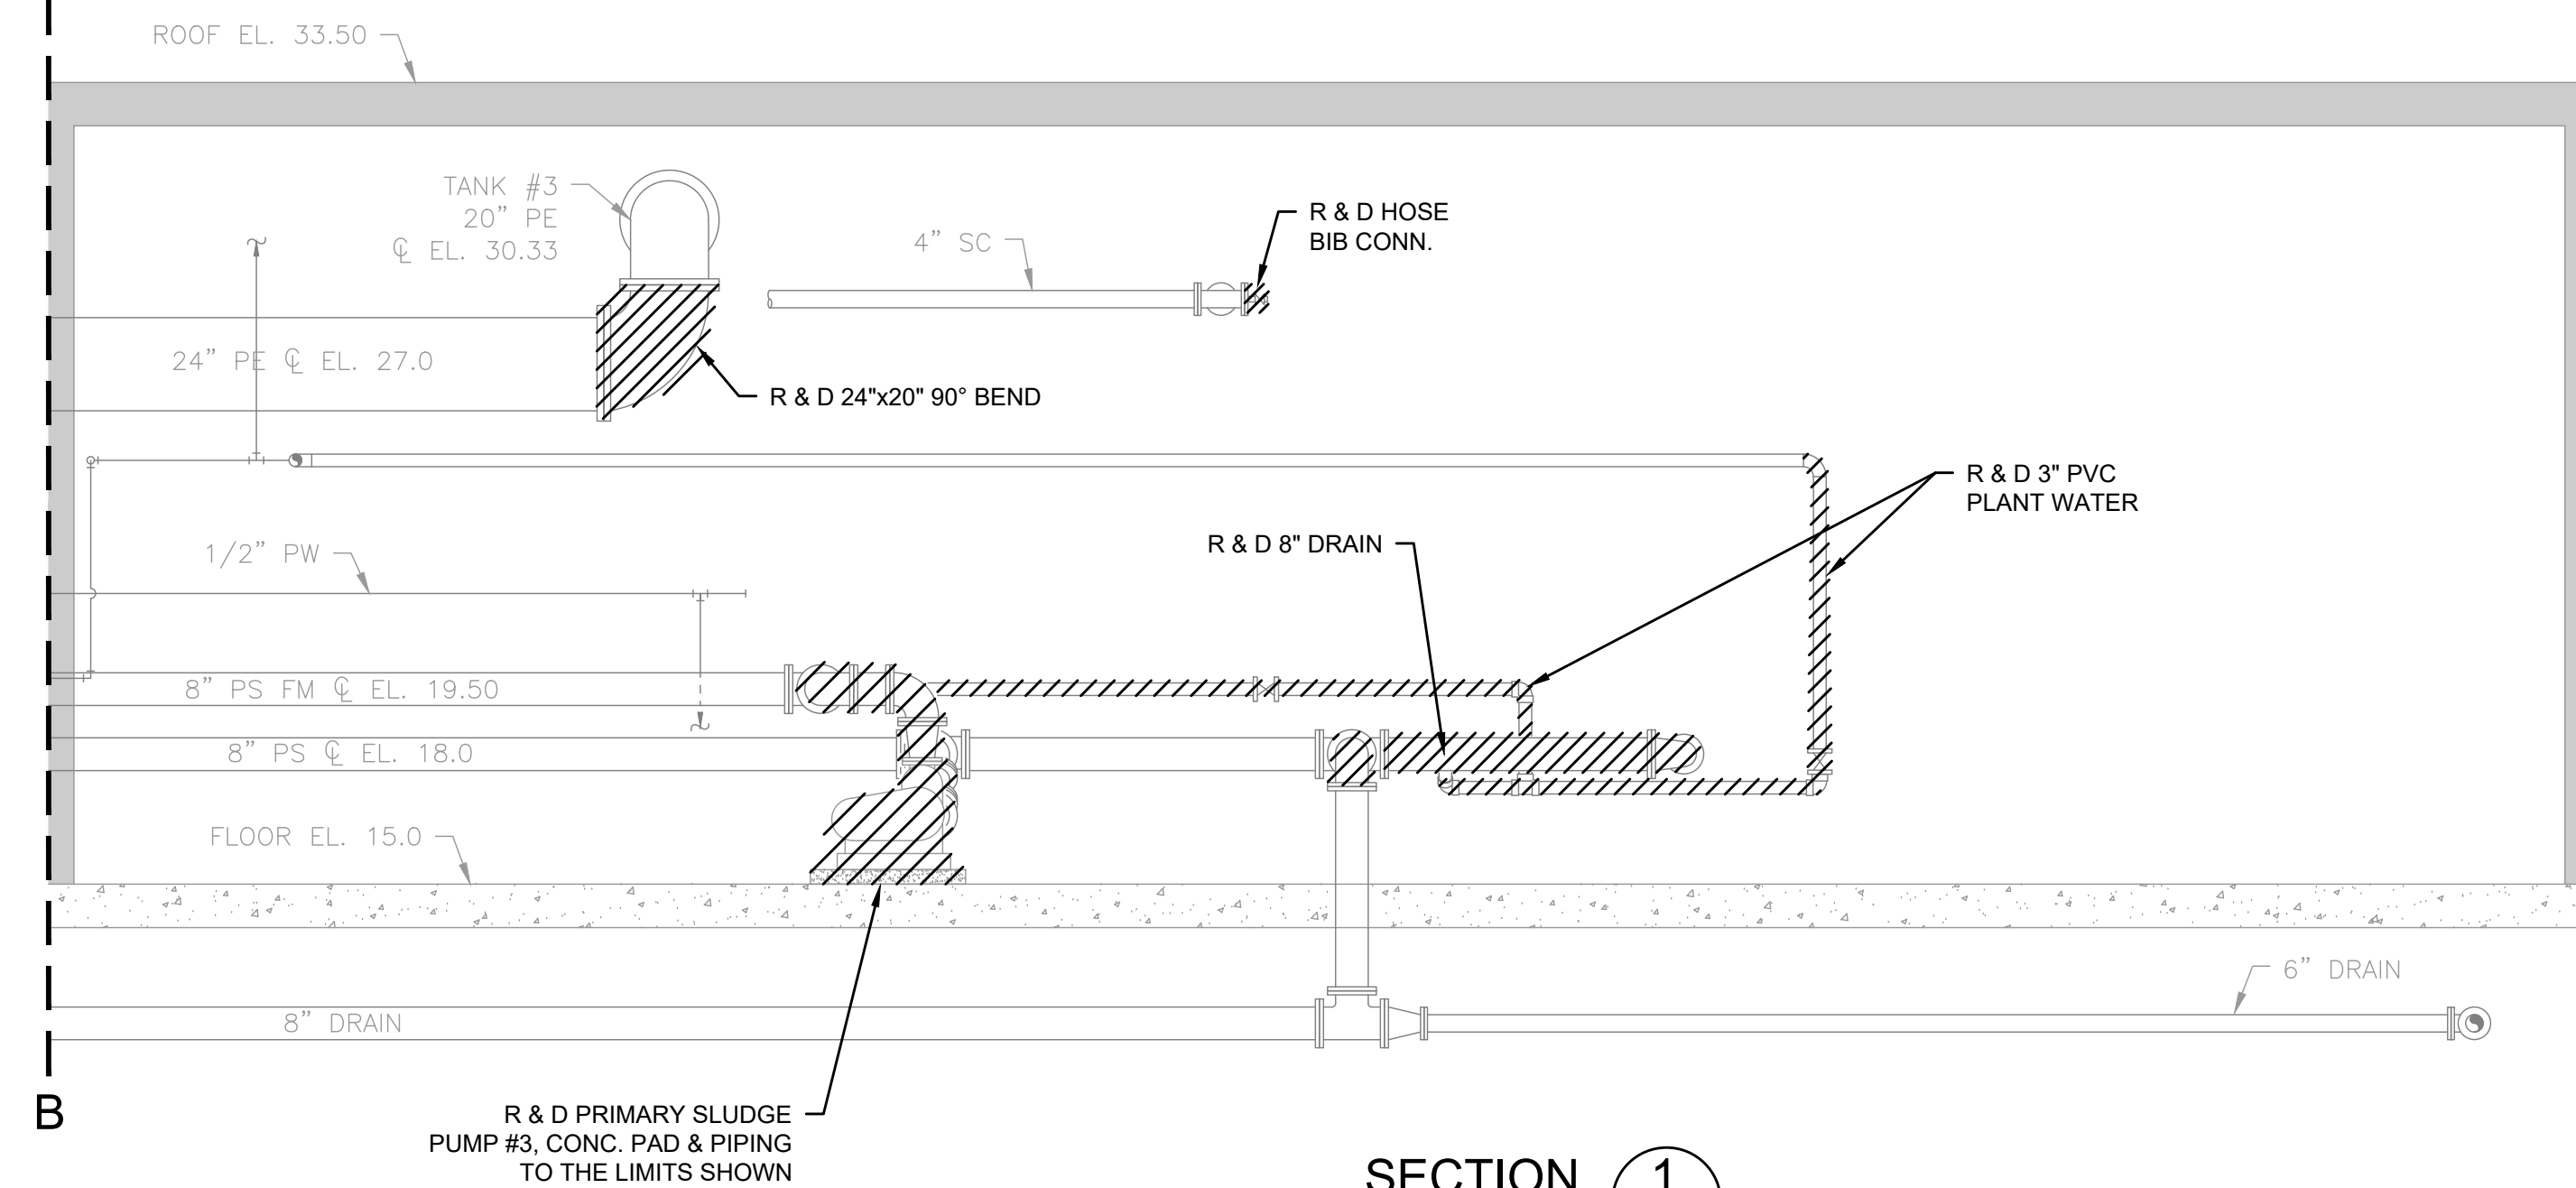

PREPARED BY



REGISTERED PROFESSIONAL

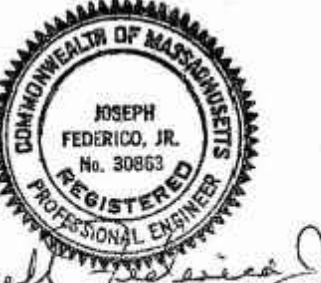

SUBCONSULTANT

PROJECT

**Taunton Wastewater
Treatment Facility
Improvements
Phase 1**

Taunton, MA

TITLE

**Primary Sludge Pump
Station Demolition
Plans & Sections II**

NO.	REVISIONS	DATE

SCALE


AS SHOWN

UNLESS OTHERWISE NOTED OR CHANGED BY REPRODUCTION

SHEET NO.

M-2.4


7/2/2021 10:34 AM J:\TAUNTON\WMTF DESIGN\AUTOCAD\PLAN SET\PHASE 1\PRIMARY CLARIFIERS & SLUDGE PS - EXIST. PLANS & SECTIONS.DWG (BETA STD BW.CTB)

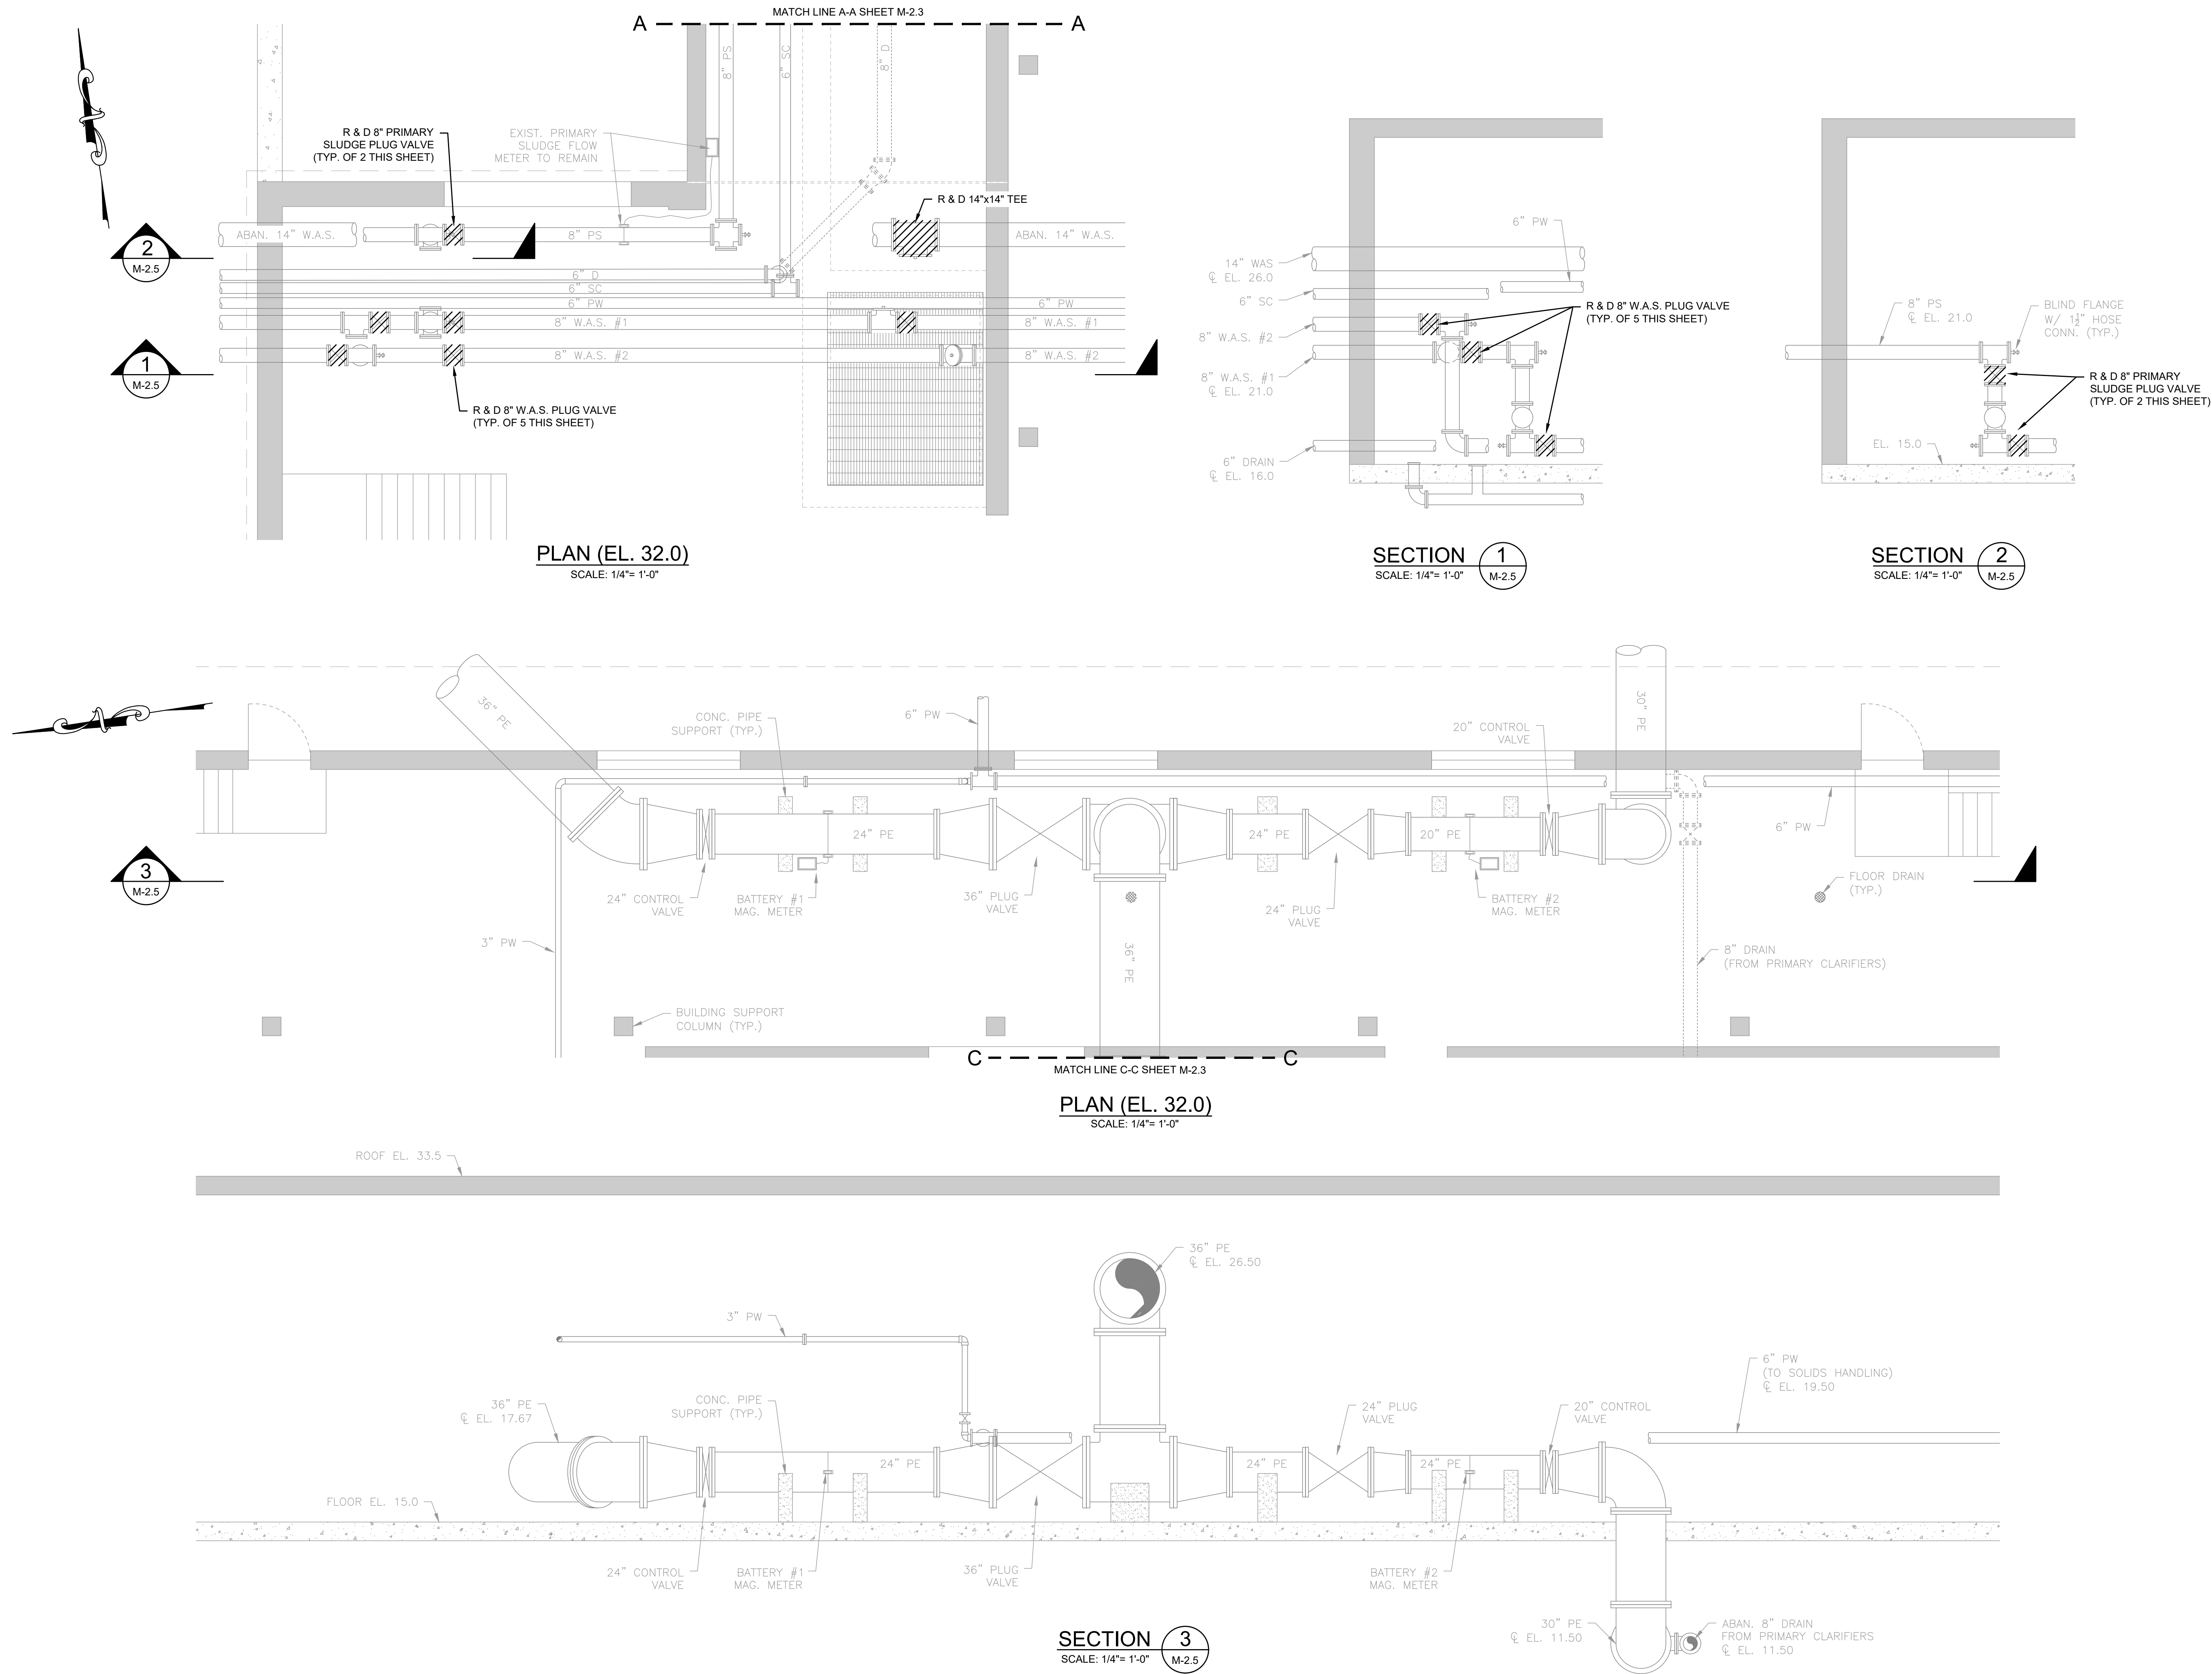

PREPARED BY



REGISTERED PROFESSIONAL

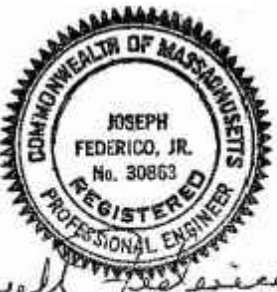

SUBCONSULTANT

PROJECT

Taunton Wastewater
Treatment Facility
Improvements
Phase 1

Taunton, MA

TITLE

Primary Sludge Pump
Station Demolition
Plans & Sections III

NO.	REVISIONS	DATE
-----	-----------	------

DRAWN BY:	BM
-----------	----

DESIGNED BY:	JD
--------------	----

CHECKED BY:	SR
-------------	----

ISSUE DATE:	7/2/2021
-------------	----------

BETA JOB NO.:	6050
---------------	------

SCALE


AS SHOWN

UNLESS OTHERWISE NOTED OR CHANGED BY REPRODUCTION

SHEET NO.

M-2.5

J:\TAUNTON\WTF DESIGN\AUTOCAD\PLAN SET\PHASE 1\PRIMARY CLARIFIERS & SLUDGE PS - PROP. PLANS & SECTIONS.DWG (BETA STD BW.CTB) 7/2/2021 10:34 AM

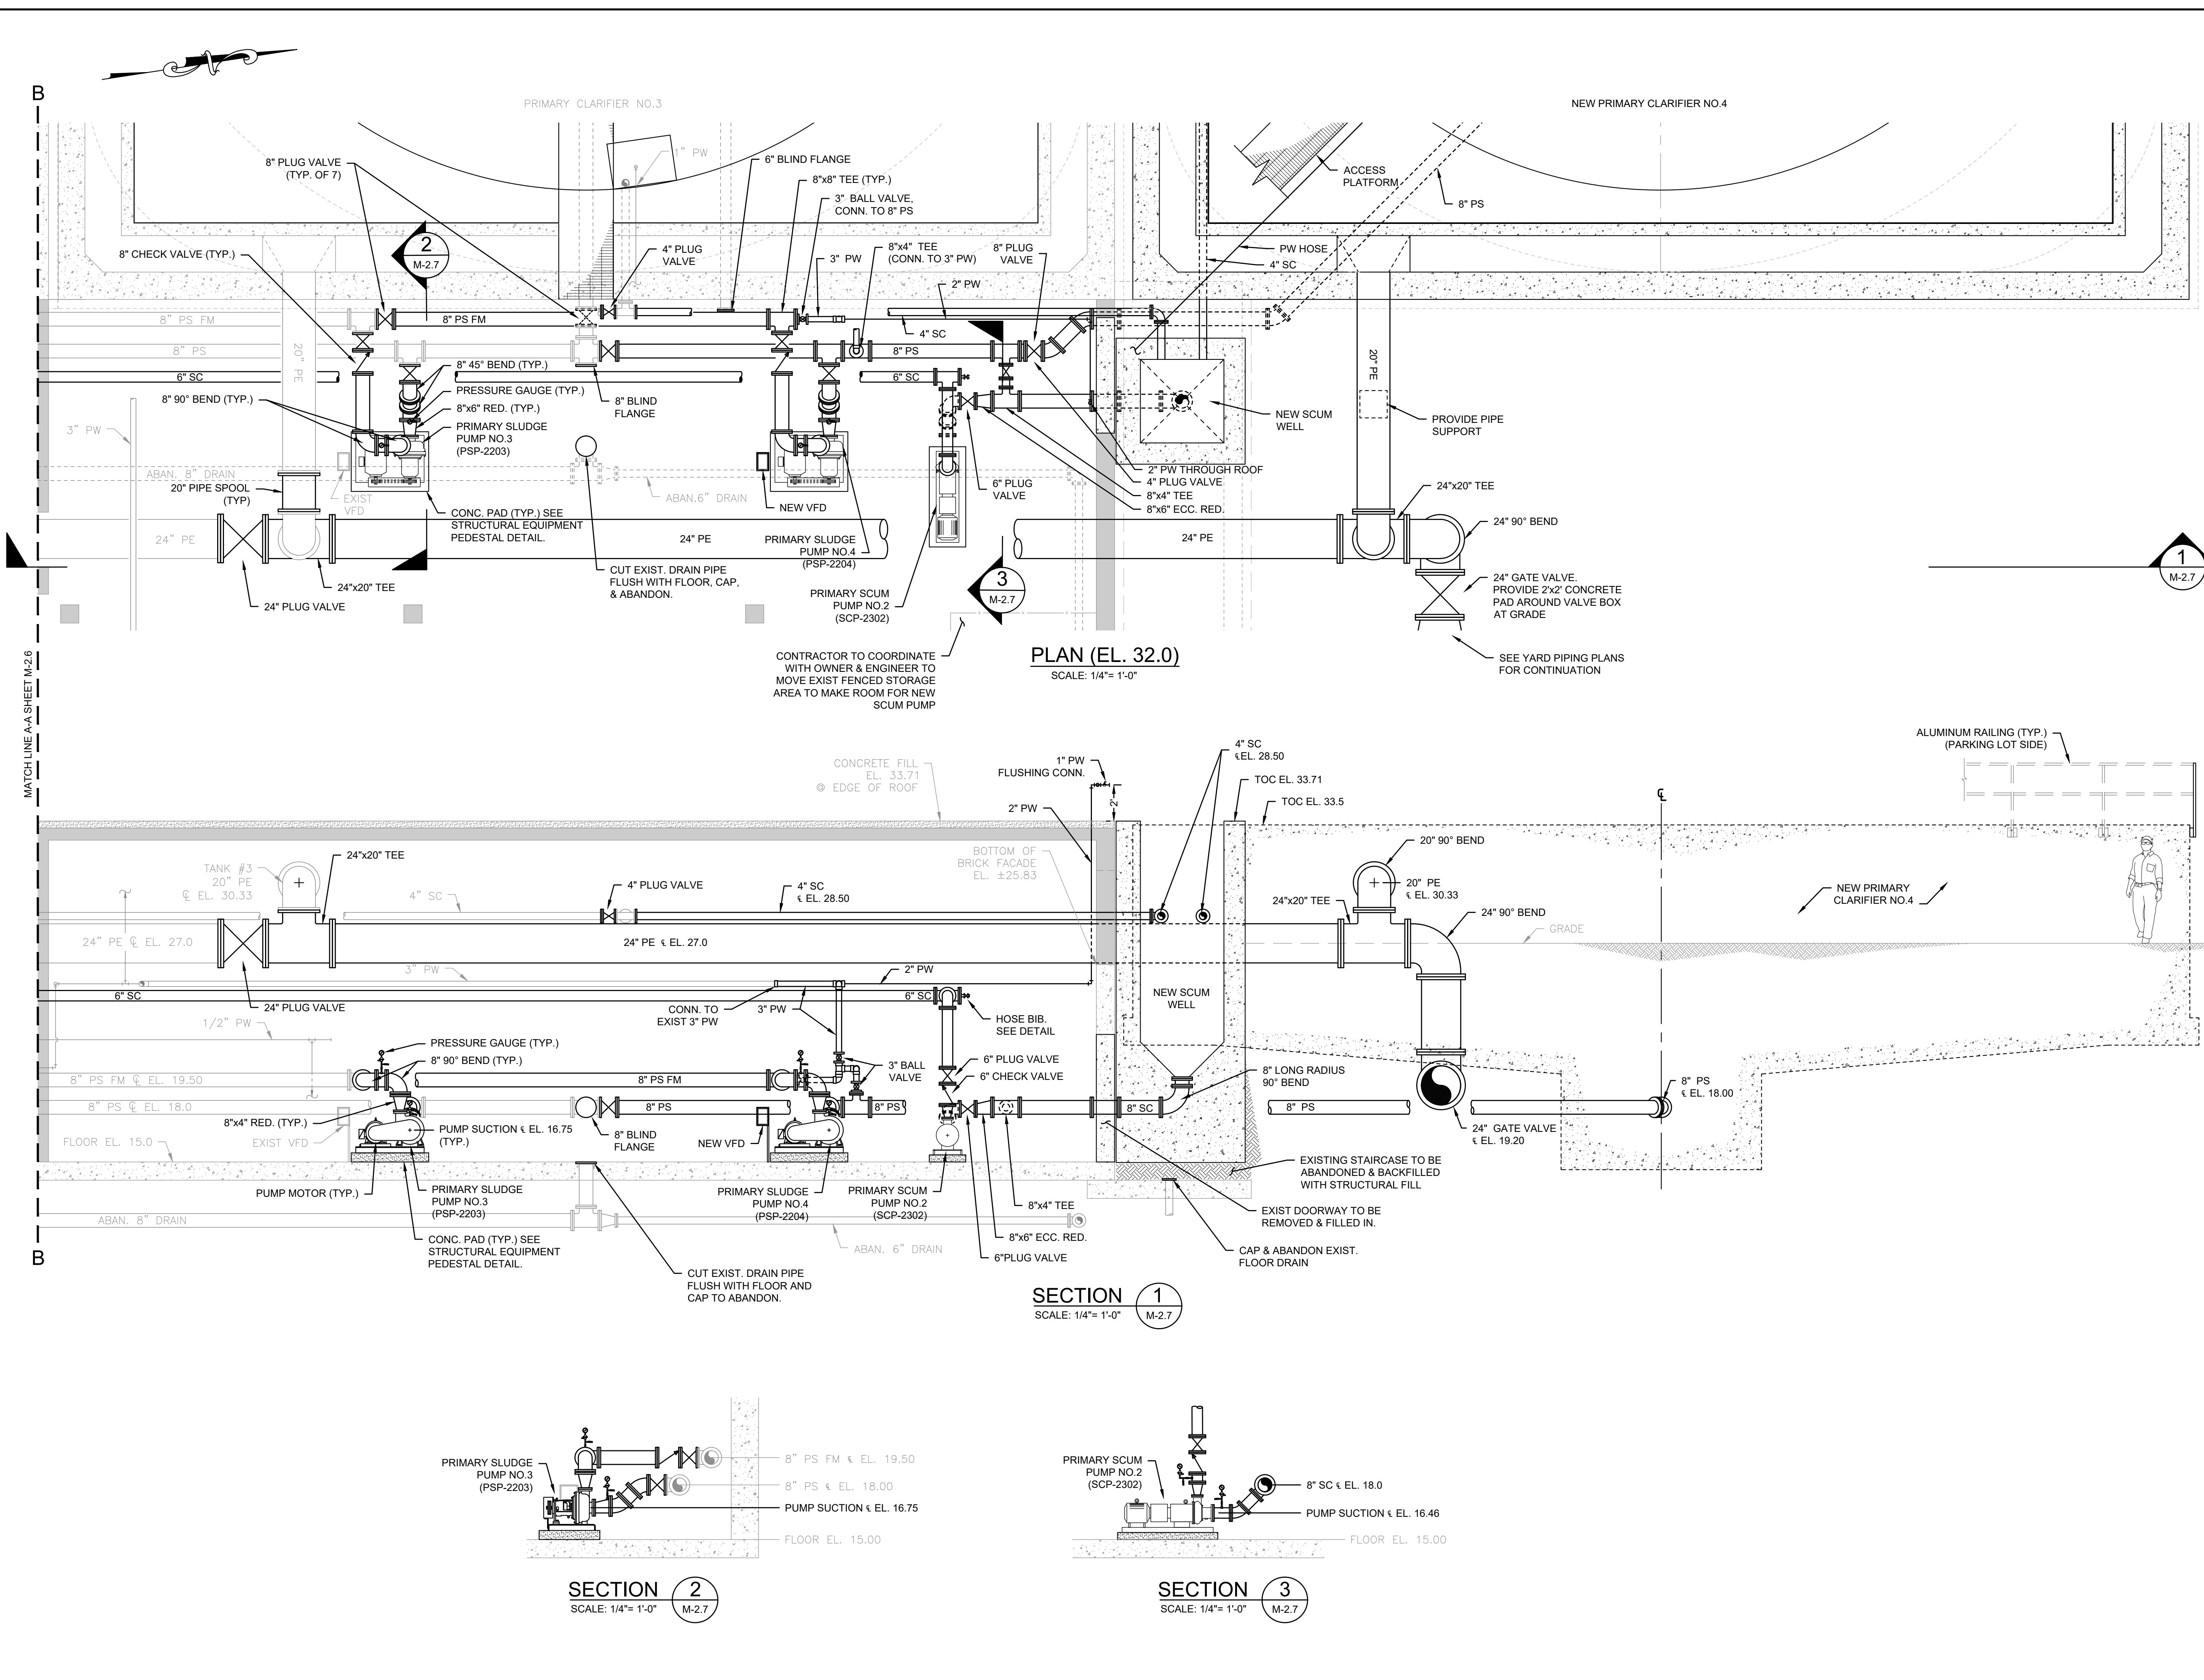

PREPARED BY


www.BETA-inc.com

REGISTERED PROFESSIONAL


Joseph F. Boudreau, Jr.

SUBCONSULTANT

PROJECT

Taunton Wastewater Treatment Facility Improvements Phase 1

Taunton, MA

TITLE

Primary Sludge Pump Station Plans & Sections II

NO.	REVISIONS	DATE

SCALE




AS SHOWN

SHEET NO.

M-2.7

UNLESS OTHERWISE NOTED OR CHANGED BY REPRODUCTION

7/2/2021 10:34 AM J:\TAUNTON\WMTF DESIGN\AUTOCAD\PLAN SET\PHASE 1\PRIMARY CLARIFIERS & SLUDGE PS - PROP. PLANS & SECTIONS.DWG (BETA STD BW.CTB)

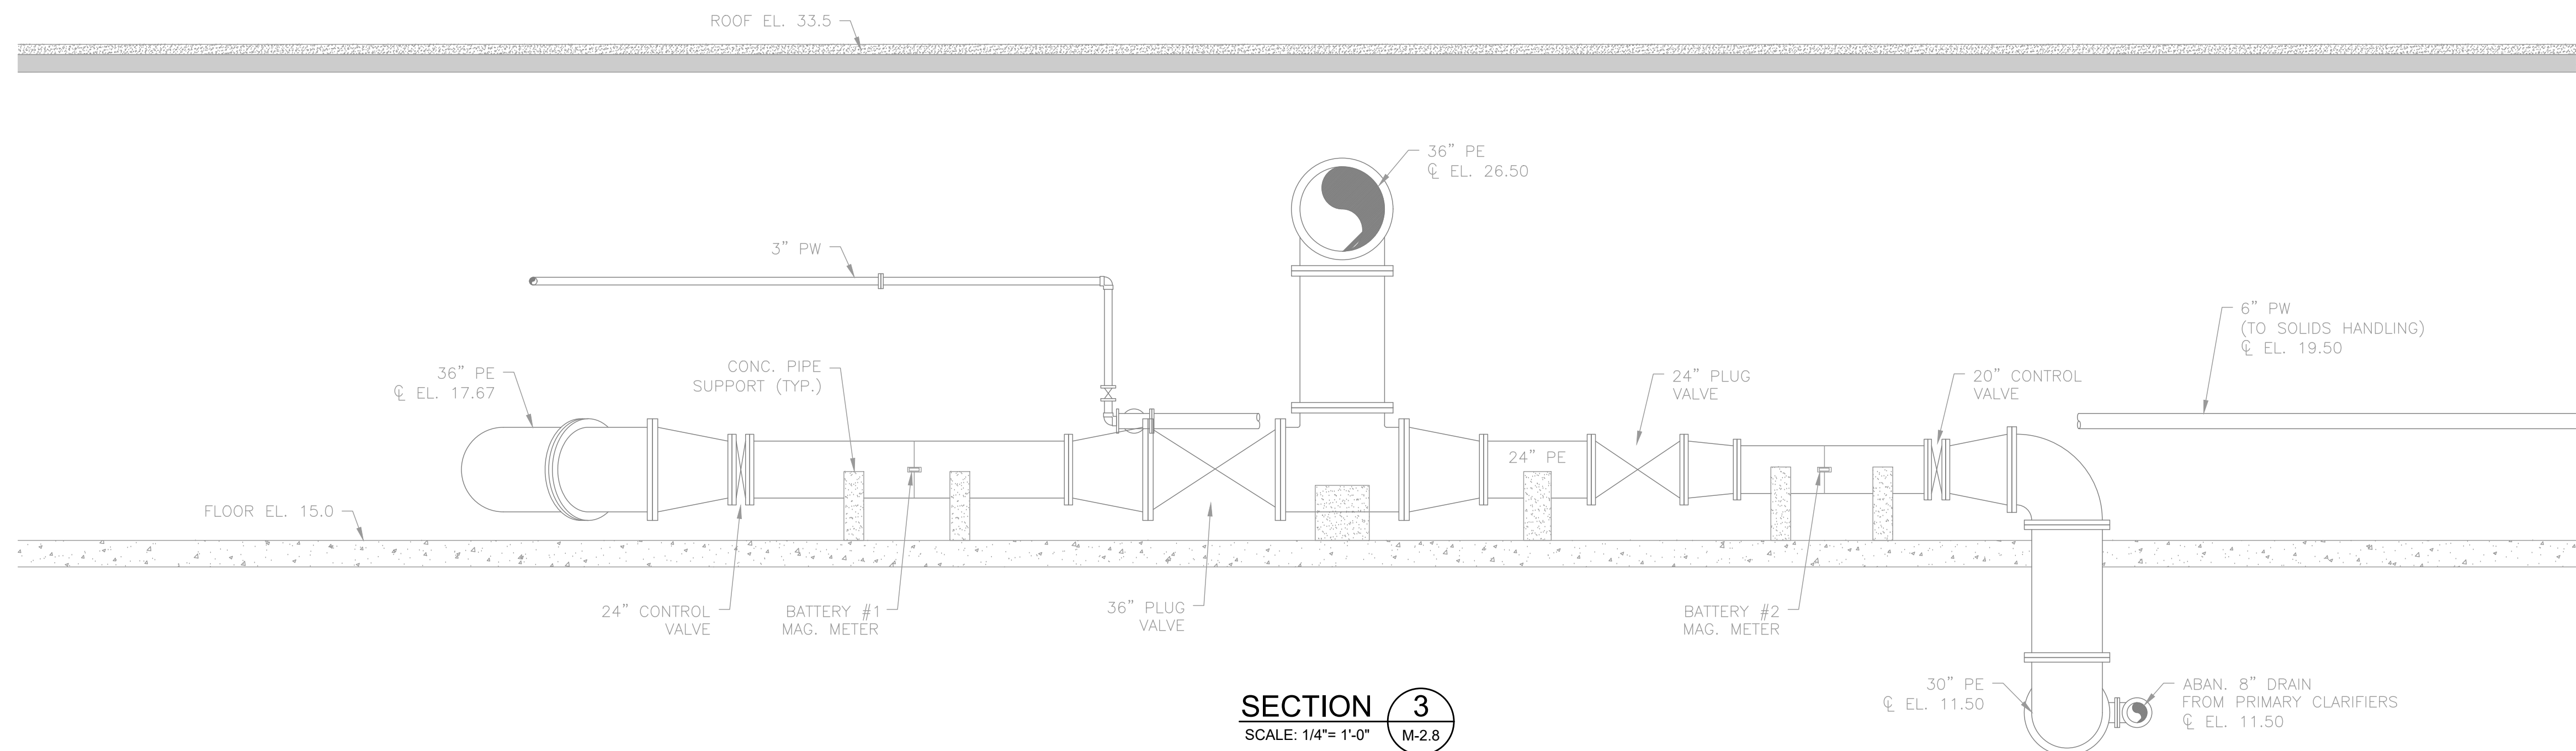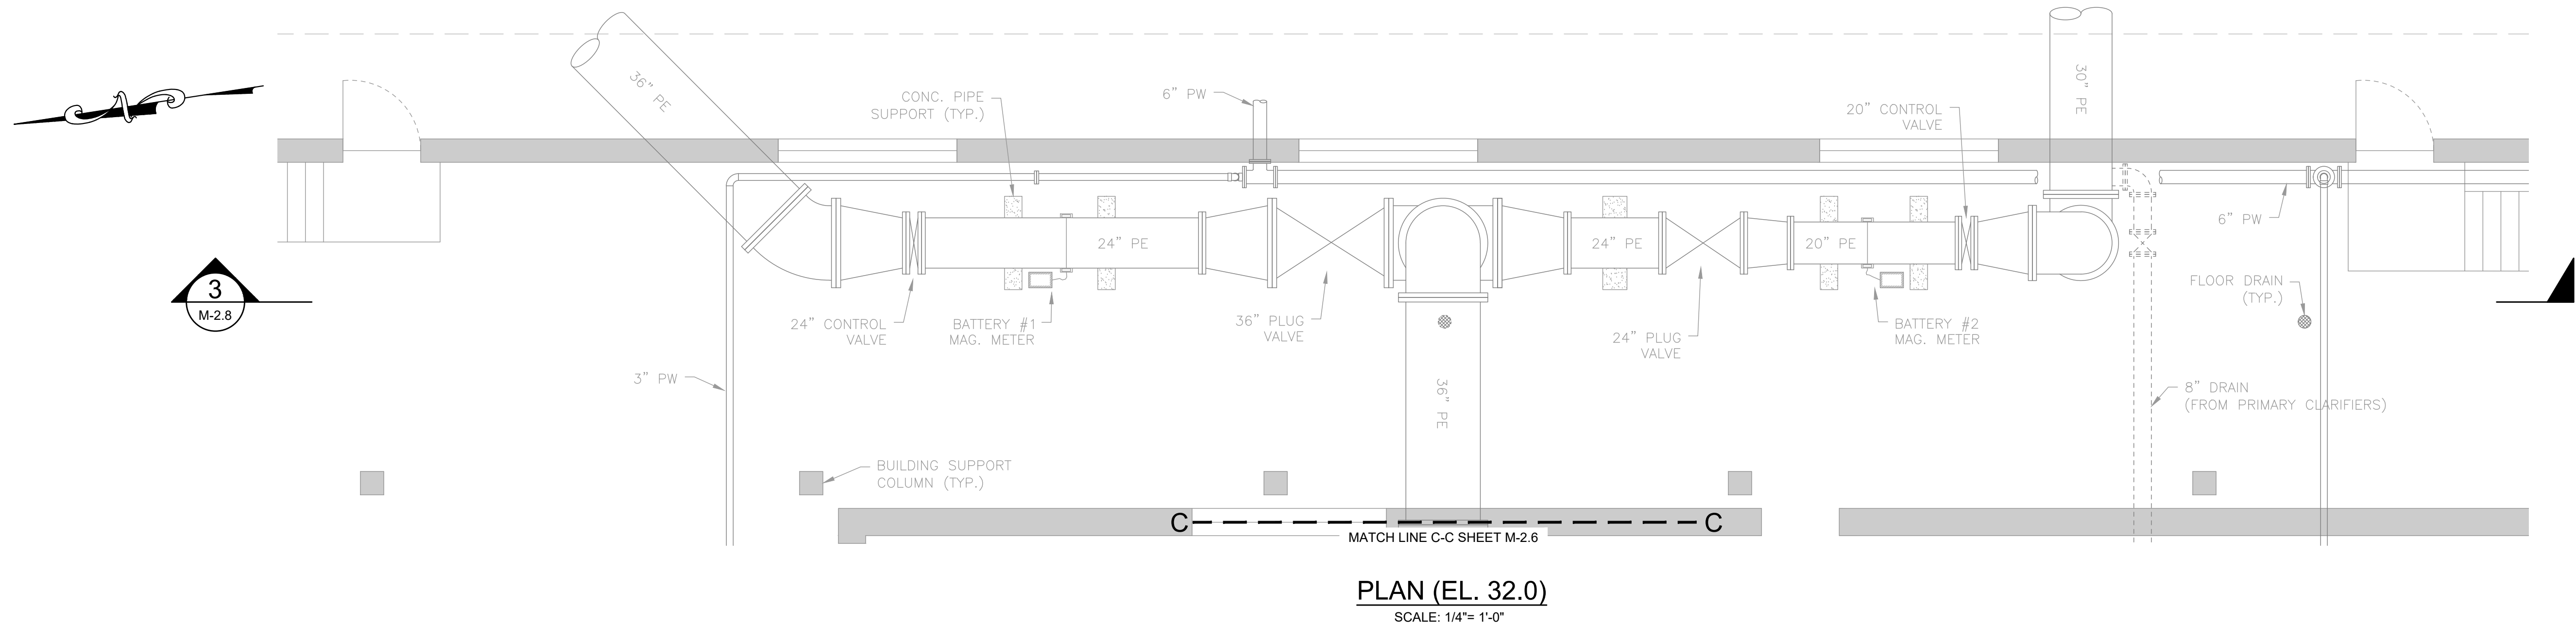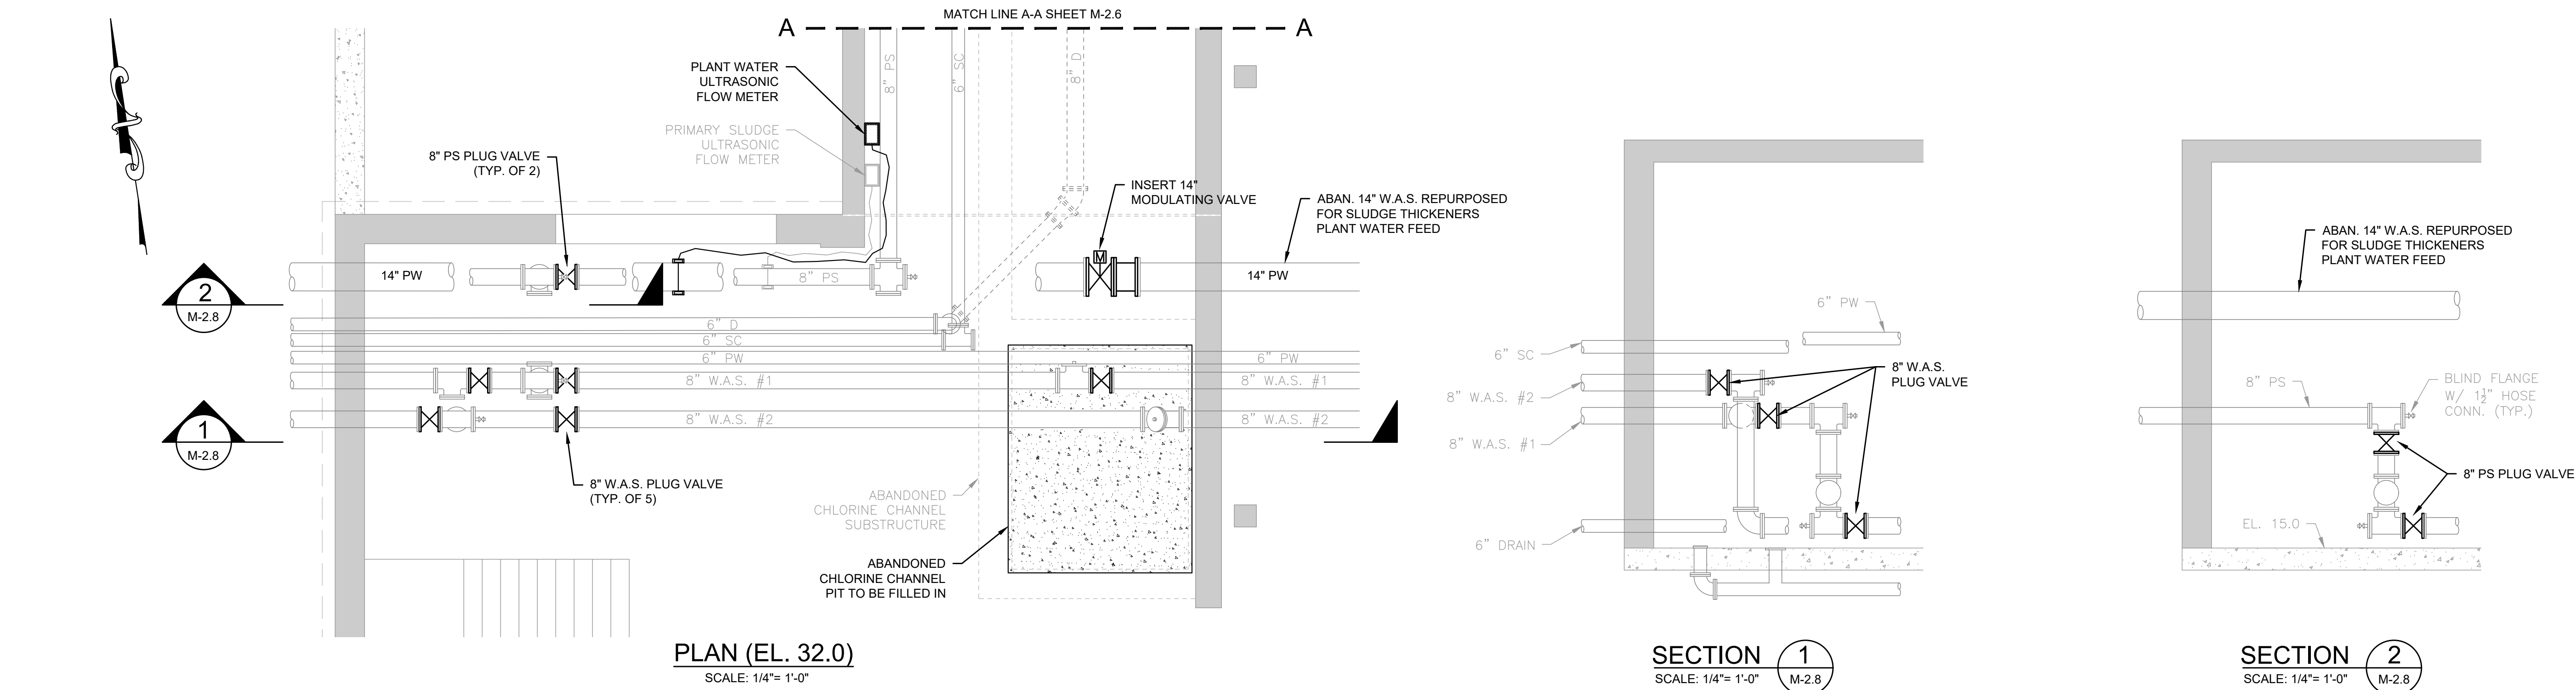

PREPARED BY



REGISTERED PROFESSIONAL



SUBCONSULTANT

PROJECT

**Taunton Wastewater
Treatment Facility
Improvements
Phase 1**

Taunton, MA

TITLE

**Primary Sludge
Pump Station
Plans & Sections III**

NO.	REVISIONS	DATE


SCALE

AS SHOWN


UNLESS OTHERWISE NOTED OR CHANGED BY REPRODUCTION

SHEET NO.


M-2.8

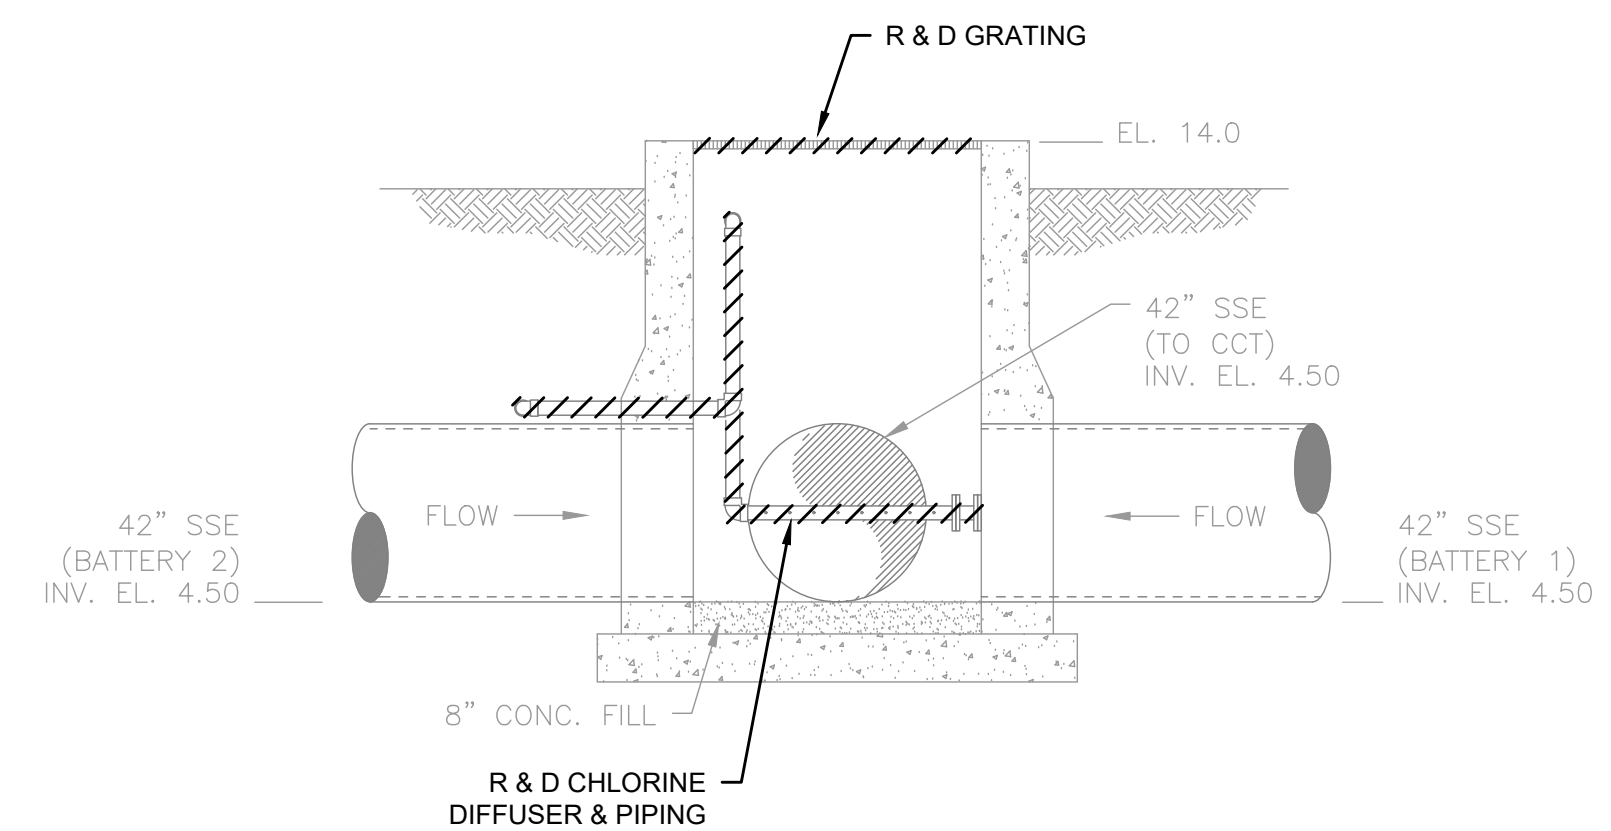

SECTION 4
SCALE: 1/4" = 1'-0"
M-5.1

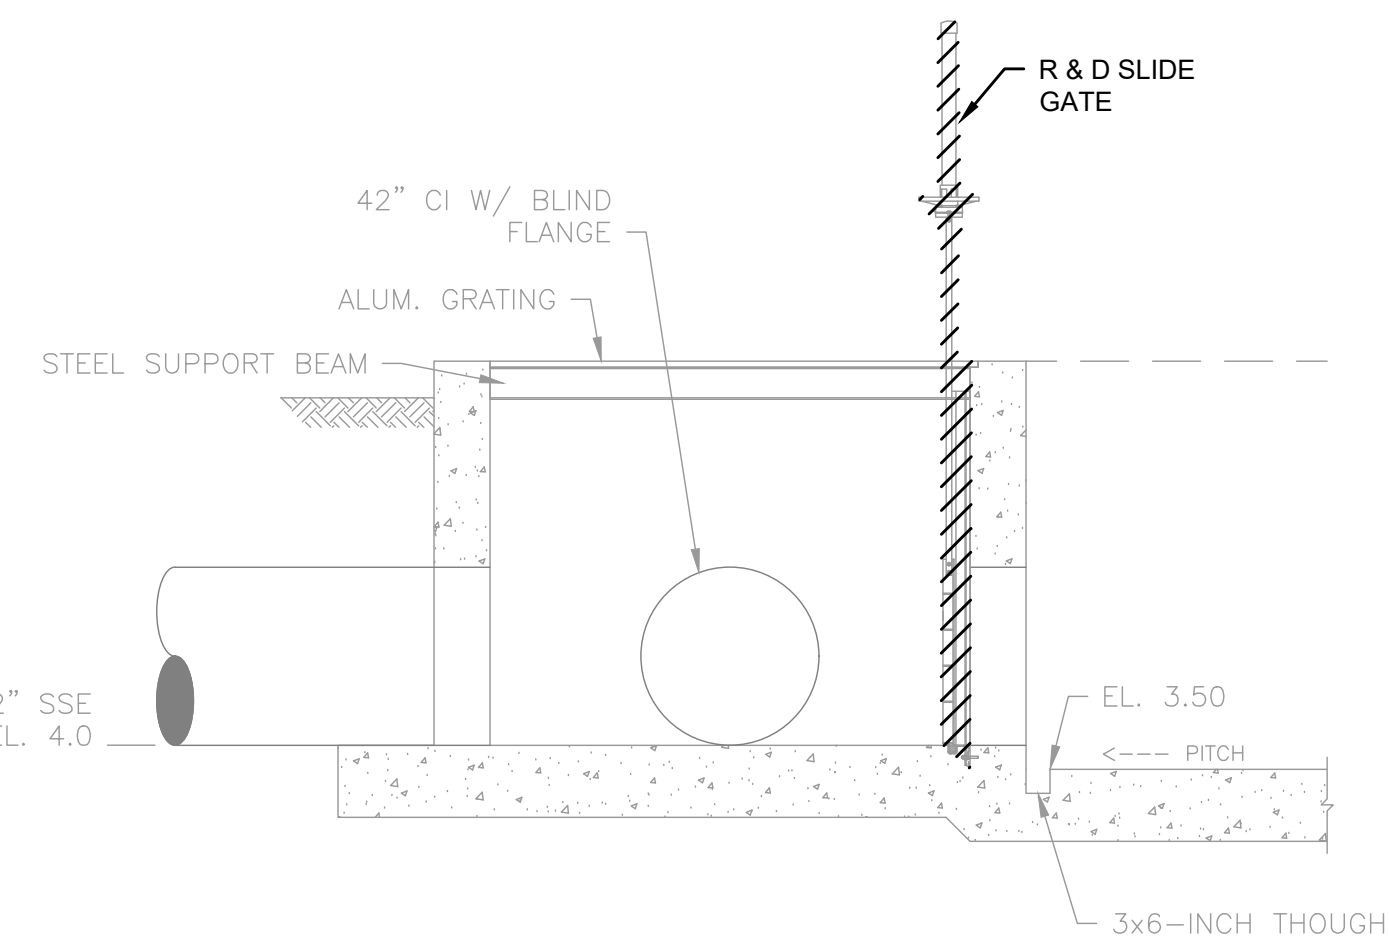

SECTION 1
SCALE: 1/4" = 1'-0"






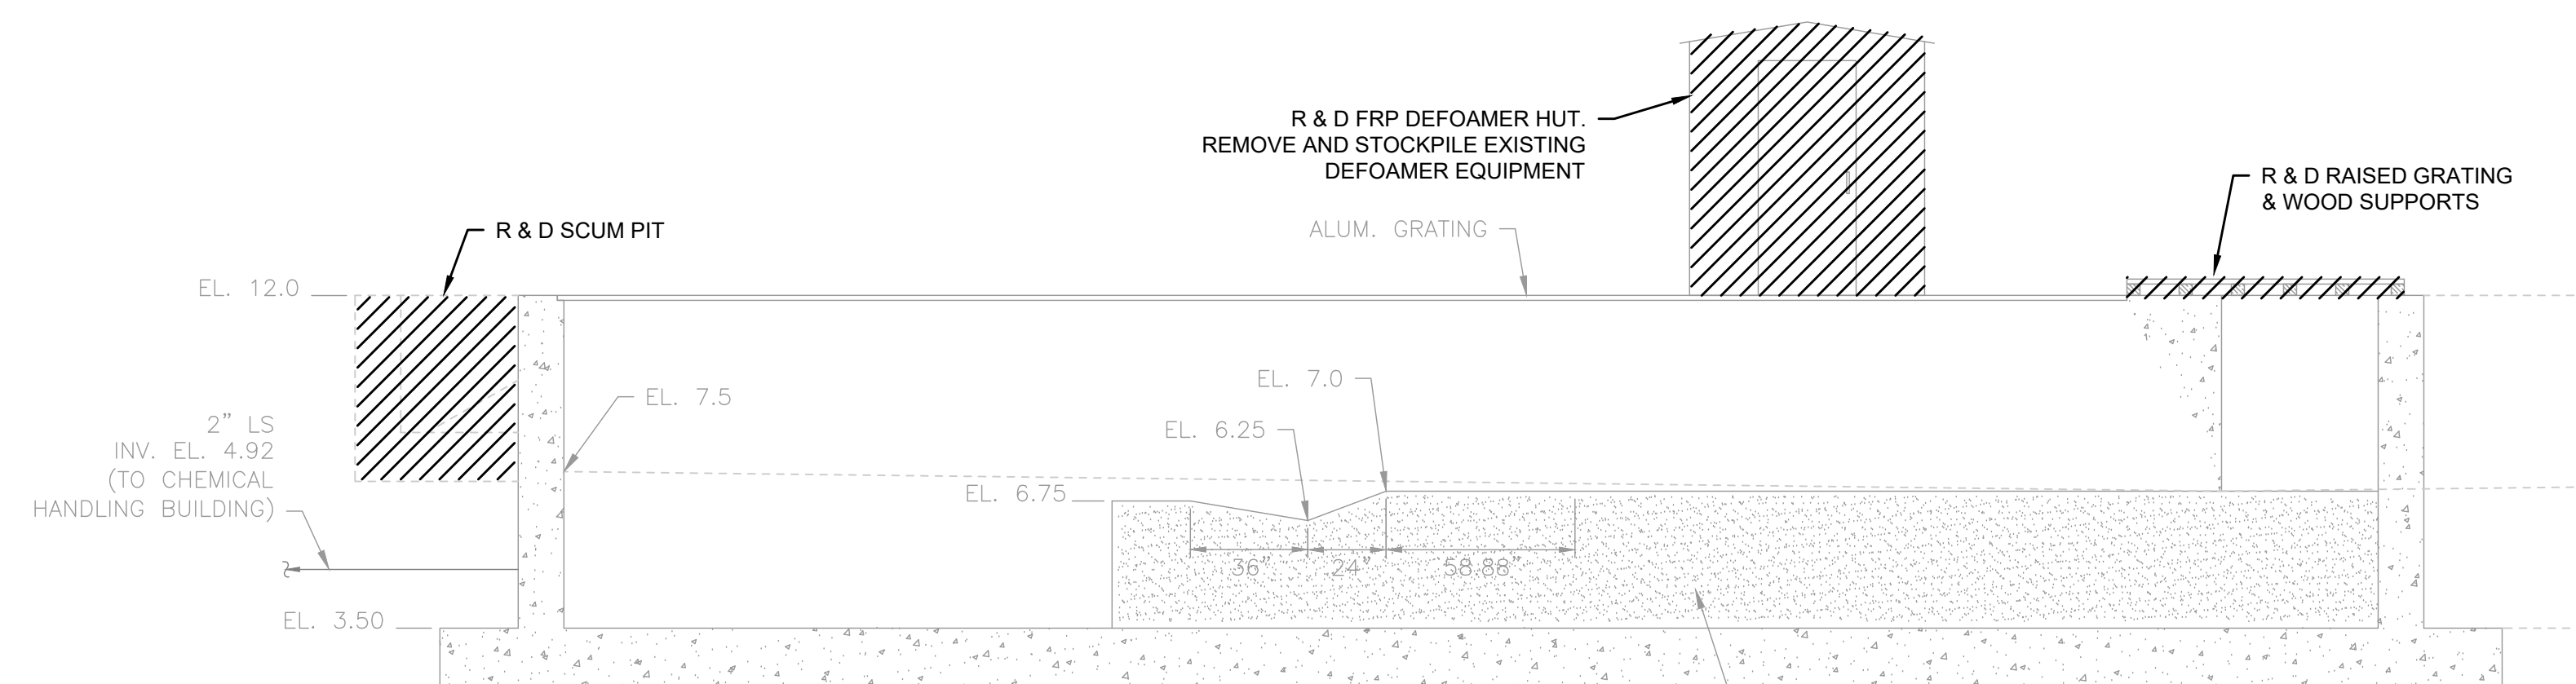


SECTION 3
SCALE: 1/4" = 1'-0" M-5.1

M-5.1

SLIDE GATE SCHEDULE - CHLORINE CONTACT TANK										
GATE TAG	LOCATION	MOUNTING TYPE	TYPE	OPENING WIDTH (IN)	OPENING HEIGHT (IN)	OPENING DIAMETER (IN)	GATE MATERIAL ^A	OPERATOR	OPENING INVERT EL. (FT)	OPERATING FLOOR EL. (FT)
SG-13	CHLORINE CONTACT TANK INFLUENT	WALL	SELF CONTAINED RISING STEM	42	42	—	6061-T6 ALUMINUM	MANUAL	4.00	12.00
SG-14	CHLORINE CONTACT TANK INFLUENT	WALL	SELF CONTAINED RISING STEM	42	42	—	6061-T6 ALUMINUM	MANUAL	4.00	12.00

^A FRP SLIDE GATES WILL BE CONSIDERED PROVIDED THEY MEET PERFORMANCE SPECIFICATIONS

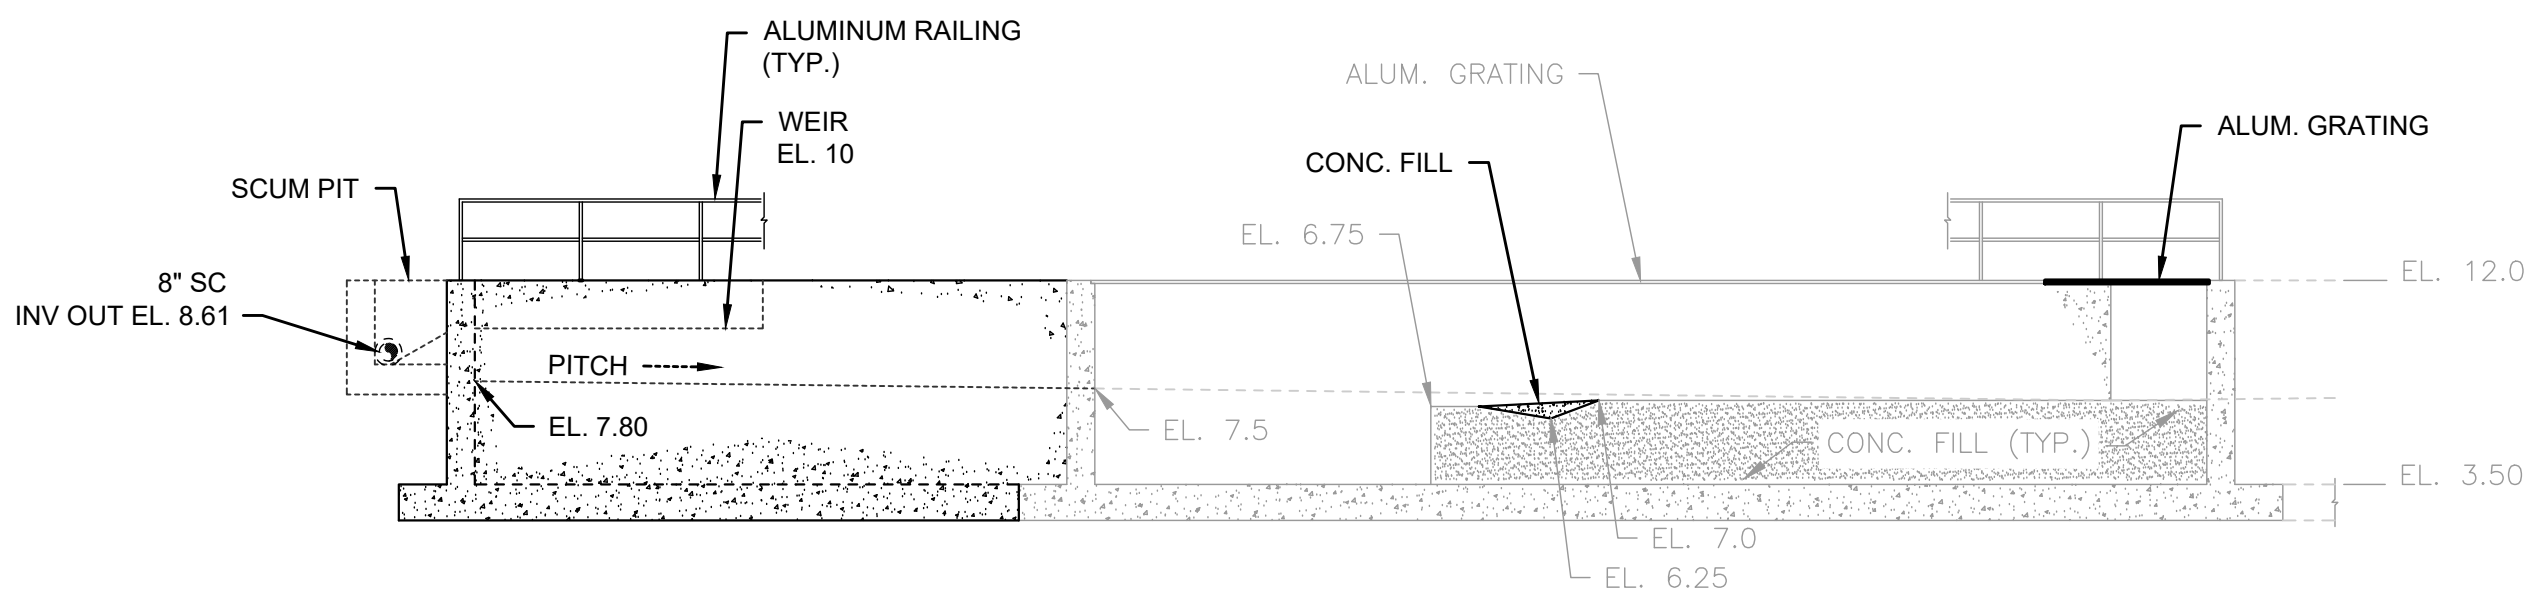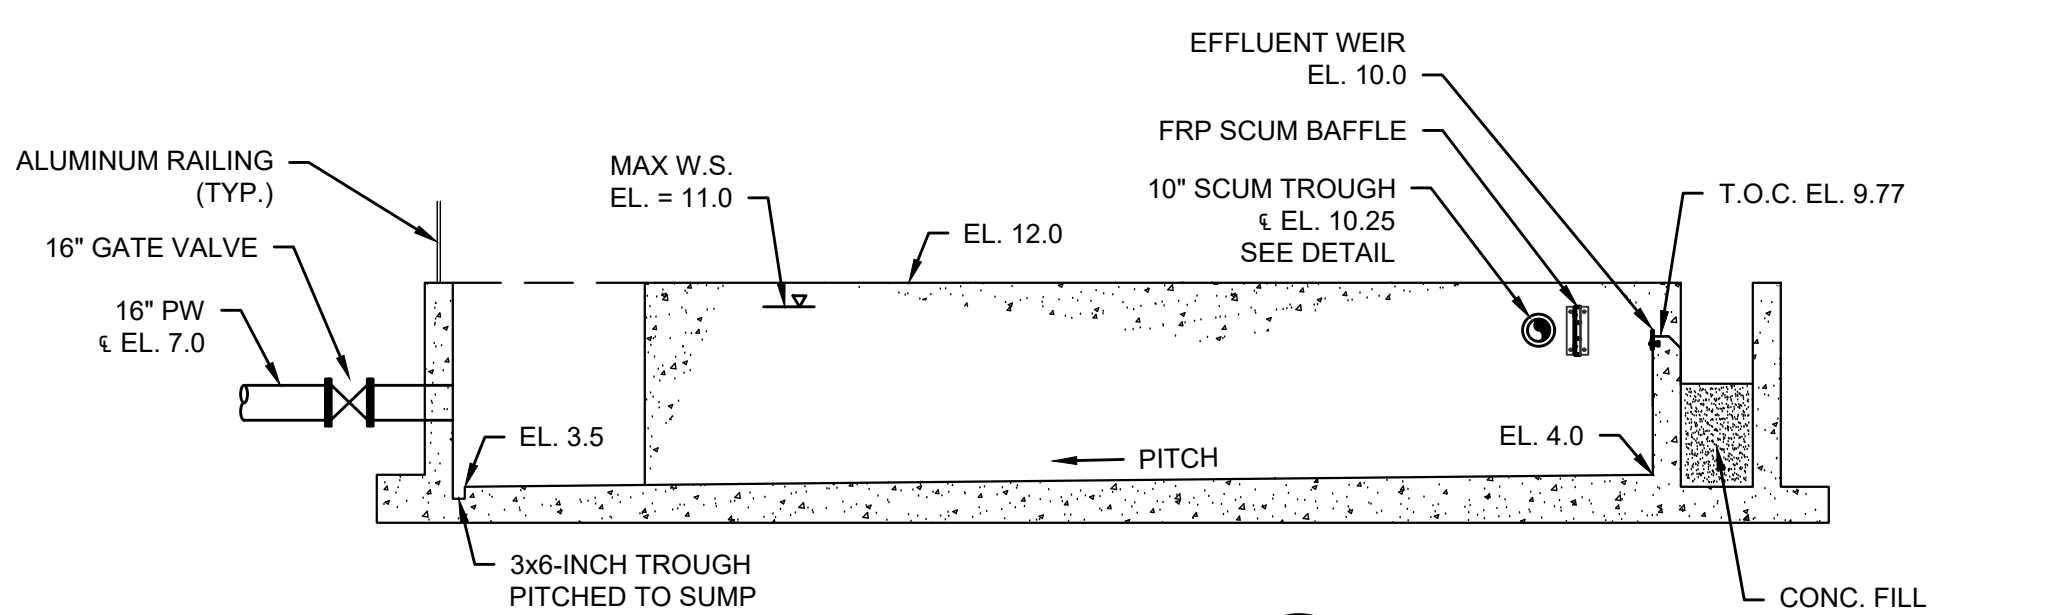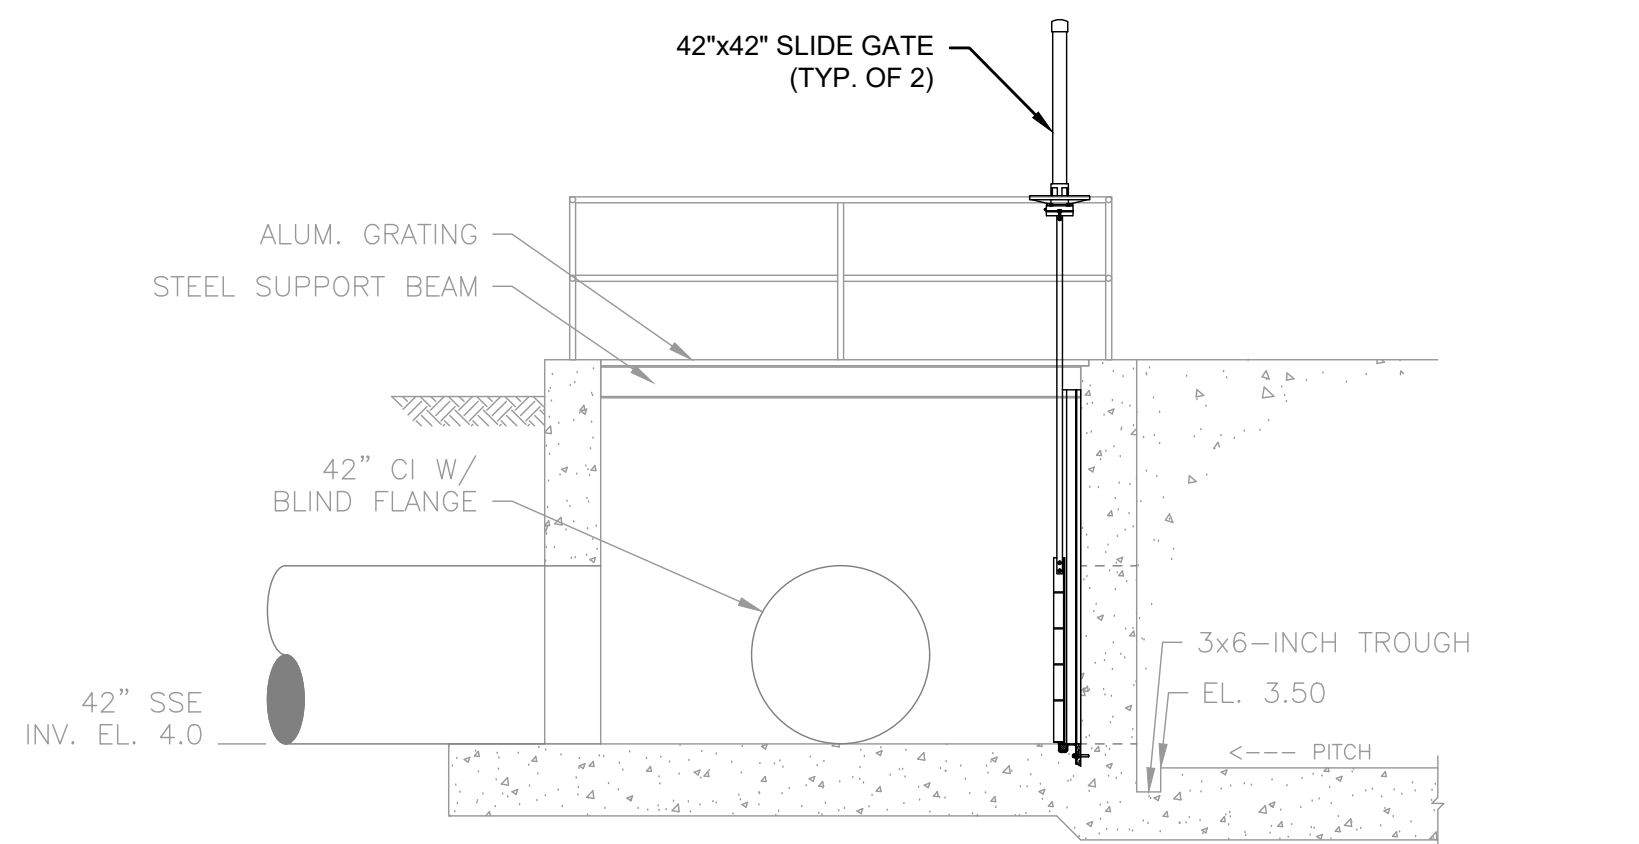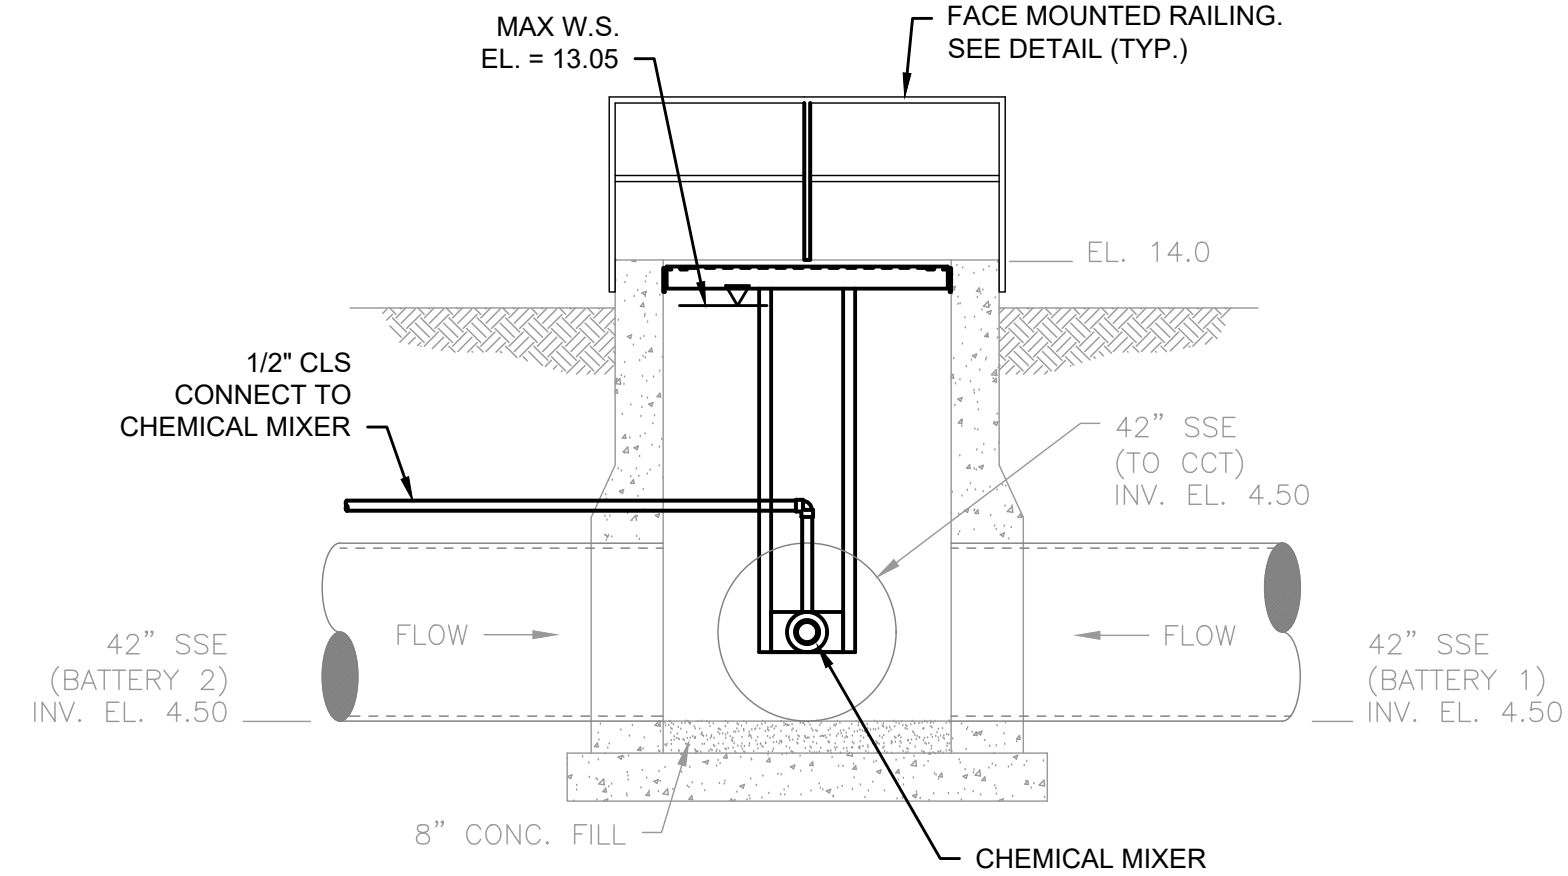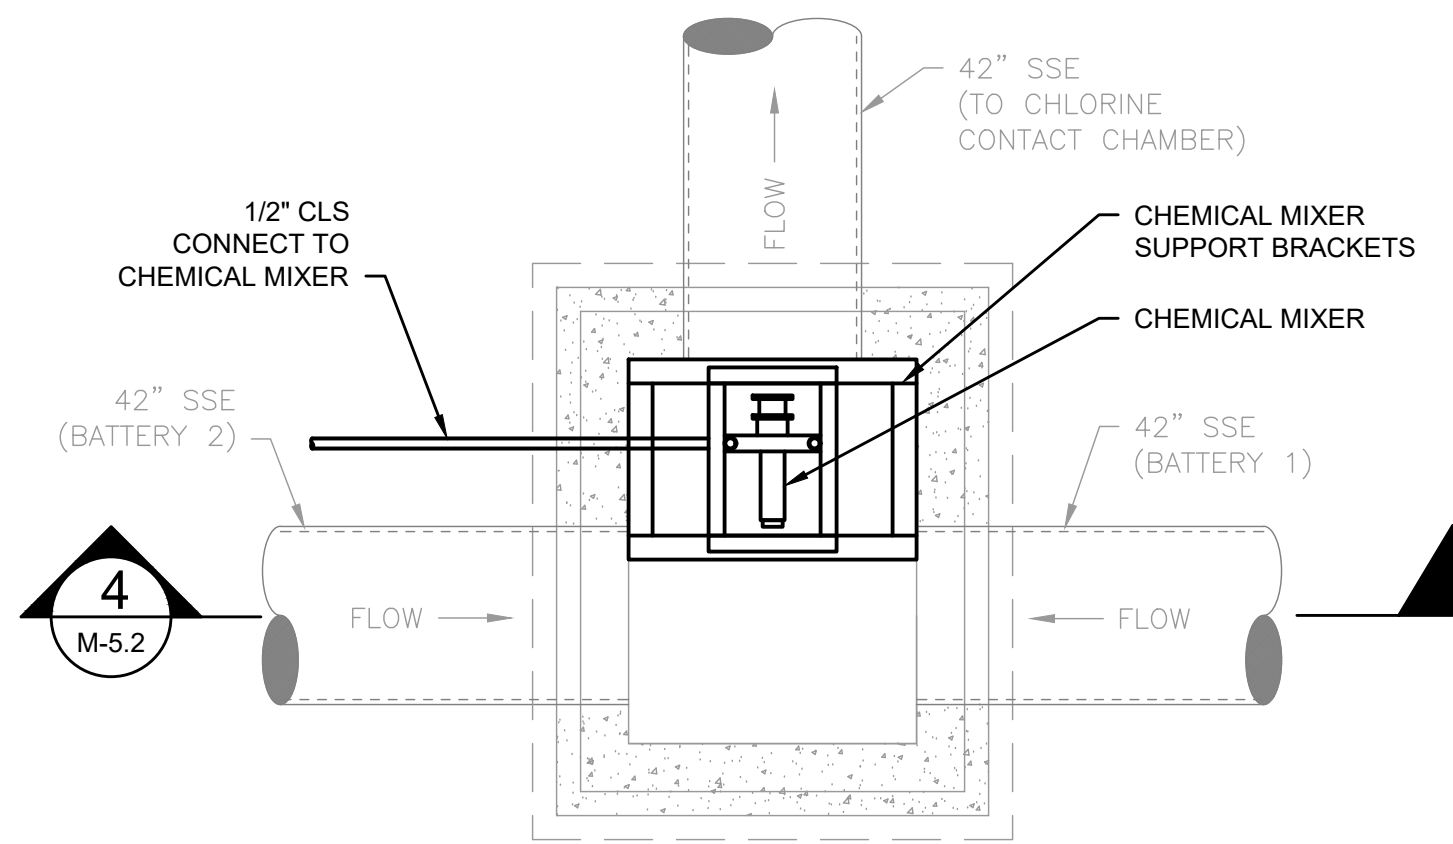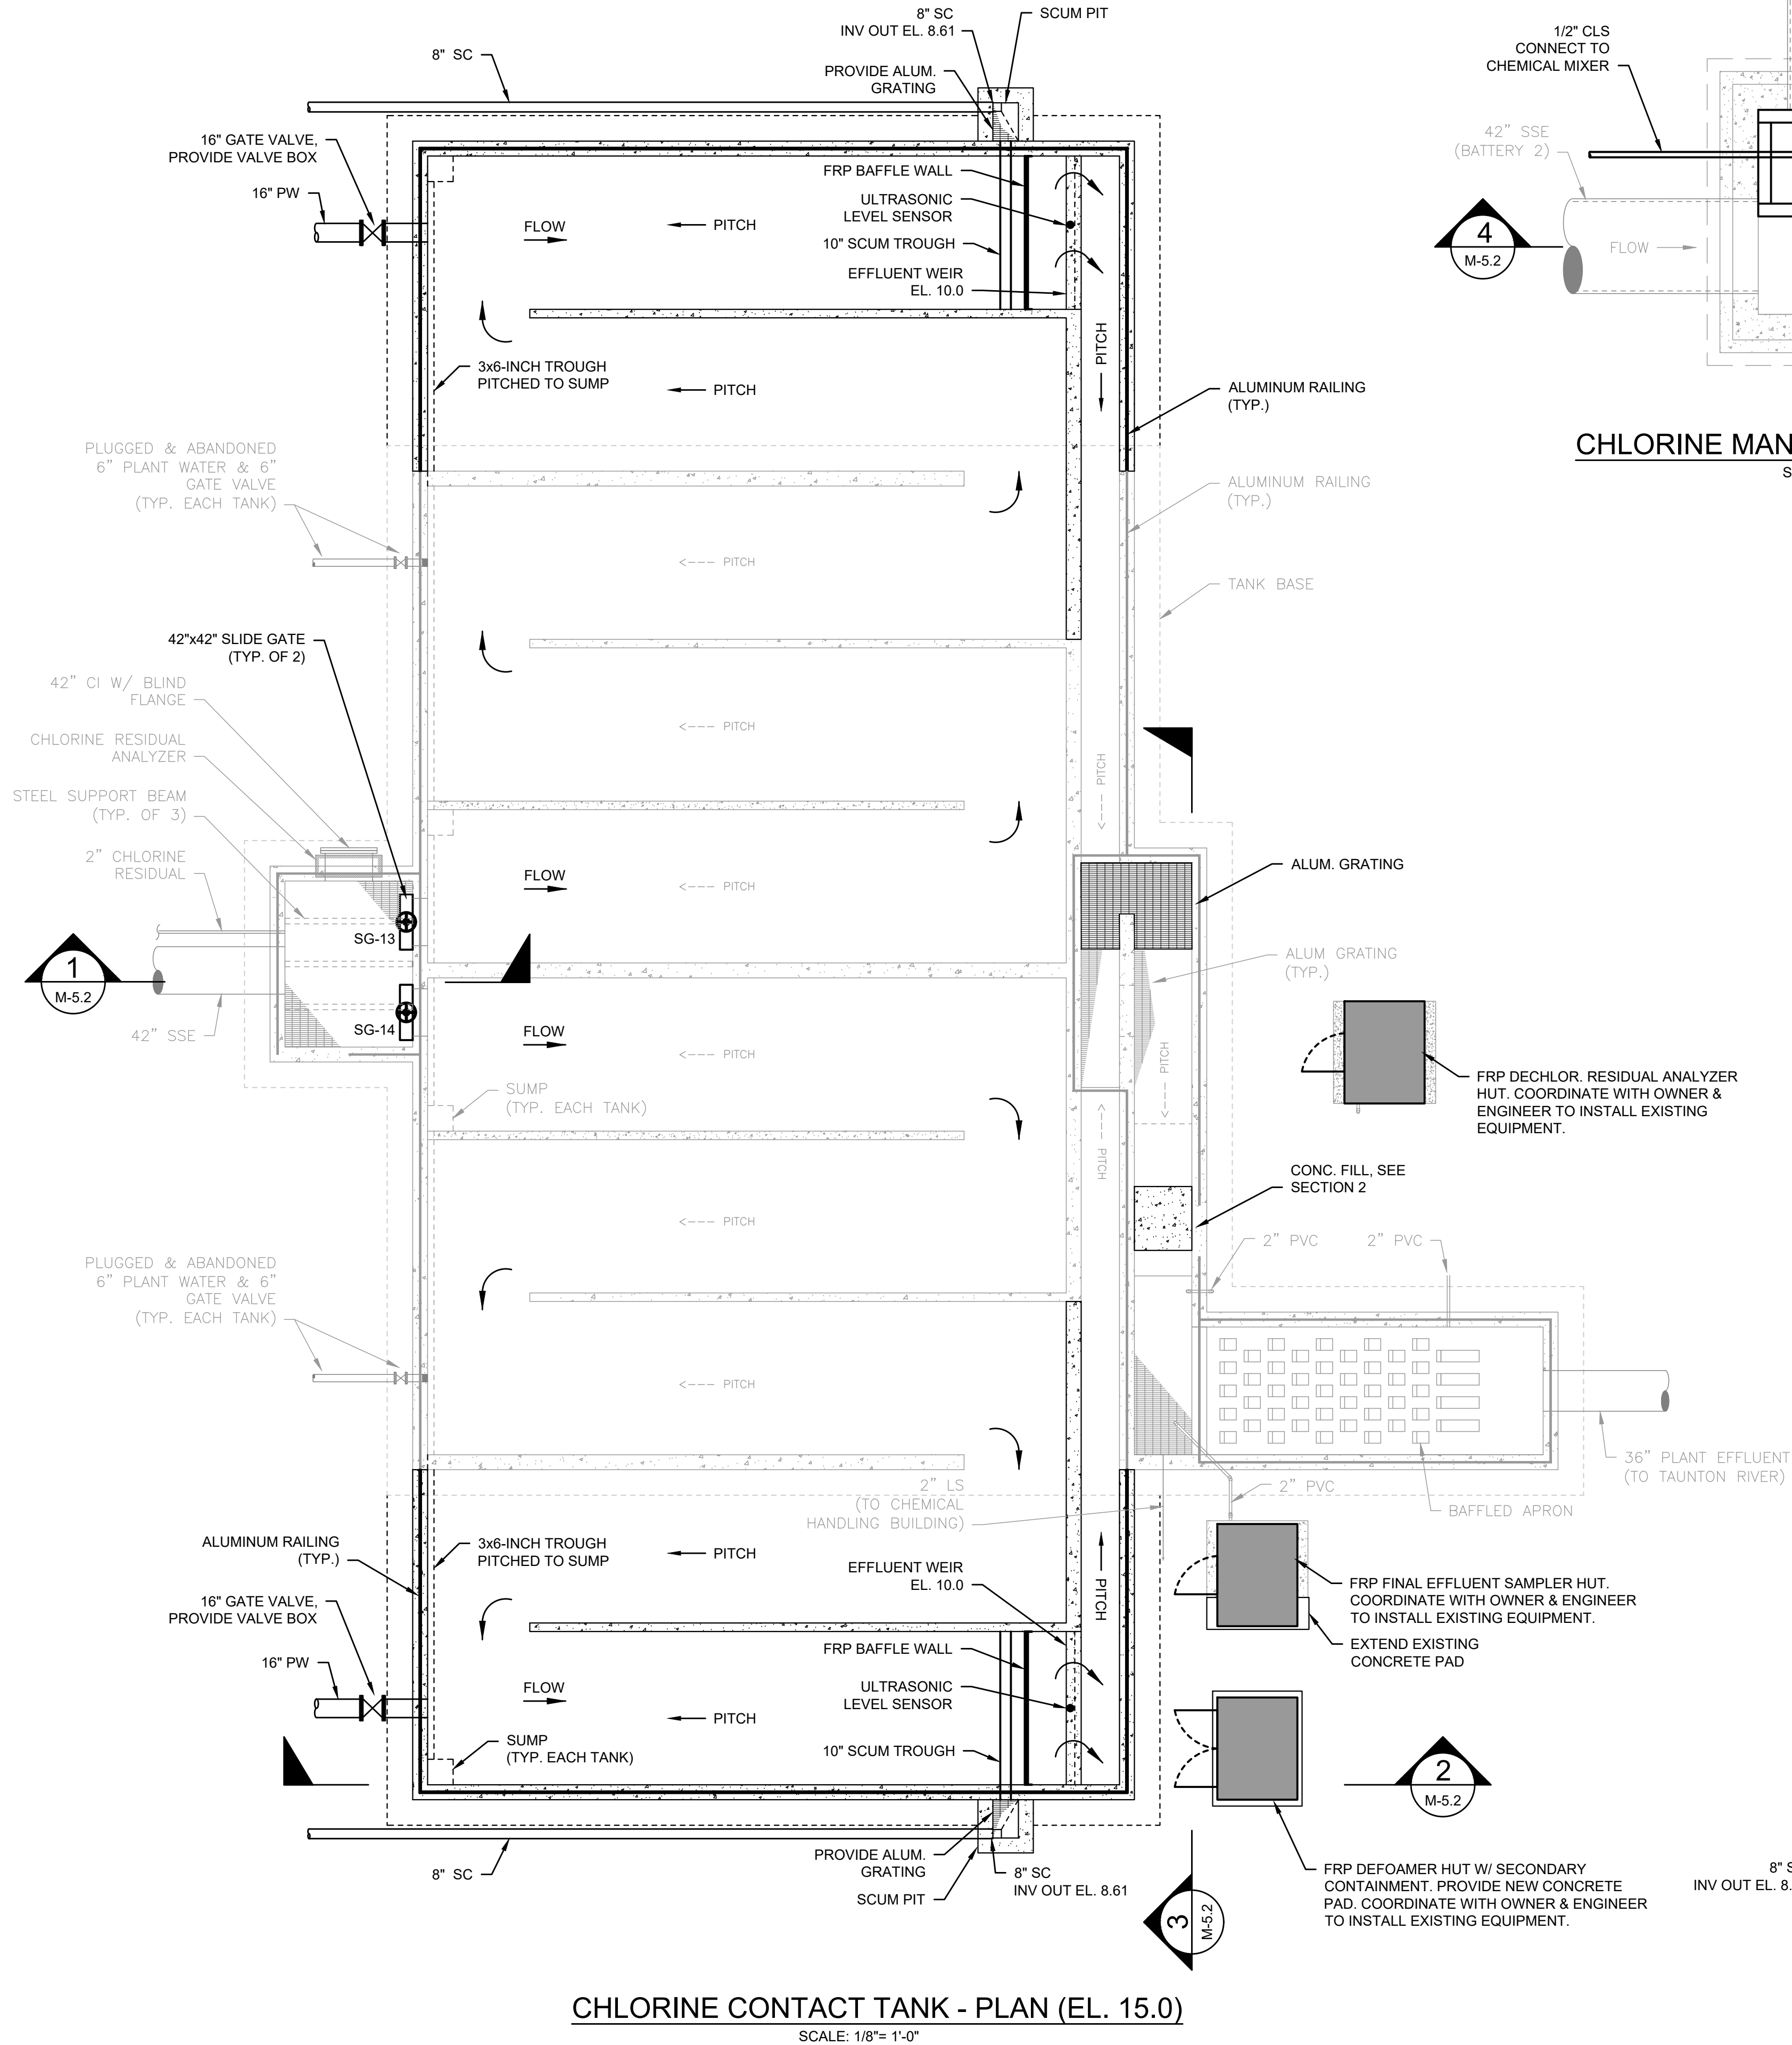

PREPARED BY



REGISTERED PROFESSIONAL



Joseph F. Beto, Jr.

SUBCONSULTANT

PROJECT

Taunton Wastewater
Treatment Facility
Improvements
Phase 1

Taunton, MA

TITLE

Chlorine Contact Tank &
Manhole Plan & Sections

NO.	REVISIONS	DATE

DRAWN BY:	BM
DESIGNED BY:	BM
CHECKED BY:	SR
ISSUE DATE:	7/2/2021
BETA JOB NO.:	6050

SCALE

AS SHOWN

UNLESS OTHERWISE NOTED OR CHANGED BY REPRODUCTION

SHEET NO.

M-5.2

NO.	REVISIONS	DATE
DRAWN BY:	BM	
DESIGNED BY:	BM	
CHECKED BY:	SR	
ISSUE DATE:	7/2/2021	
BETA JOB NO.:	6050	

AS SHOWN

UNLESS OTHERWISE NOTED OR CHANGED BY REPRODUCTION

M-5.3




[illegible]

NO.	REVISIONS	DATE
DRAWN BY:	BM	
DESIGNED BY:	MA	
CHECKED BY:	SR	
ISSUE DATE:	7/2/2021	
BETA JOB NO.:	6050	




7/2/2021 10:35 AM J:\TAUNTON\WTF DESIGN\AUTOCAD\PLAN SET\PHASE 1\CHEMICAL HANDLING BUILDING - EXIST, PLANS & SECTIONS.DWG (BETA STD BW.CTB)

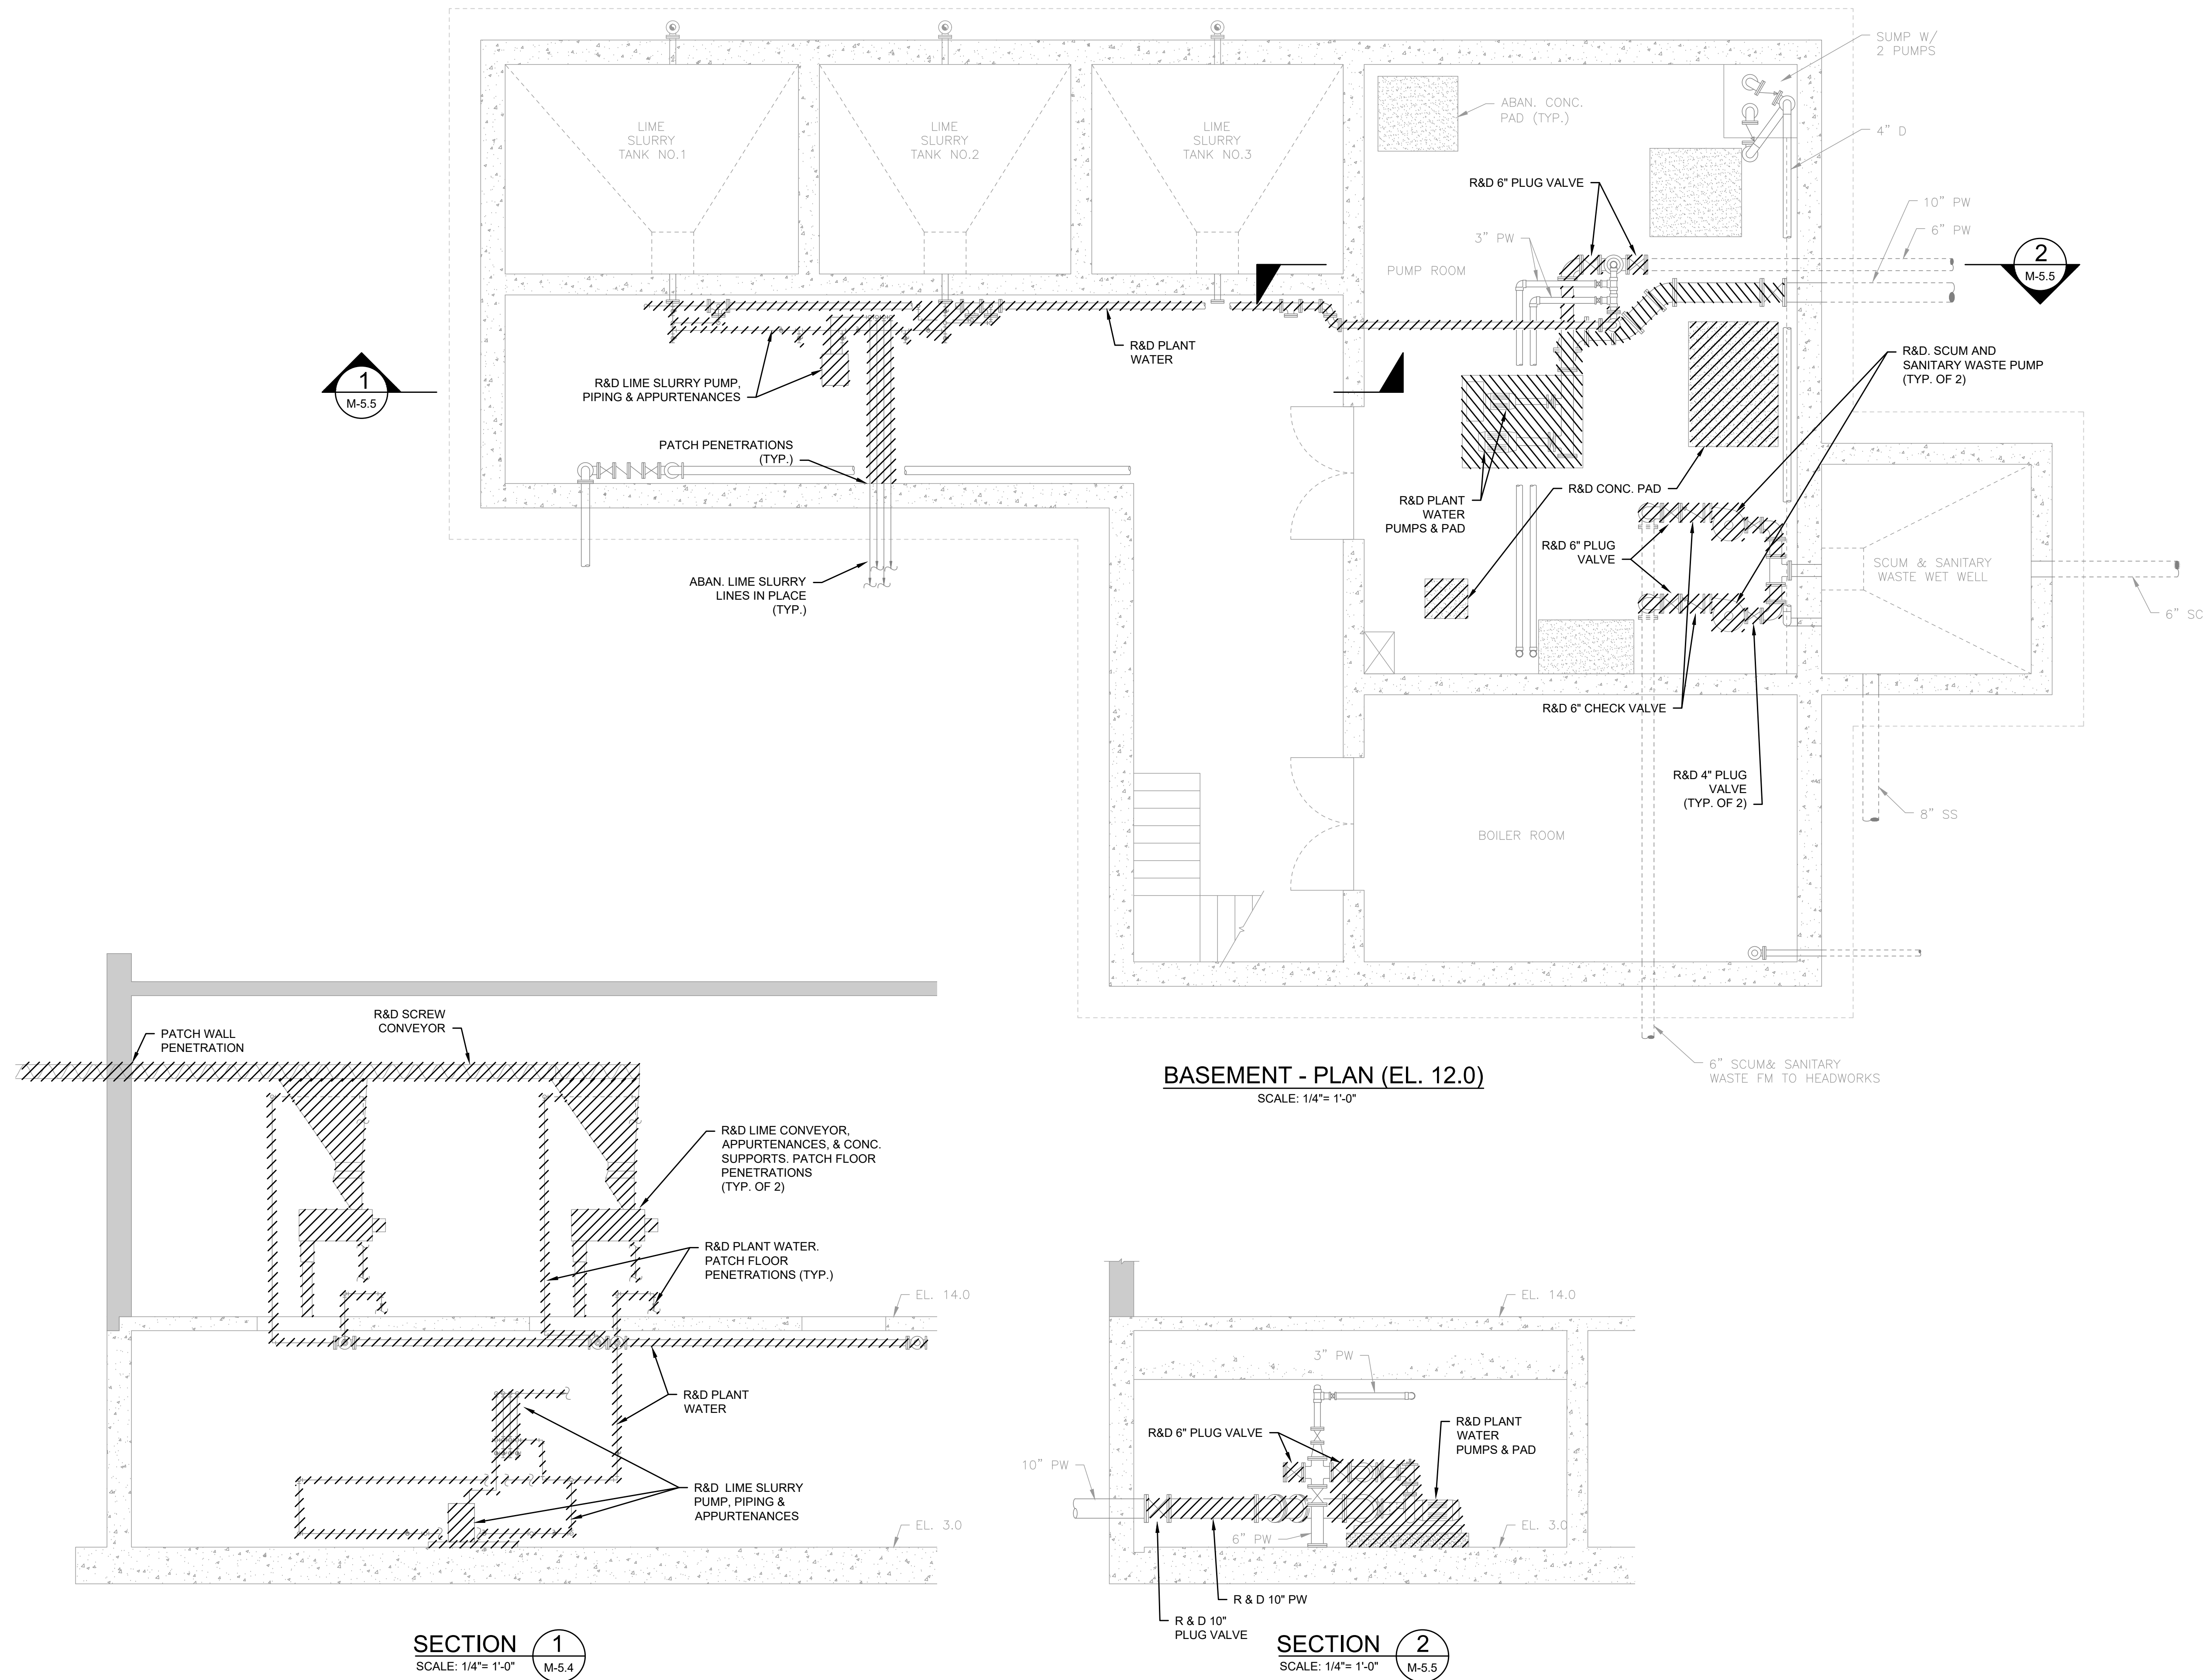

PREPARED BY



REGISTERED PROFESSIONAL

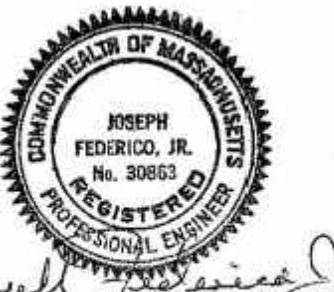

SUBCONSULTANT

PROJECT

**Taunton Wastewater
Treatment Facility
Improvements
Phase 1**

Taunton, MA

TITLE

**Chemical Handling
Building Demolition
Plan & Sections**

NO.	REVISIONS	DATE


DRAWN BY:	BM
DESIGNED BY:	MA
CHECKED BY:	SR
ISSUE DATE:	7/2/2021
BETA JOB NO.:	6050

SCALE
AS SHOWN
UNLESS OTHERWISE NOTED OR CHANGED BY REPRODUCTION

SHEET NO.

M-5.5

7/2/2021 10:35 AM J:\TAUNTON\WWT DESIGN\AUTOCAD\PLAN SET\PHASE 1\CHEMICAL HANDLING BUILDING - PROP. PLANS & SECTIONS.DWG (BETA STD BW.CTB)

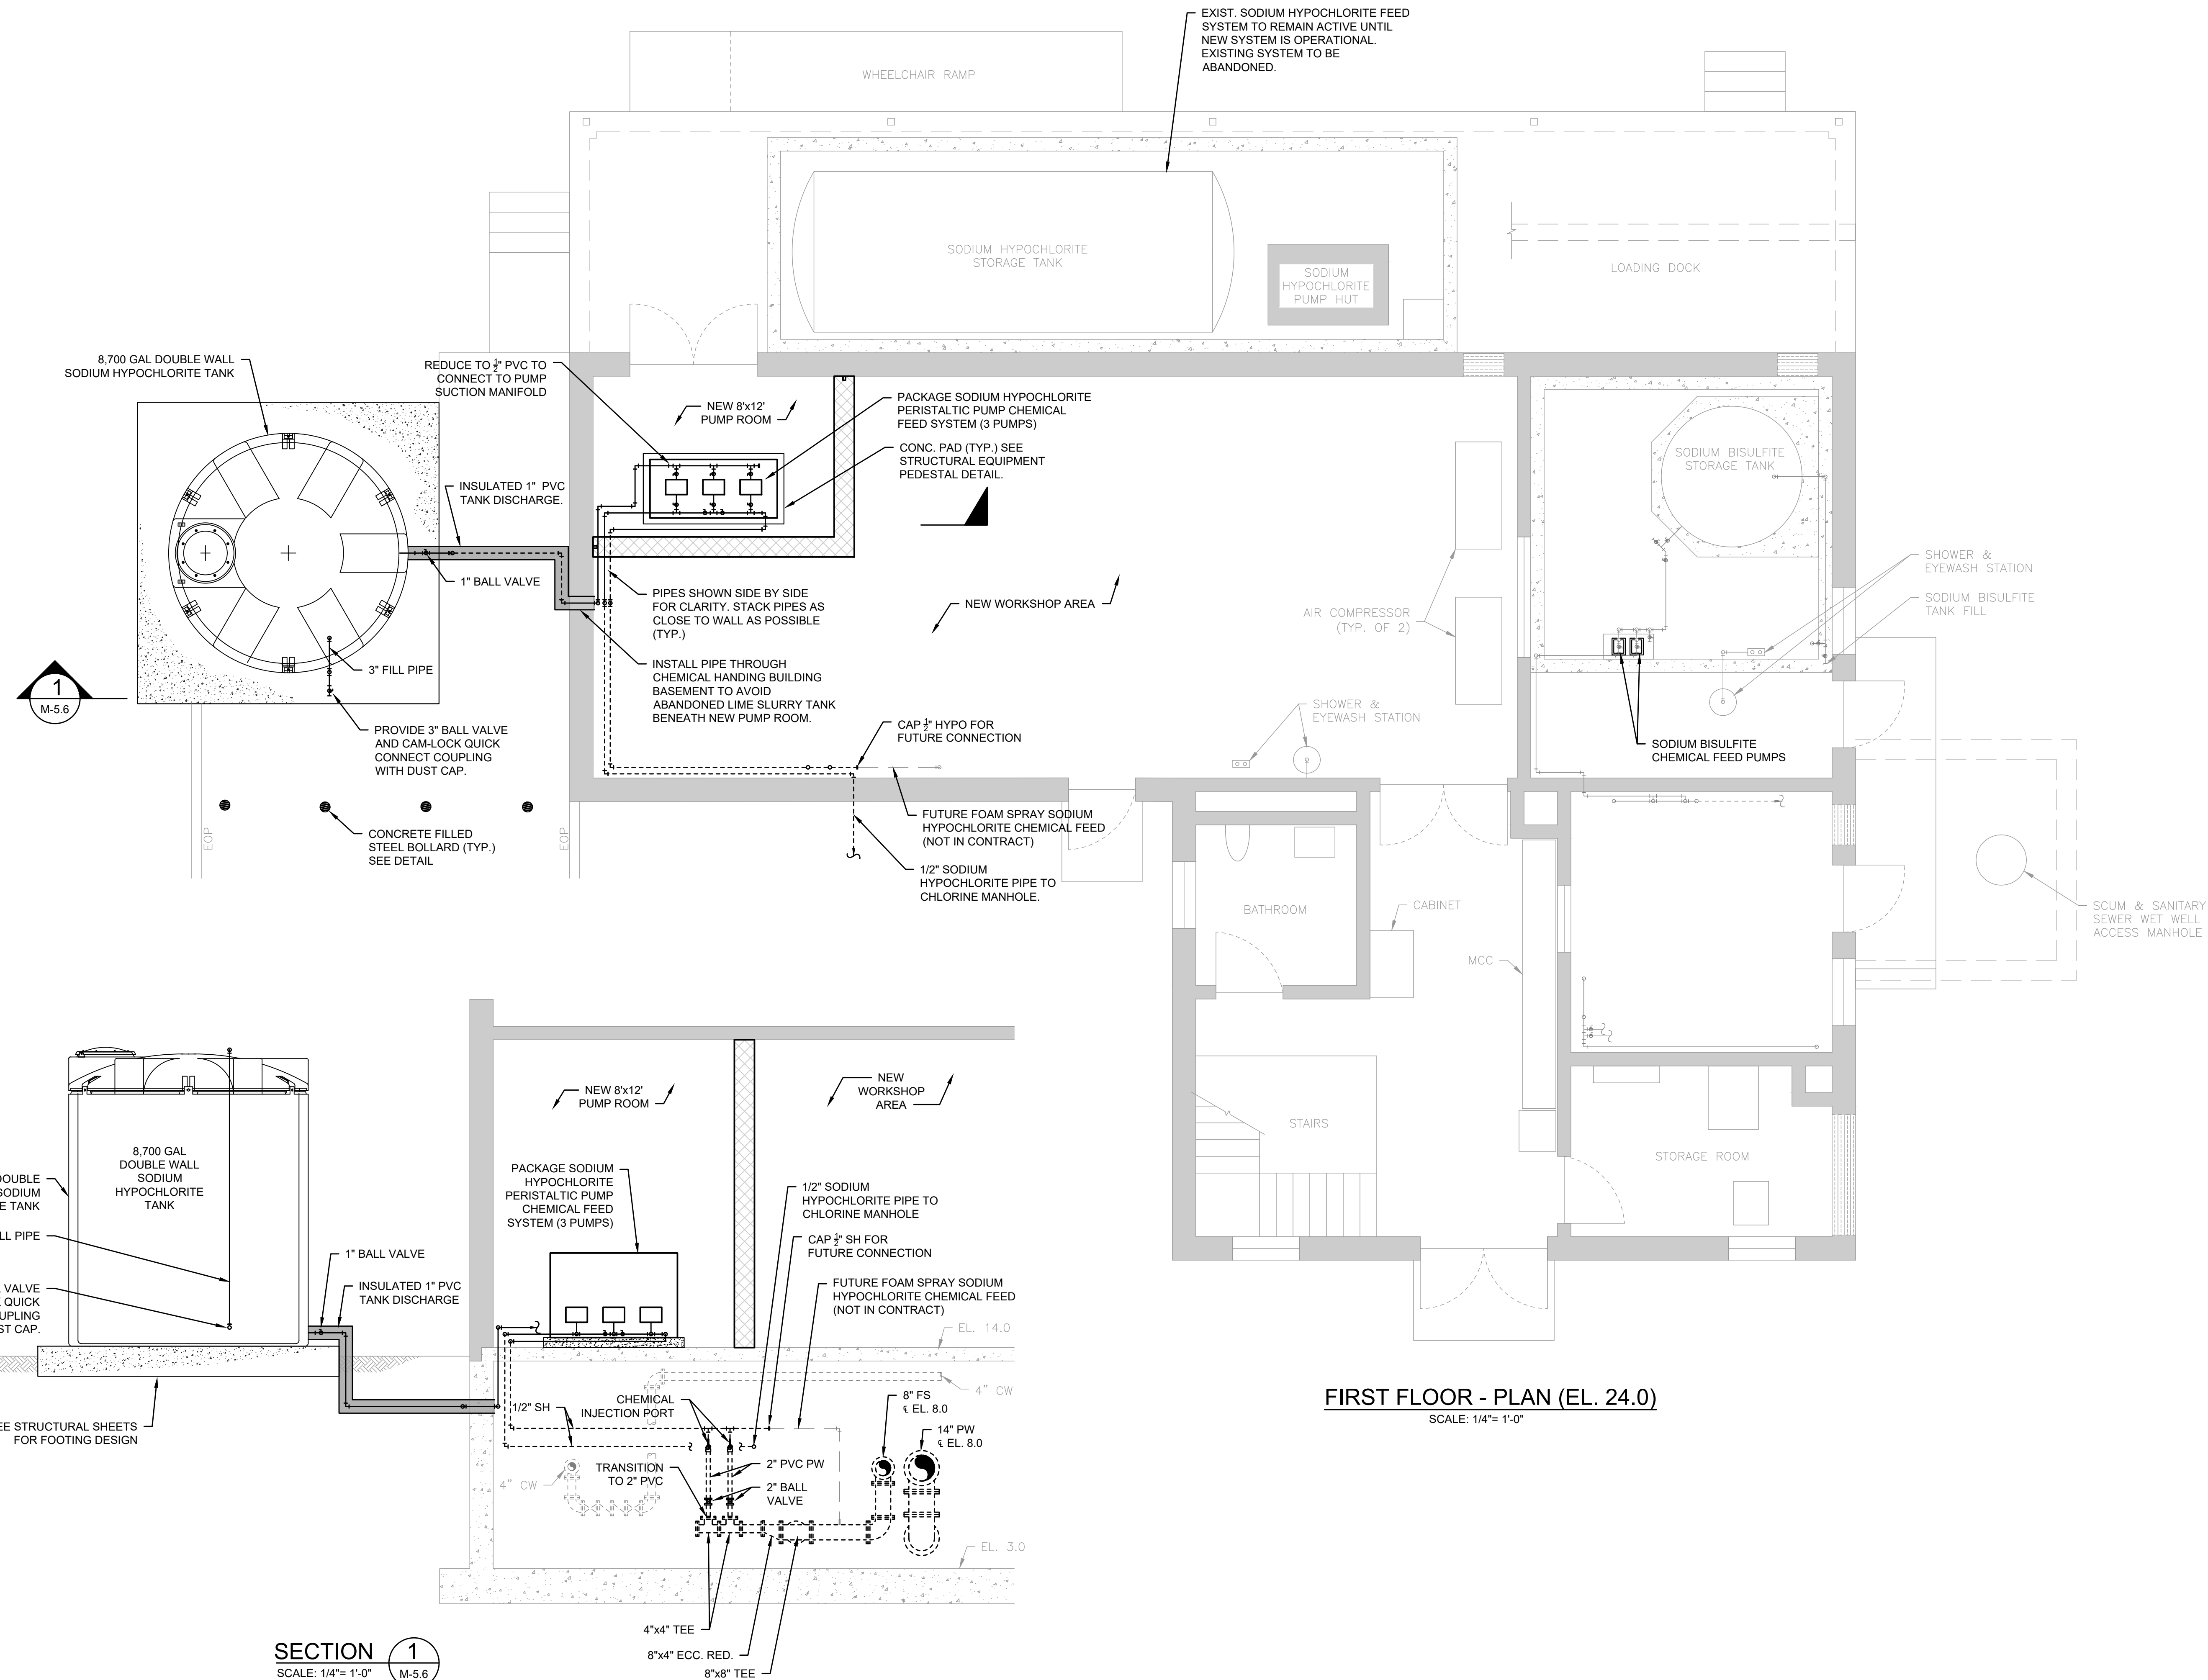

SECTION 1
SCALE: 1/4"= 1'-0" M-5.6

PREPARED BY



REGISTERED PROFESSIONAL



Joseph Federico, Jr.

SUBCONSULTANT

PROJECT

**Taunton Wastewater
Treatment Facility
Improvements
Phase 1**

Taunton, MA

TITLE

**Chemical Handling
Building Plan**

NO.	REVISIONS	DATE
-----	-----------	------

DRAWN BY:	BM
-----------	----

DESIGNED BY:	MA
--------------	----

CHECKED BY:	SR
-------------	----

ISSUE DATE:	7/2/2021
-------------	----------

BETA JOB NO.:	6050
---------------	------



SCALE


AS SHOWN

UNLESS OTHERWISE NOTED OR CHANGED BY REPRODUCTION

SHEET NO.

M-5.6

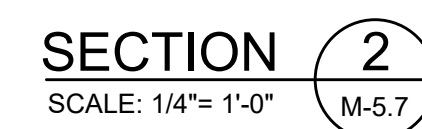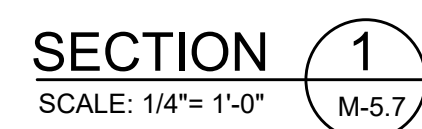

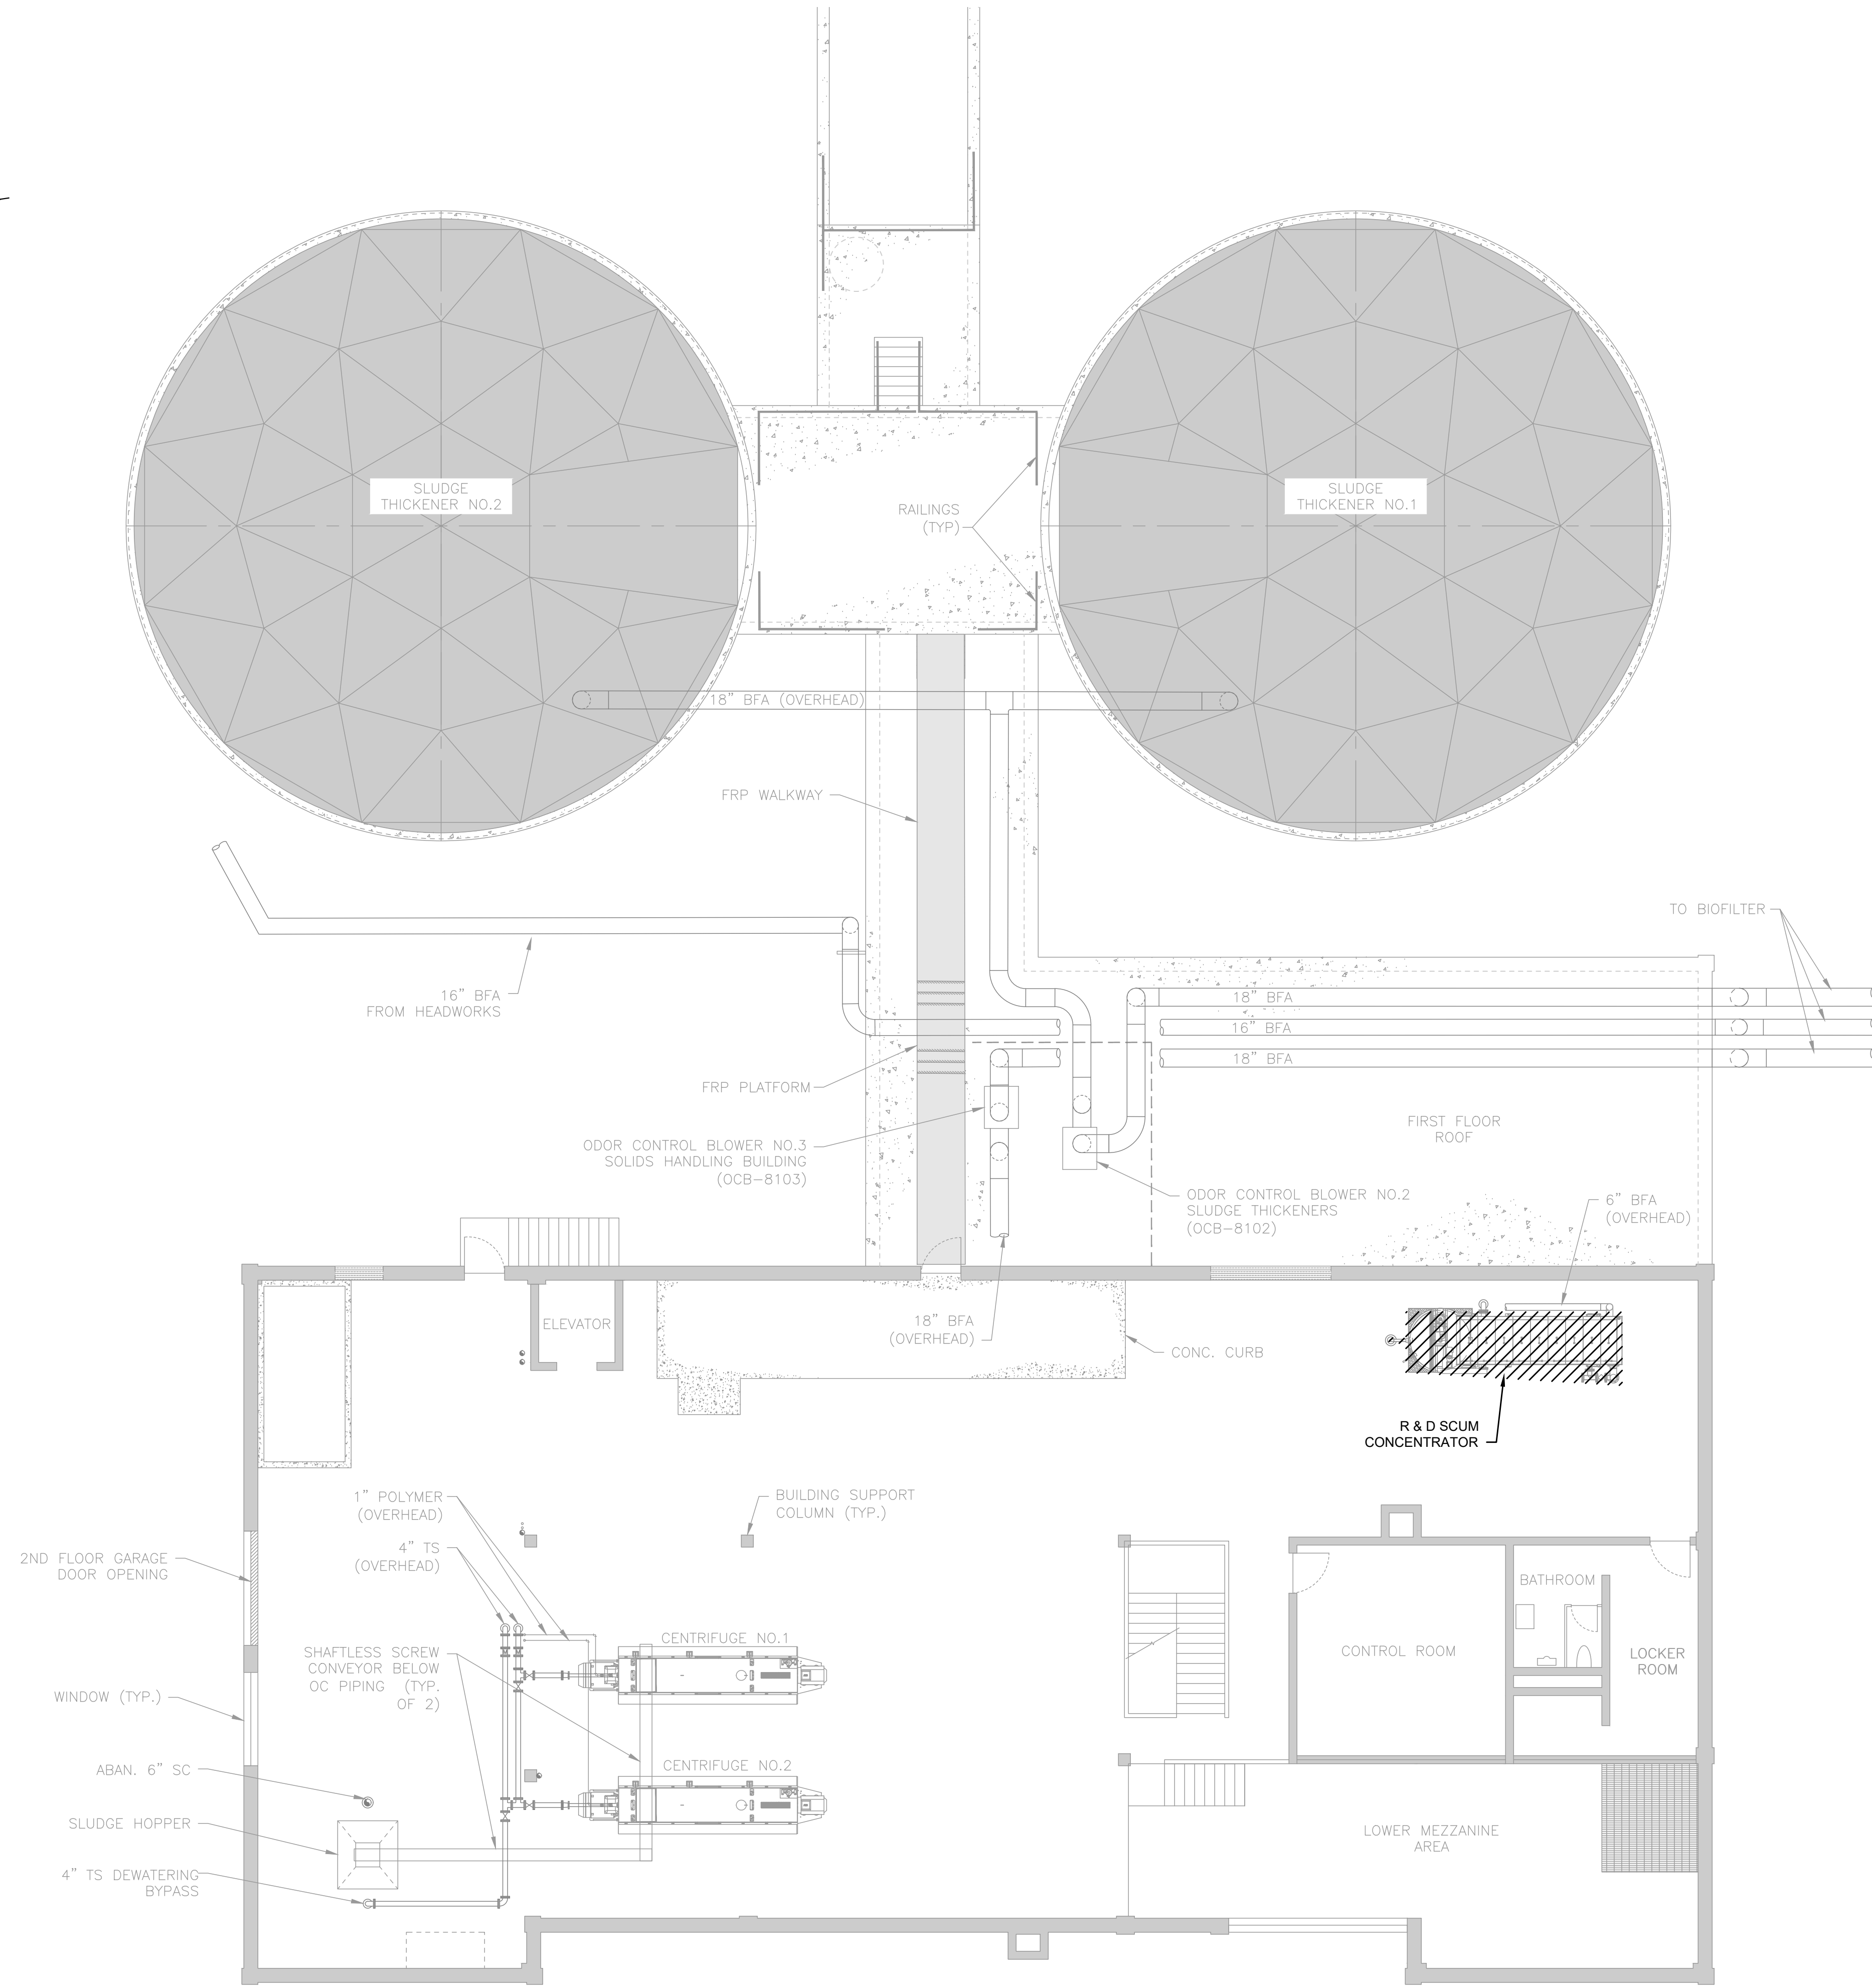


SECOND FLOOR - PLAN (EL. 65.0)
SCALE: 1/8"= 1'-0"

PREPARED BY



REGISTERED PROFESSIONAL

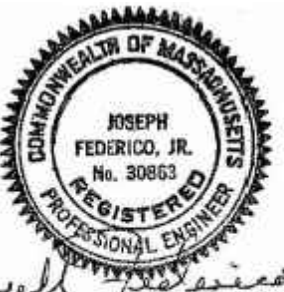

SUBCONSULTANT

PROJECT

**Taunton Wastewater
Treatment Facility
Improvements
Phase 1**

Taunton, MA

TITLE

**Solids Handling Building
Demolition Plan**

NO.	REVISIONS	DATE

SCALE


AS SHOWN

UNLESS OTHERWISE NOTED OR CHANGED BY REPRODUCTION


SHEET NO.

M-7.1


7/2/2021 10:36 AM J:\TAUNTON\WMTF DESIGN\AUTOCAD\PLAN SET\PHASE 1\SOLIDS HANDLING BUILDING - PROP. PLANS & SECTIONS.DWG (BETA STD BW.CTB)

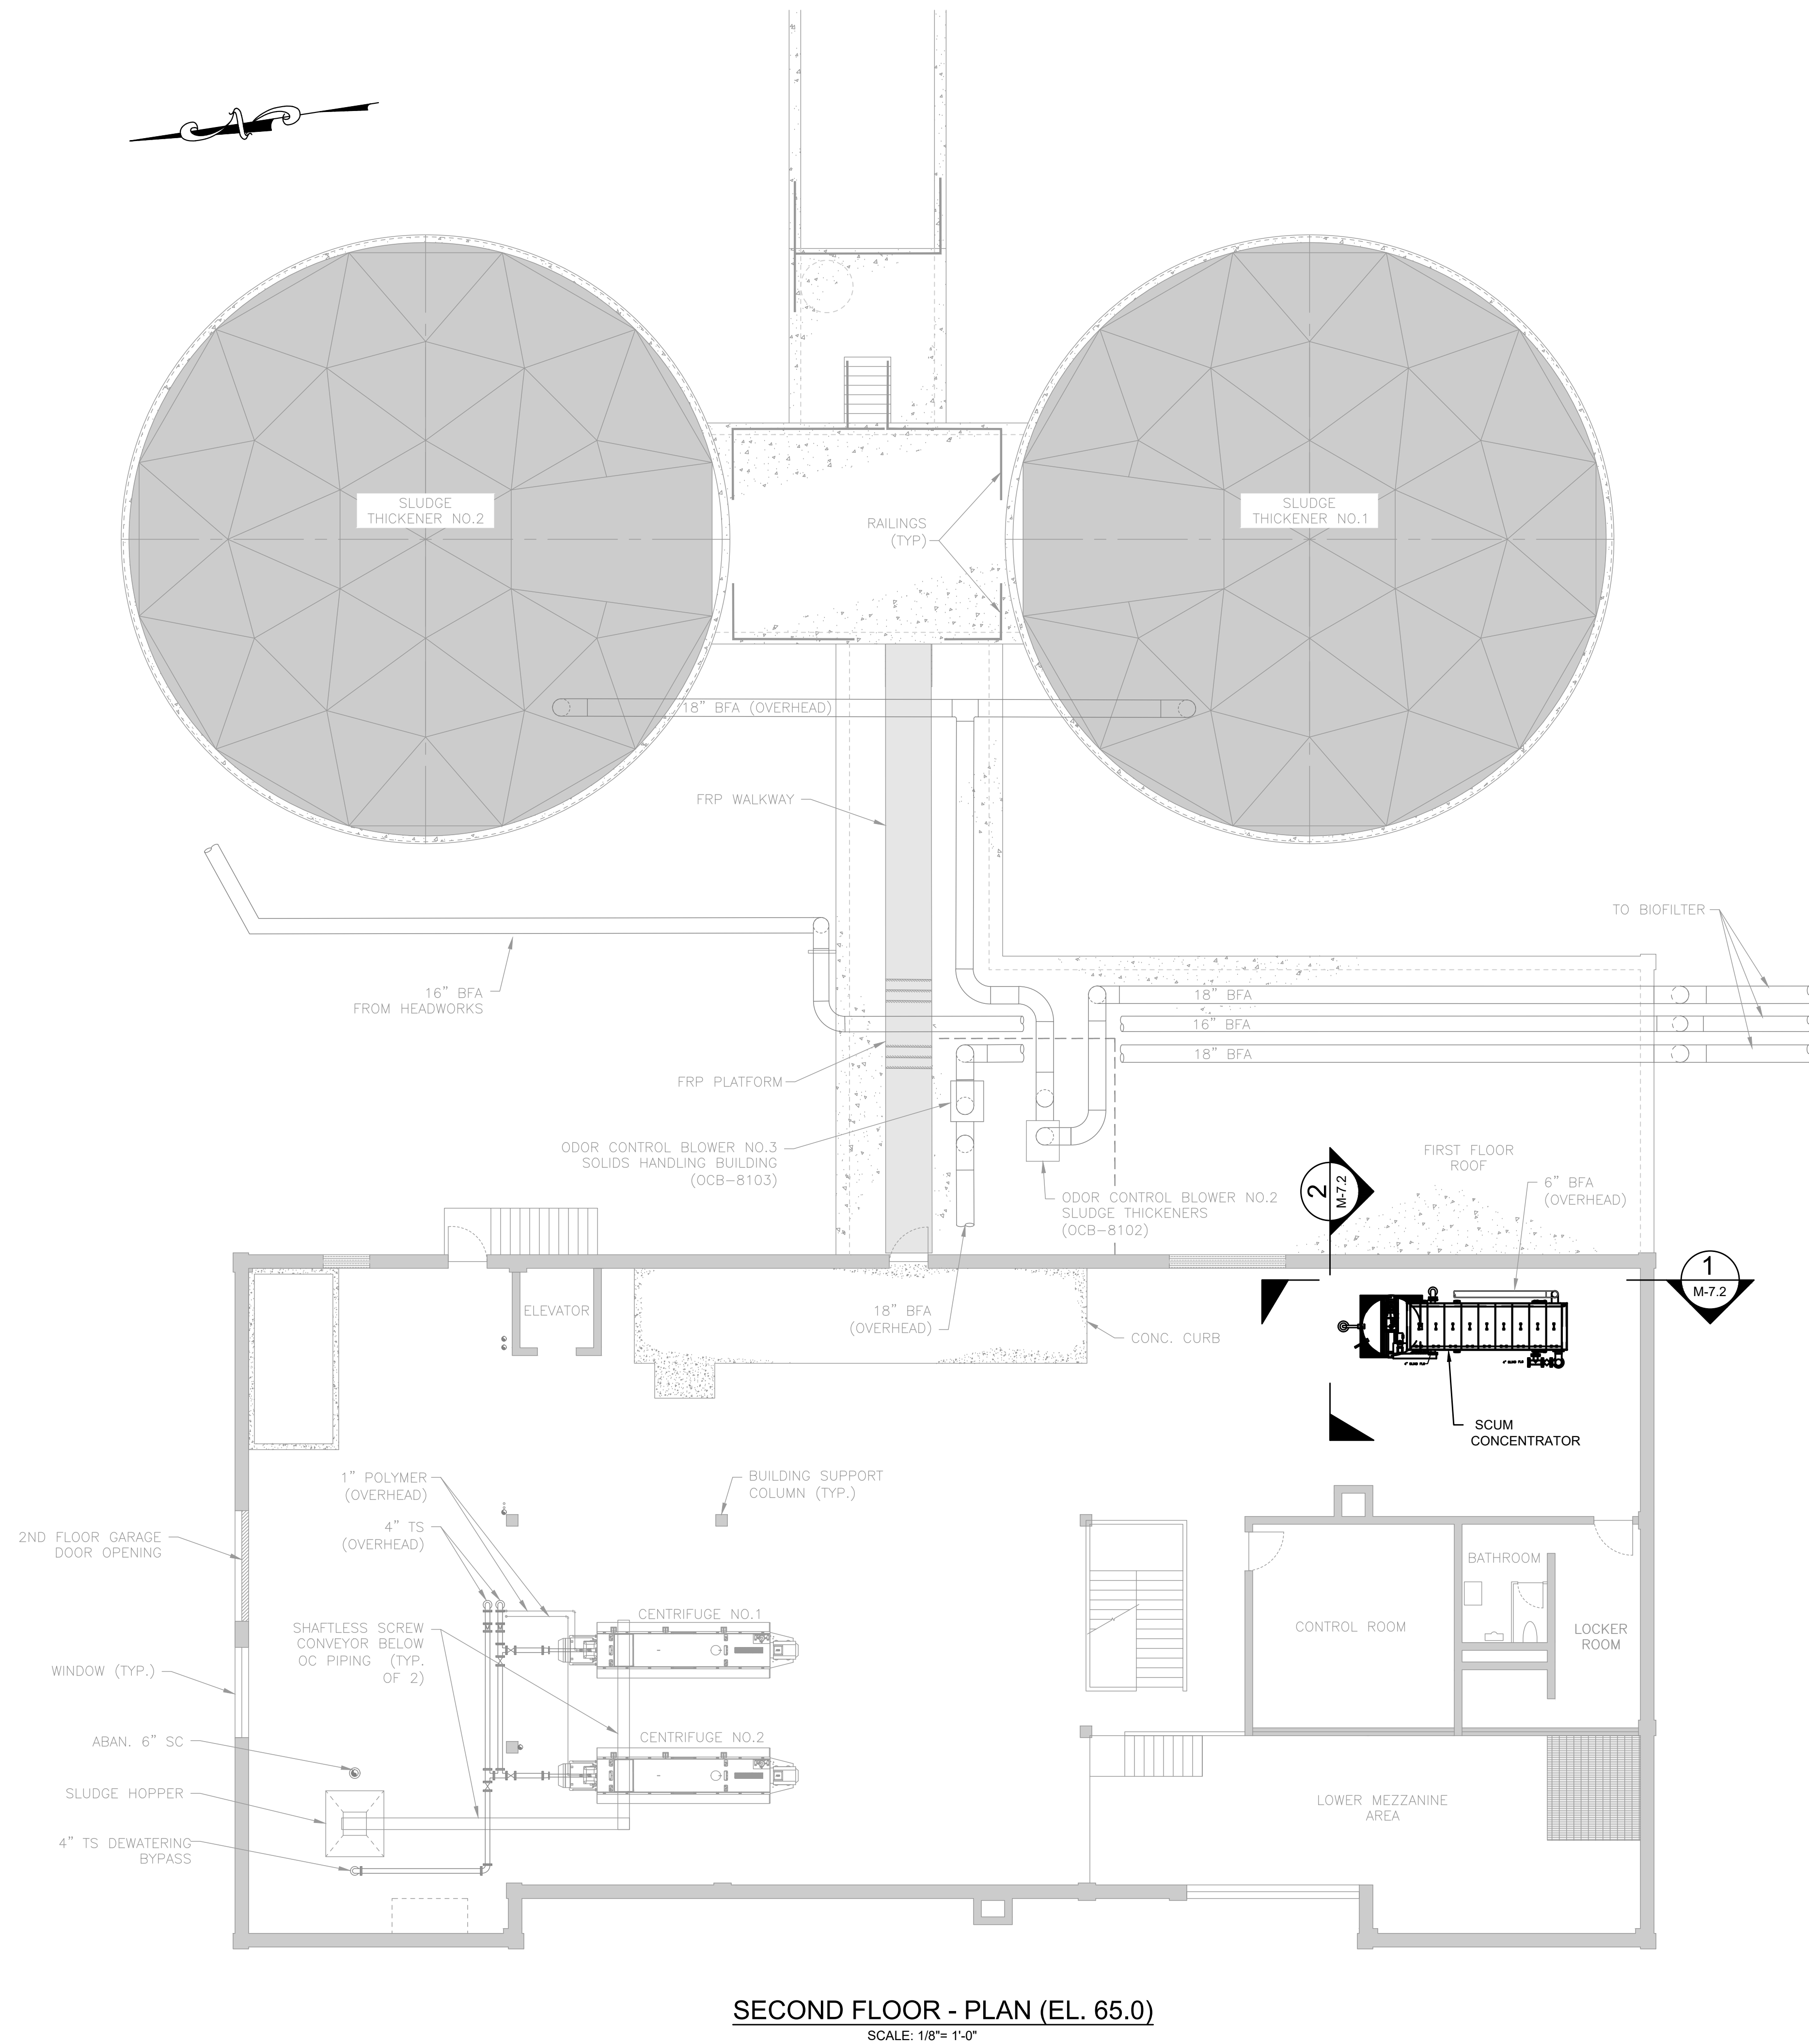

SECOND FLOOR - PLAN (EL. 65.0)
SCALE: 1/8"= 1'-0"

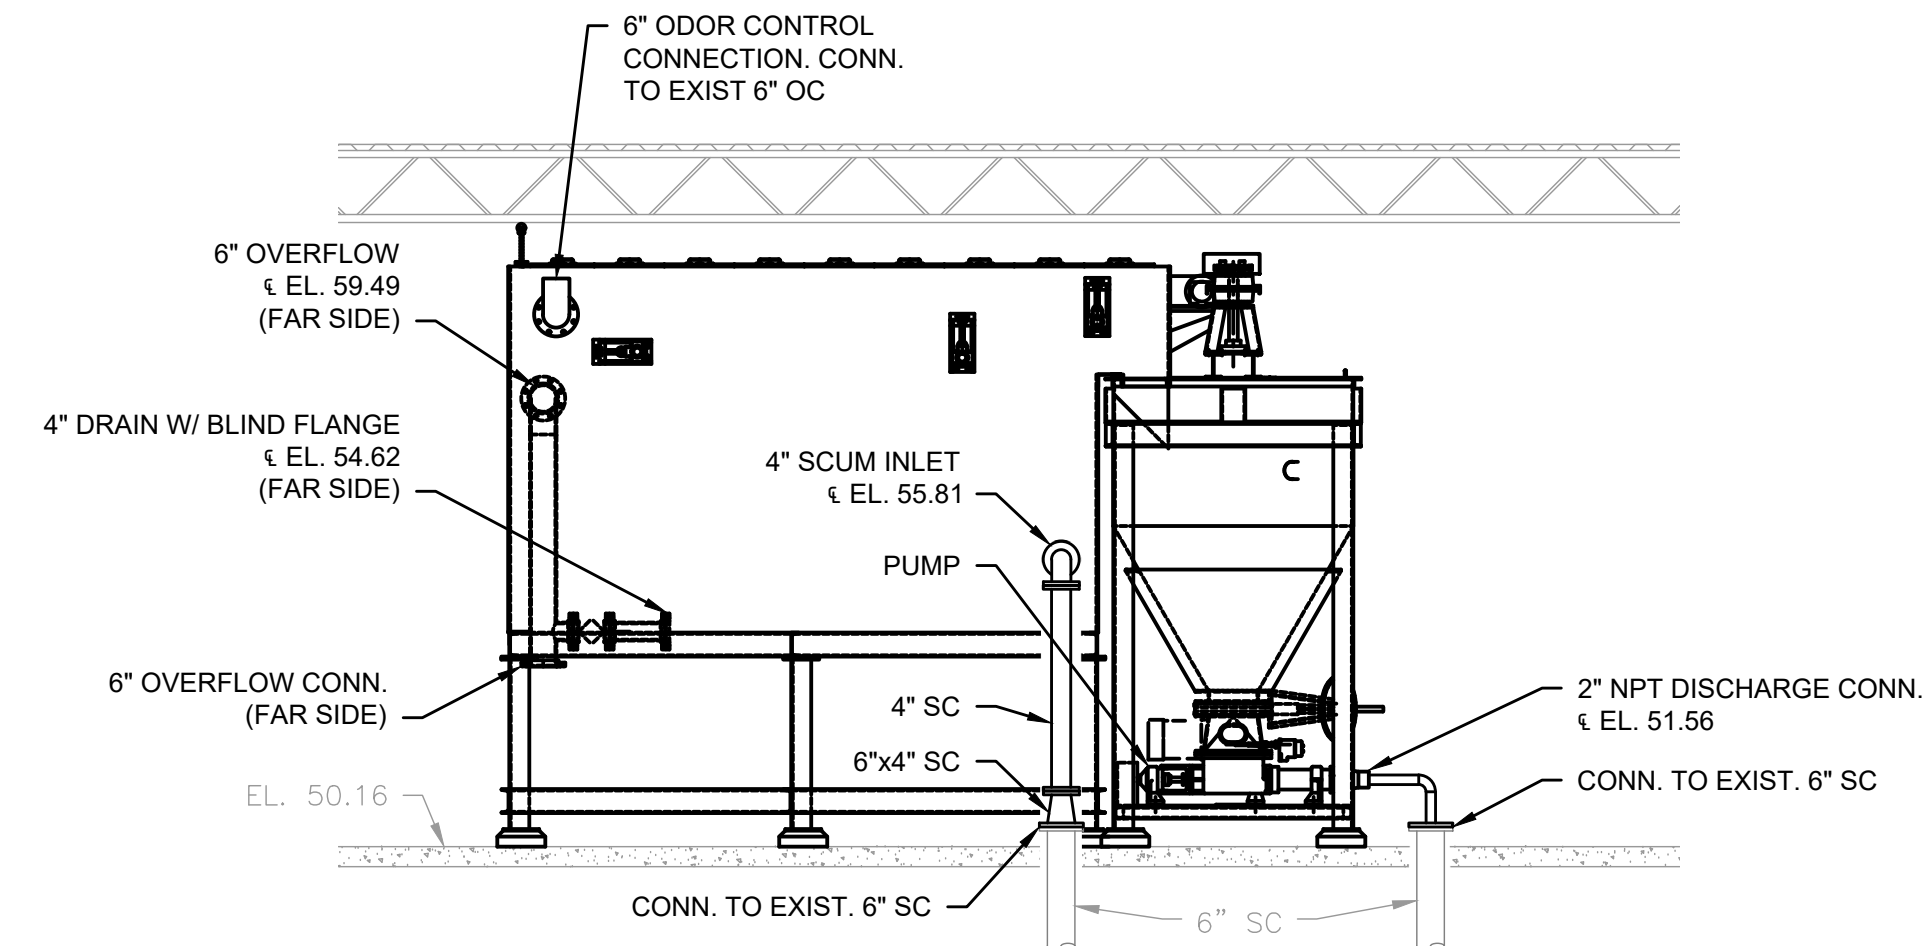

SECTION 1
SCALE: 1/4"= 1'-0"
M-7.2

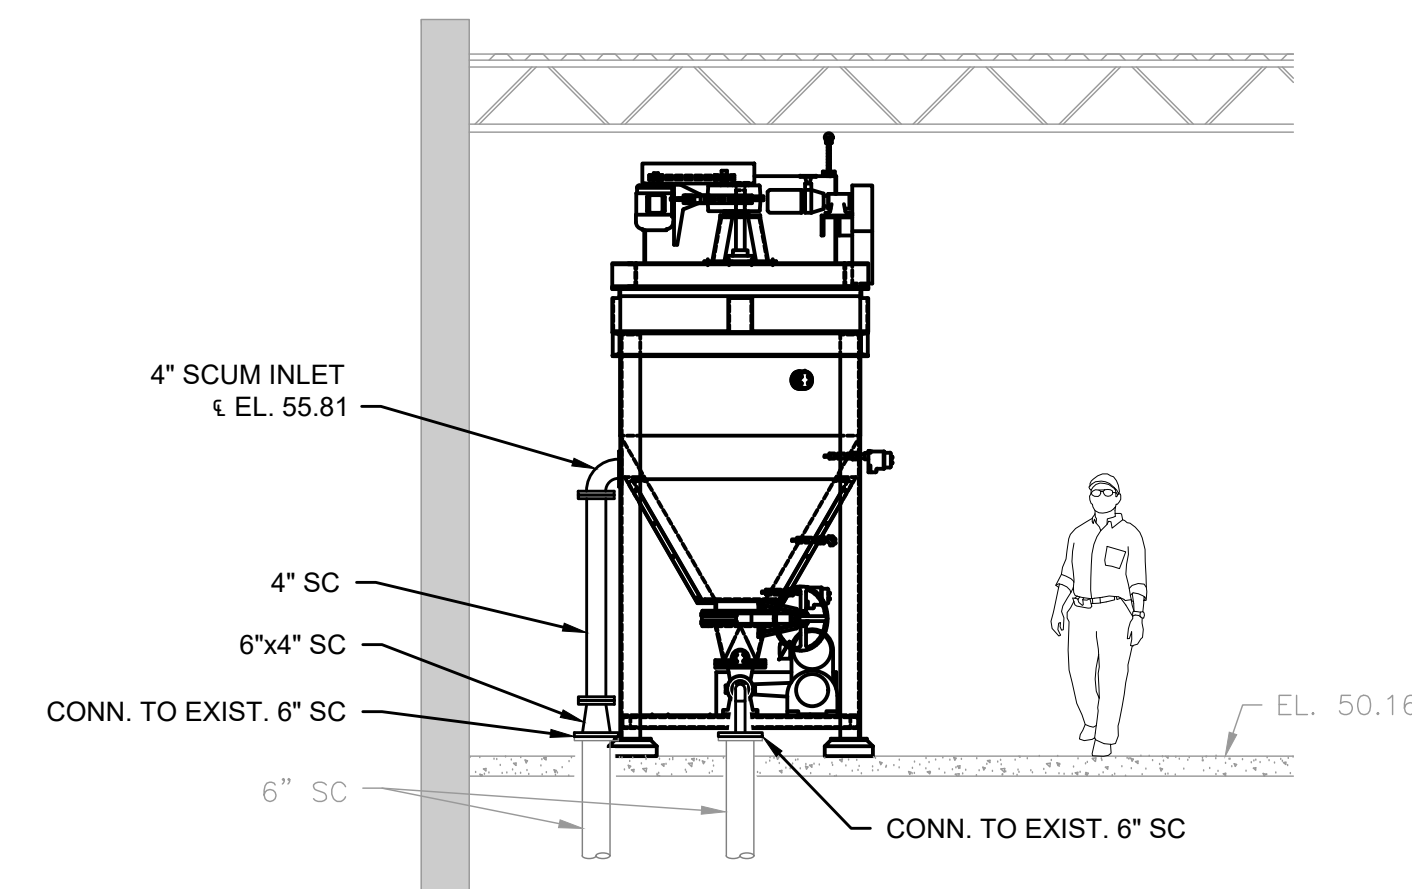

SECTION 2
SCALE: 1/4"= 1'-0"
M-7.2

PREPARED BY



REGISTERED PROFESSIONAL



SUBCONSULTANT

PROJECT

**Taunton Wastewater
Treatment Facility
Improvements
Phase 1**

Taunton, MA

TITLE

**Solids Handling Building
Plans & Sections**

NO.	REVISIONS	DATE
-----	-----------	------

DRAWN BY:	BM
-----------	----

DESIGNED BY:	BM
--------------	----

CHECKED BY:	SR
-------------	----

ISSUE DATE:	7/2/2021
-------------	----------

BETA JOB NO.:	6050
---------------	------


SCALE

AS SHOWN

UNLESS OTHERWISE NOTED OR CHANGED BY REPRODUCTION


SHEET NO.

M-7.2

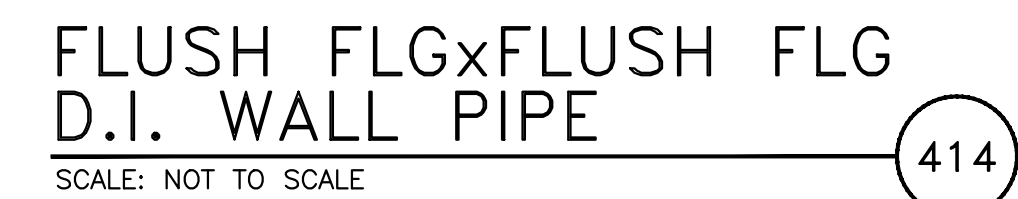


MD-1


7/2/2021 10:36 AM J:\TAUNTON\WTF DESIGN\AUTOCAD\PLAN SET\PHASE 1\MECHANICAL DETAILS.DWG (BETA STD BW.CTB)

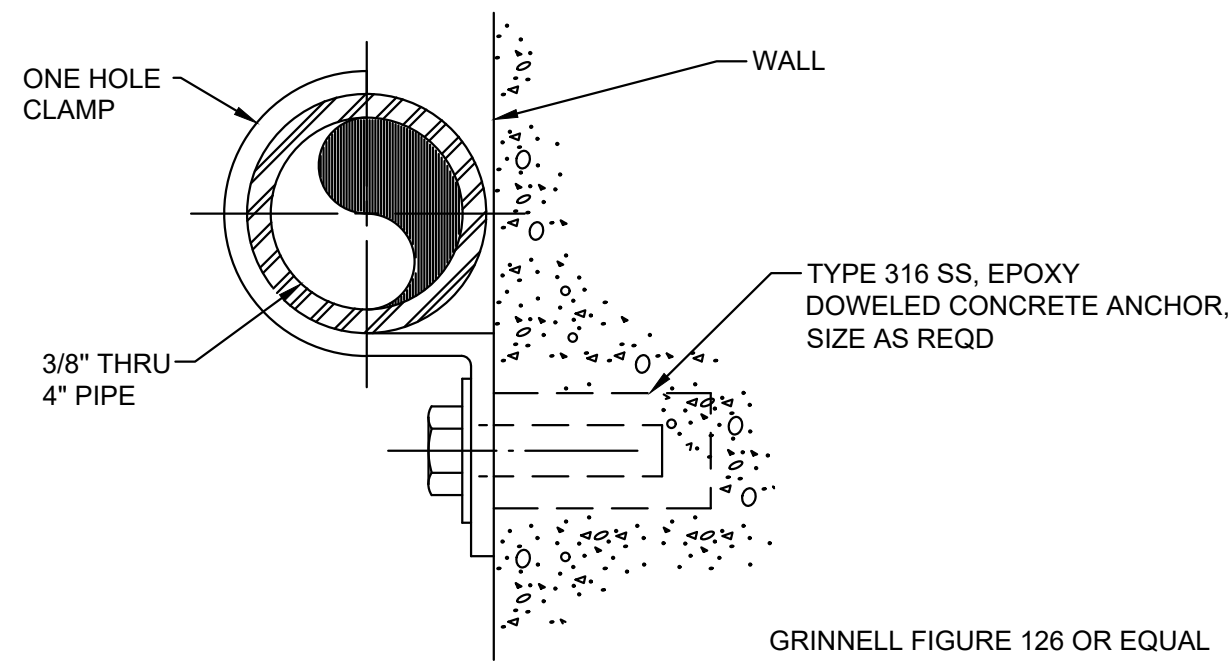


PIPE SUPPORT 416
SCALE: NOT TO SCALE

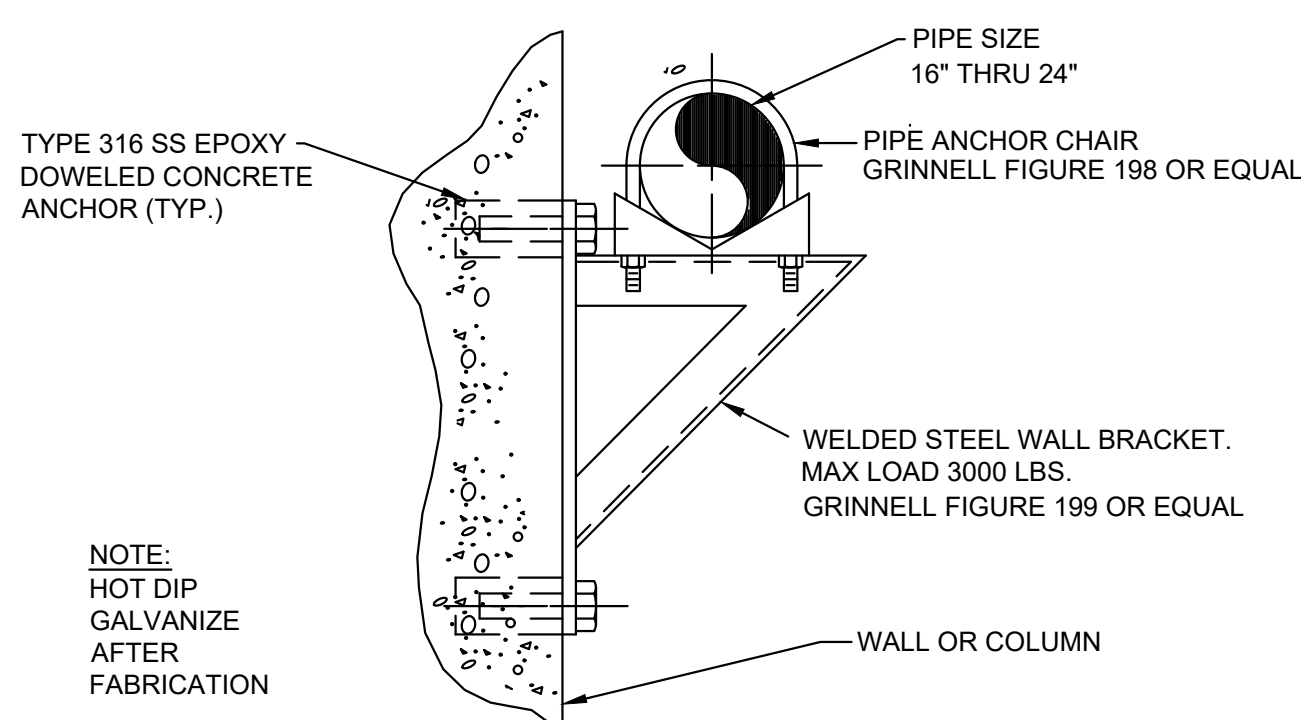

PIPE SUPPORT-HEAVY 420
SCALE: NOT TO SCALE

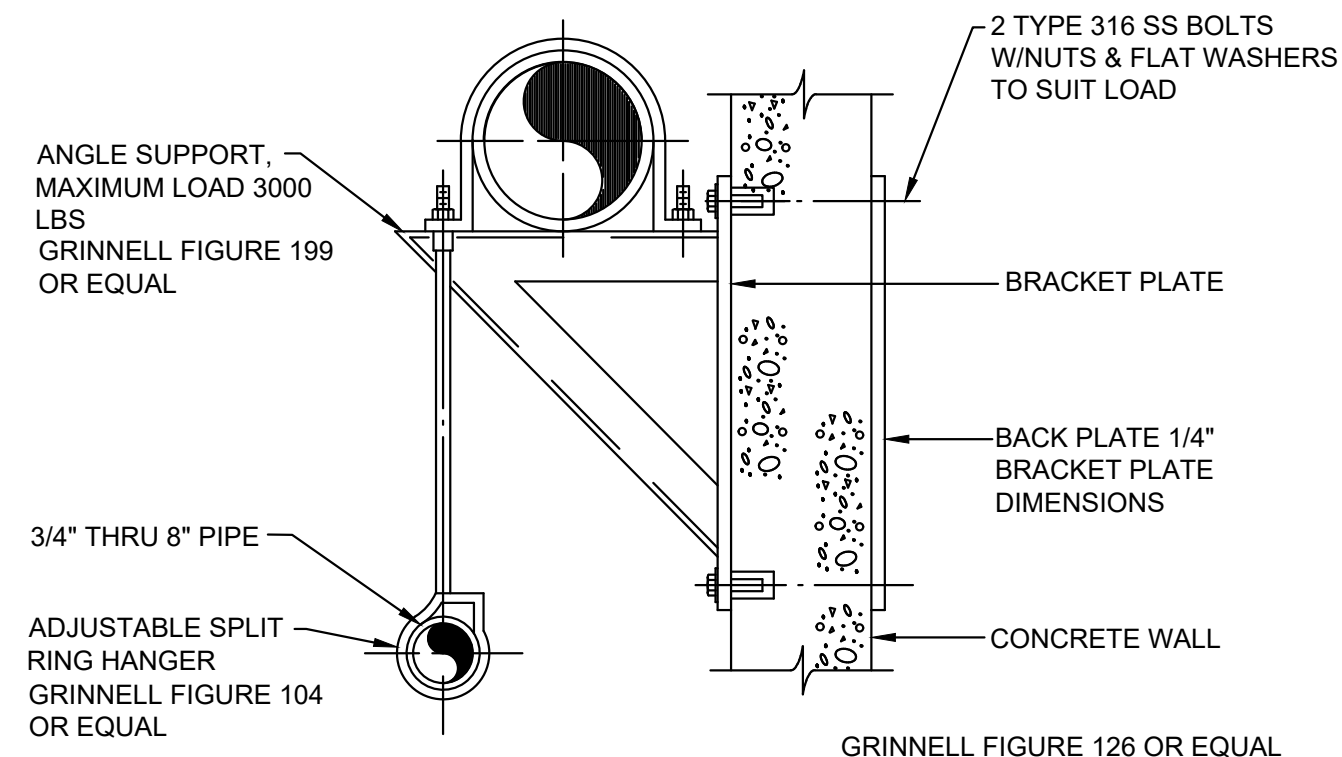


PIPE SUPPORT 417
SCALE: NOT TO SCALE

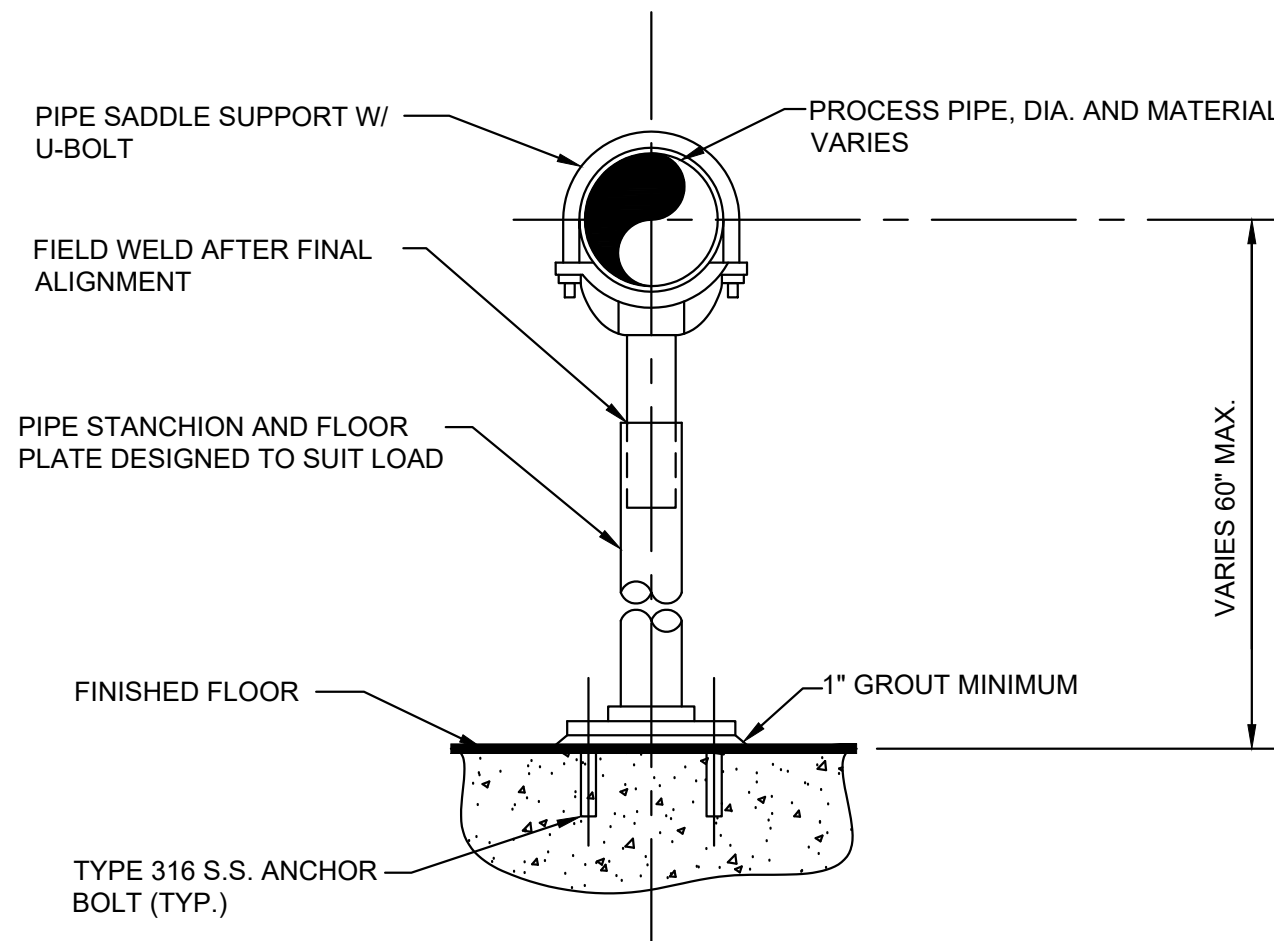


- NOTES:
1. PROVIDE HALF-ROUND RIGID INSULATION WAND INSULATION SHIELD FOR INSULATED PIPING.
 2. PROVIDE NEOPRENE ISOLATION PAD UNDER SUPPORT FOOT FOR ISOLATED PIPING OR WHEN SUPPORT IS ADJACENT TO MECHANICAL EQUIPMENT.


FLOOR PIPE SUPPORT 421
SCALE: NOT TO SCALE

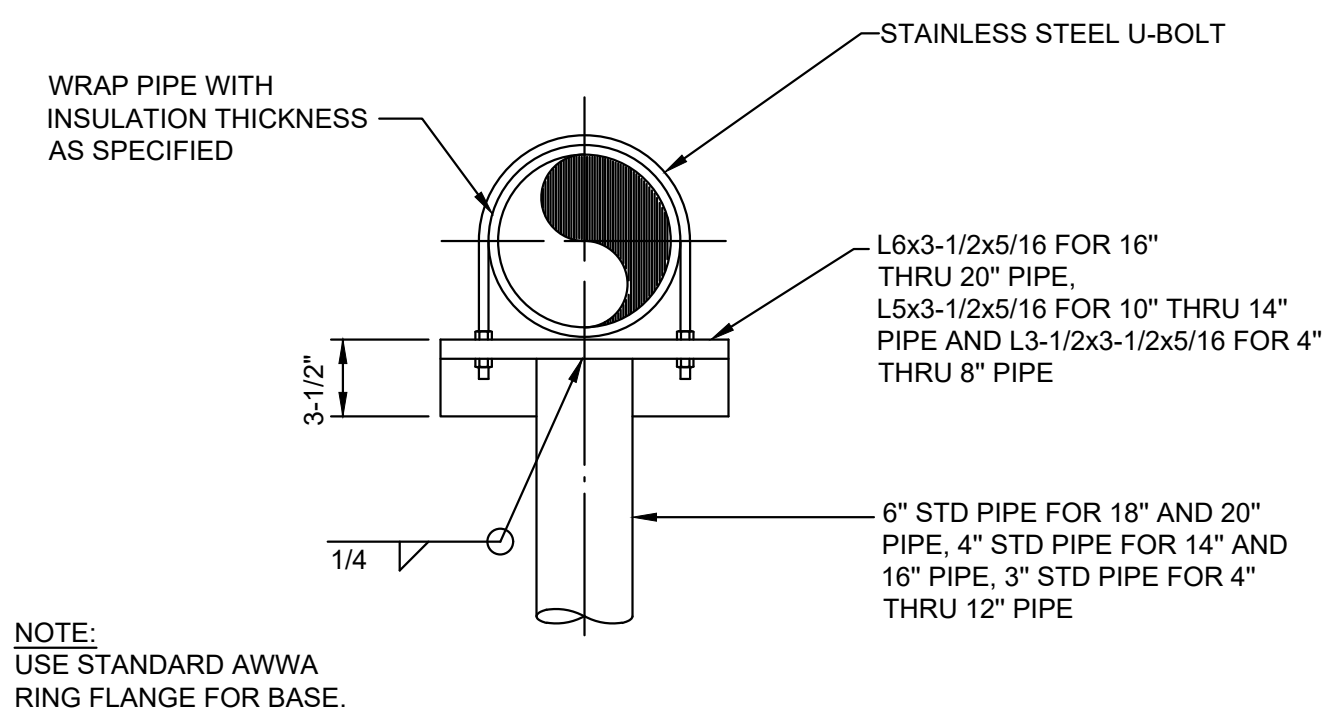


PIPE SUPPORT 418
SCALE: NOT TO SCALE

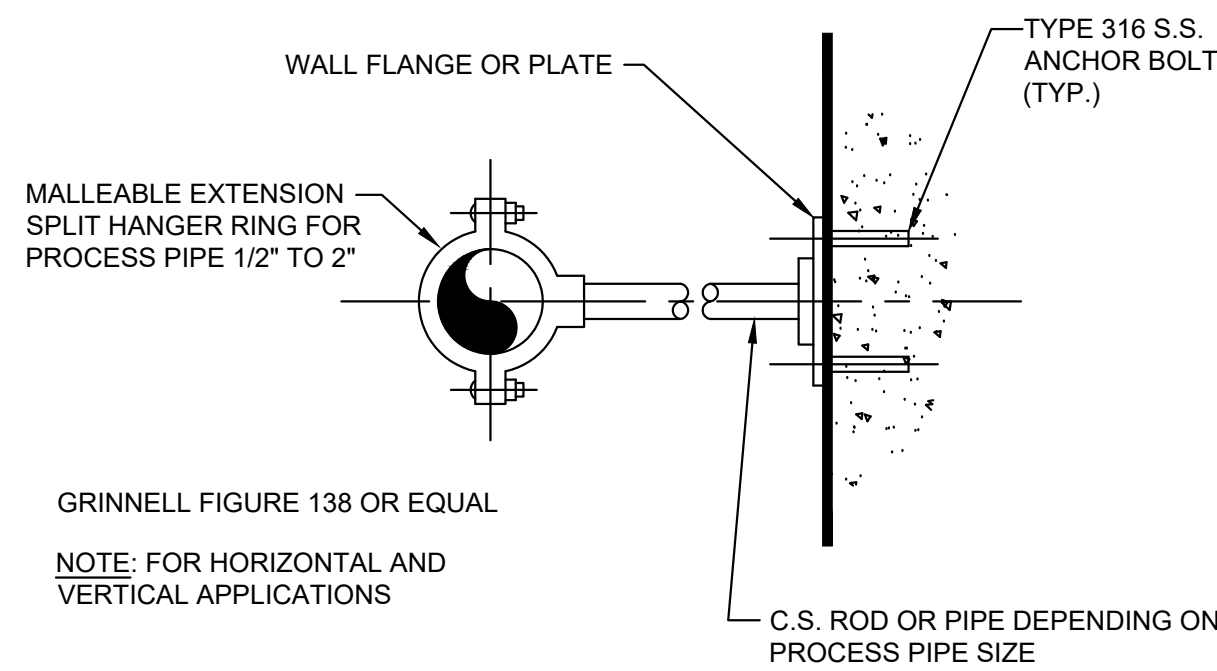


WALL PIPE SUPPORT 422
SCALE: NOT TO SCALE

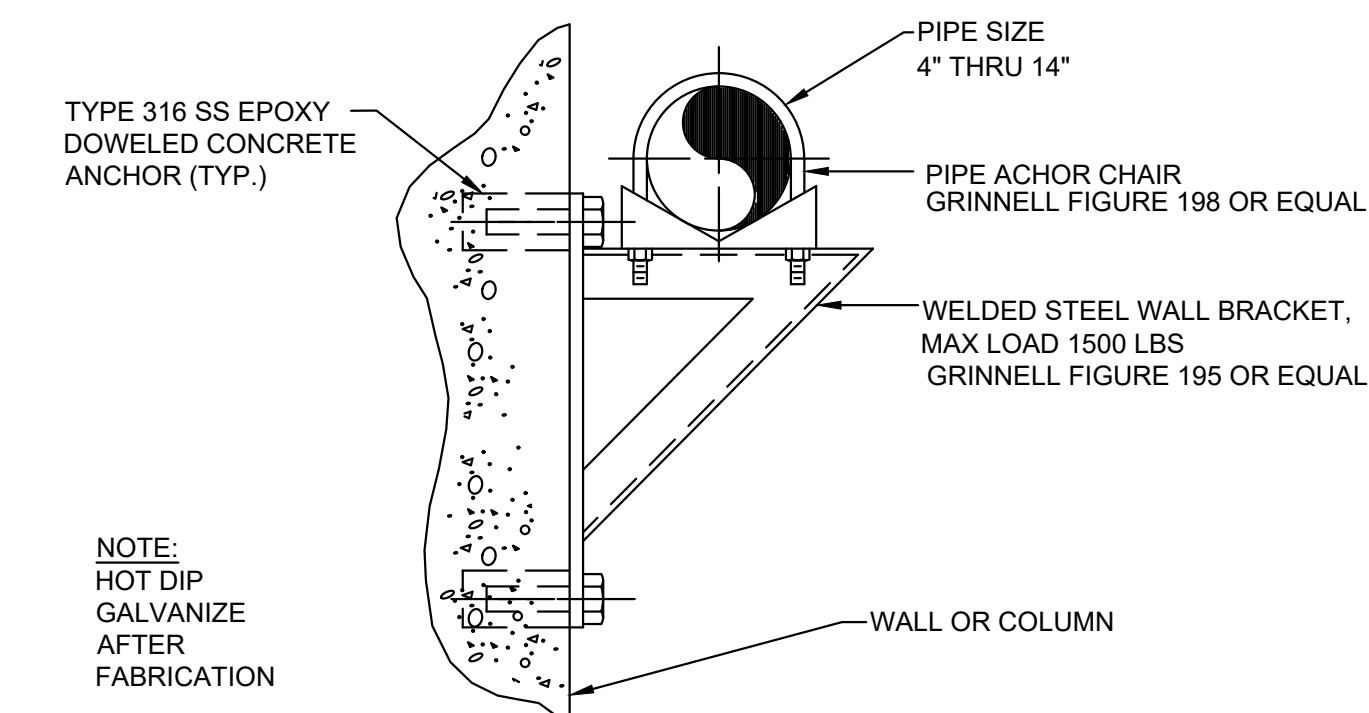


PIPE SUPPORT-MEDIUM 419
SCALE: NOT TO SCALE

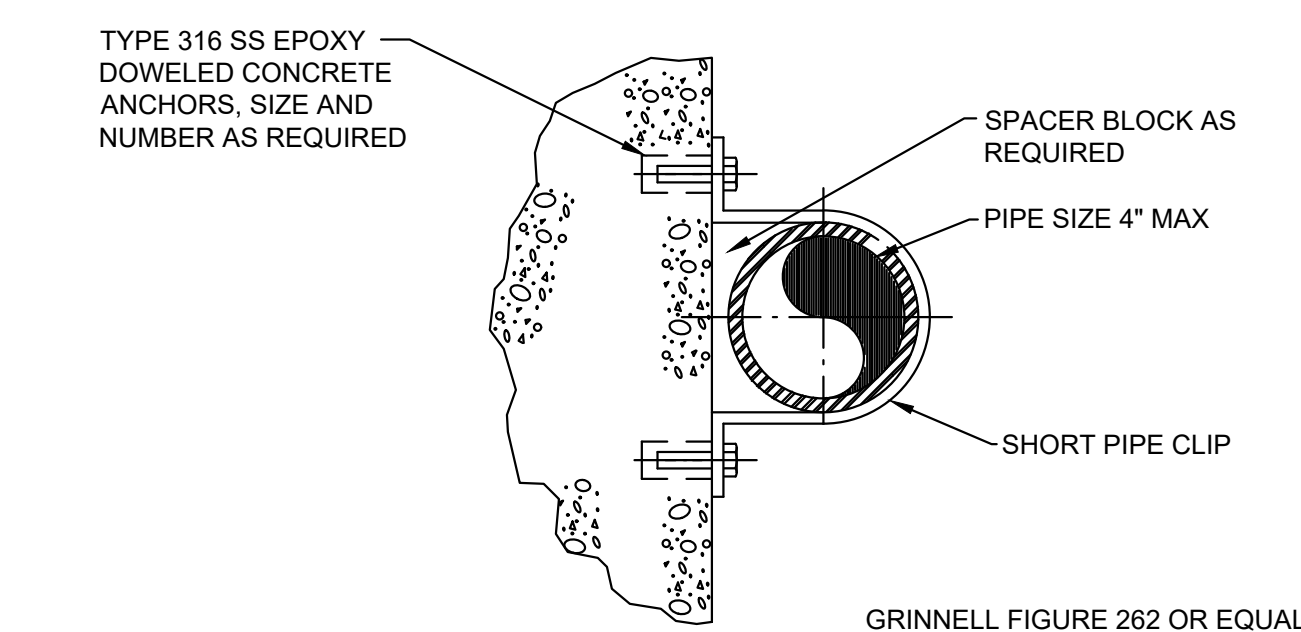


VERTICAL PIPE SUPPORT 423
SCALE: NOT TO SCALE

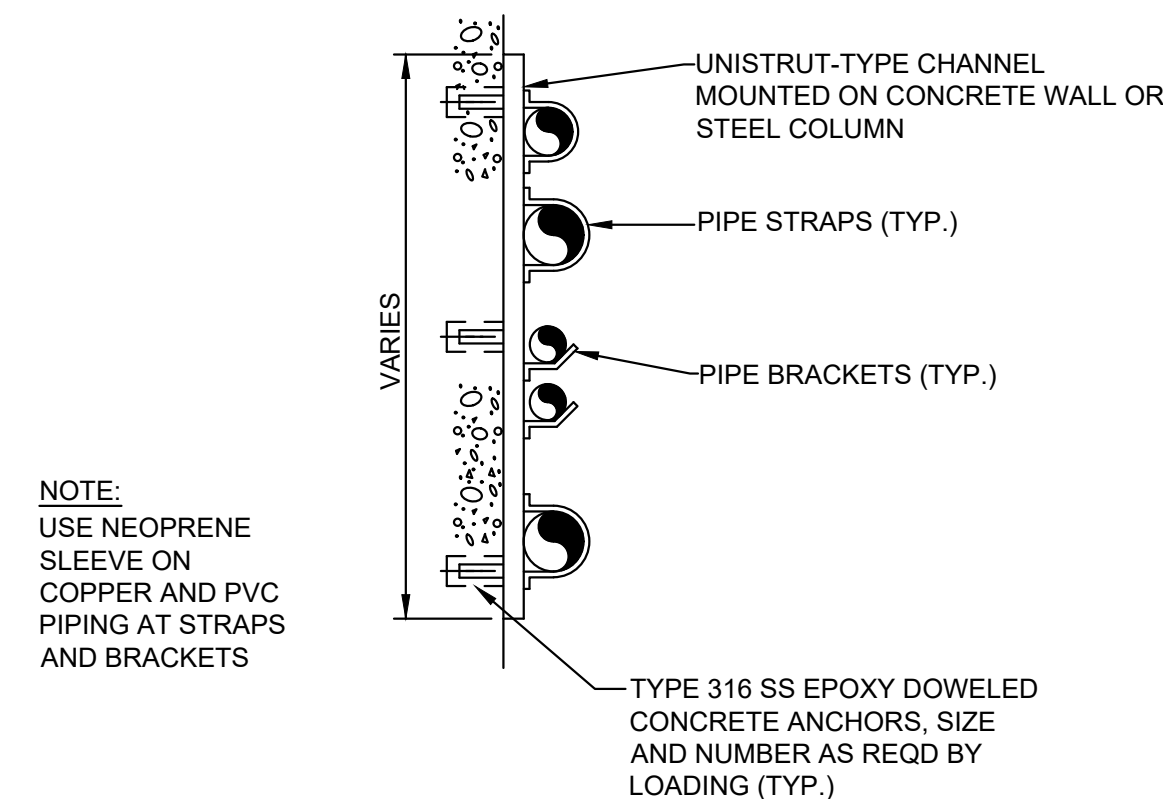


STACKED PIPE WALL SYSTEM 424
SCALE: NOT TO SCALE

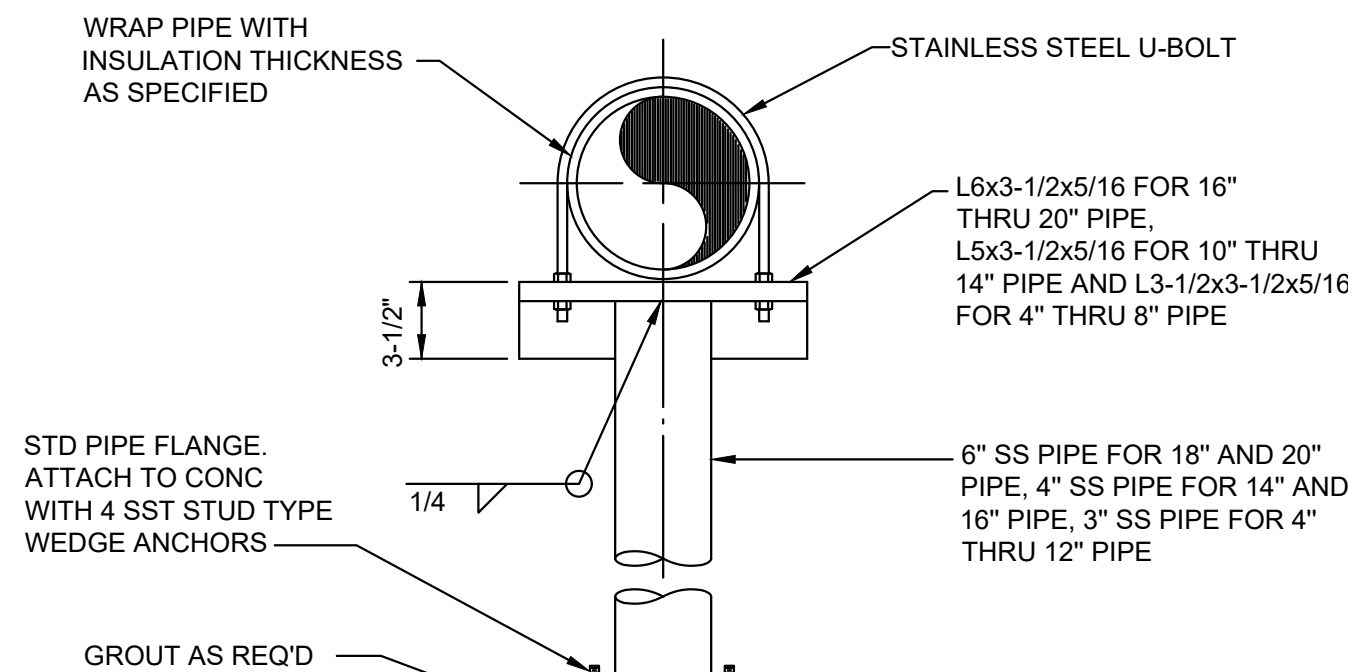


S.S. PIPE SUPPORT (SUBMERGED) 425
SCALE: NOT TO SCALE

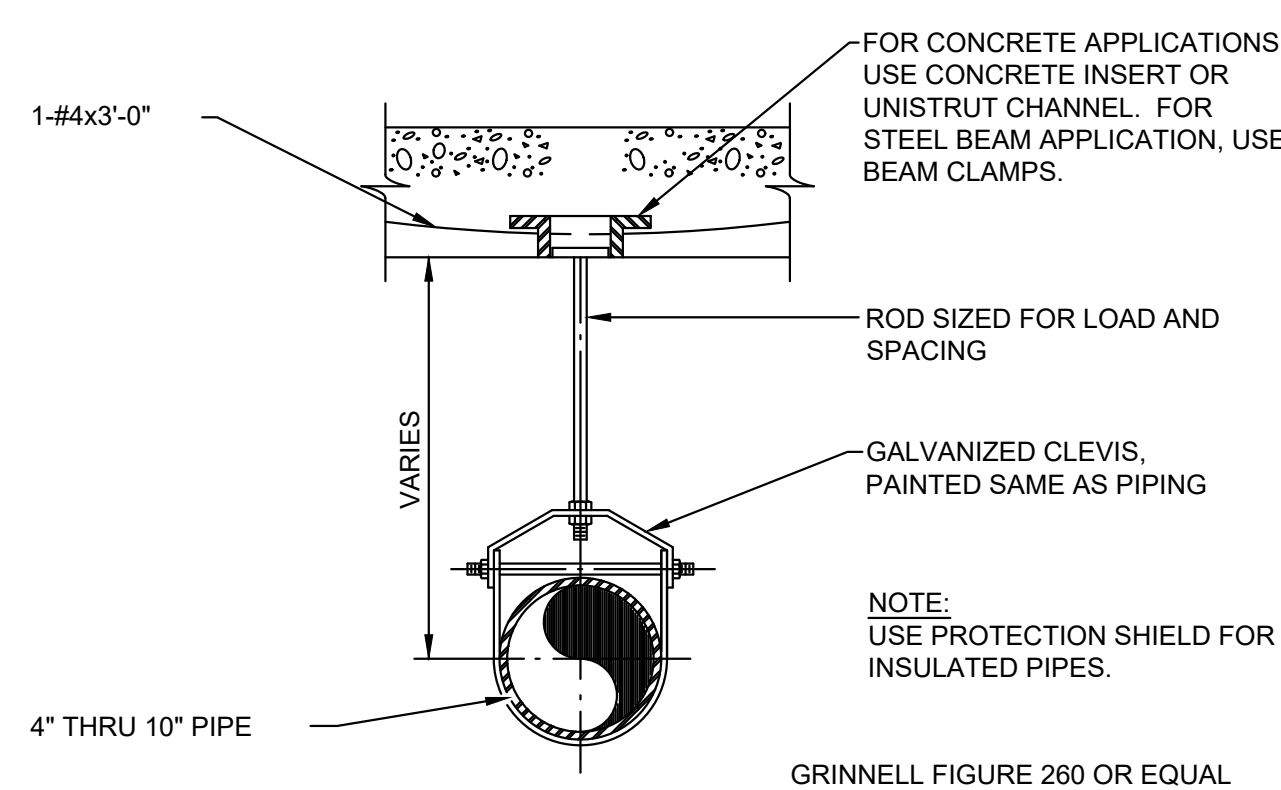


PIPE HANGER 426
SCALE: NOT TO SCALE

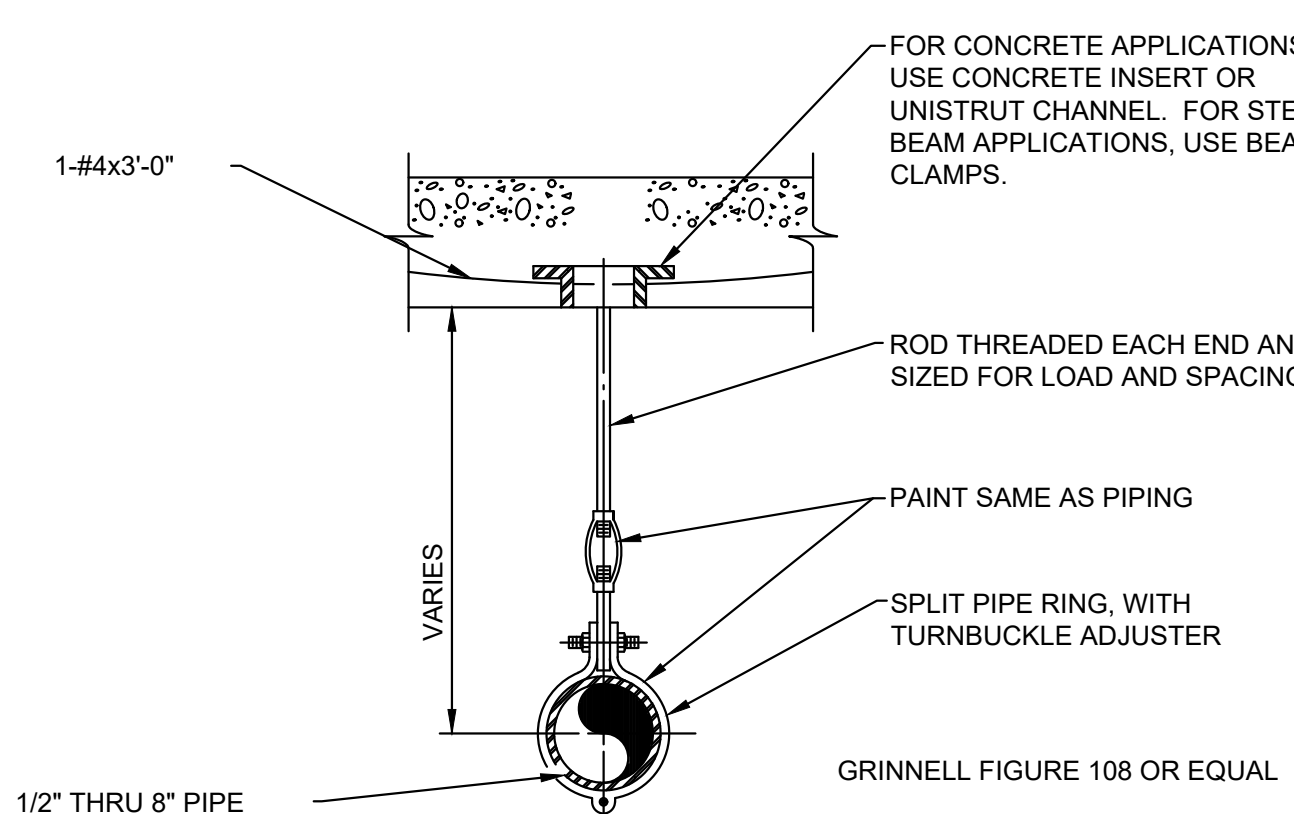


PIPE HANGER 427
SCALE: NOT TO SCALE

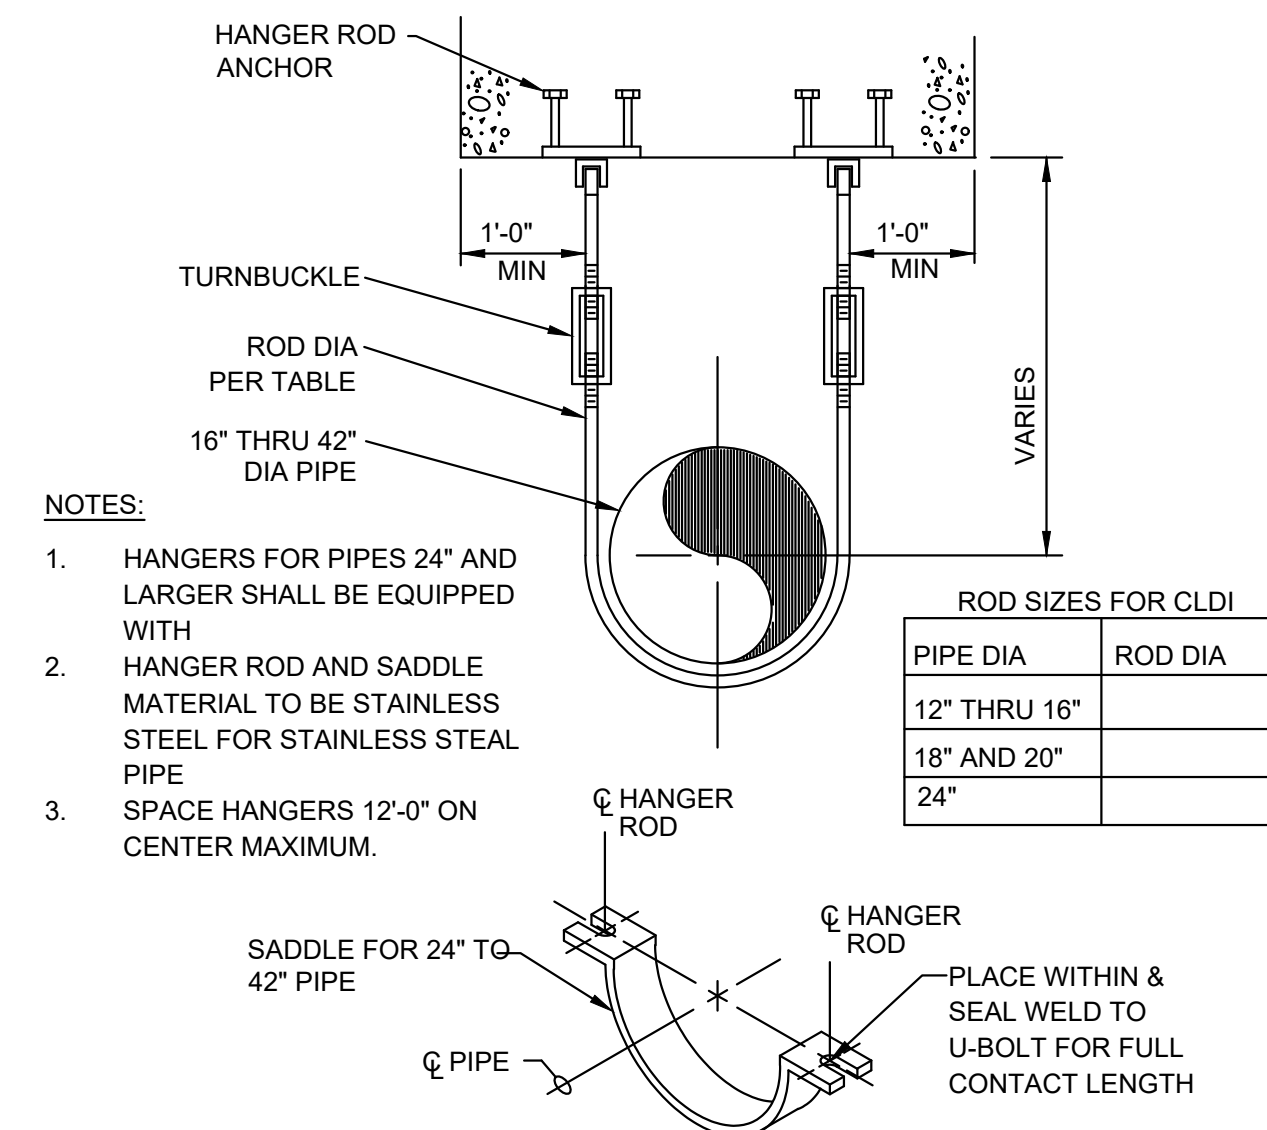


PIPE HANGER 428
SCALE: NOT TO SCALE

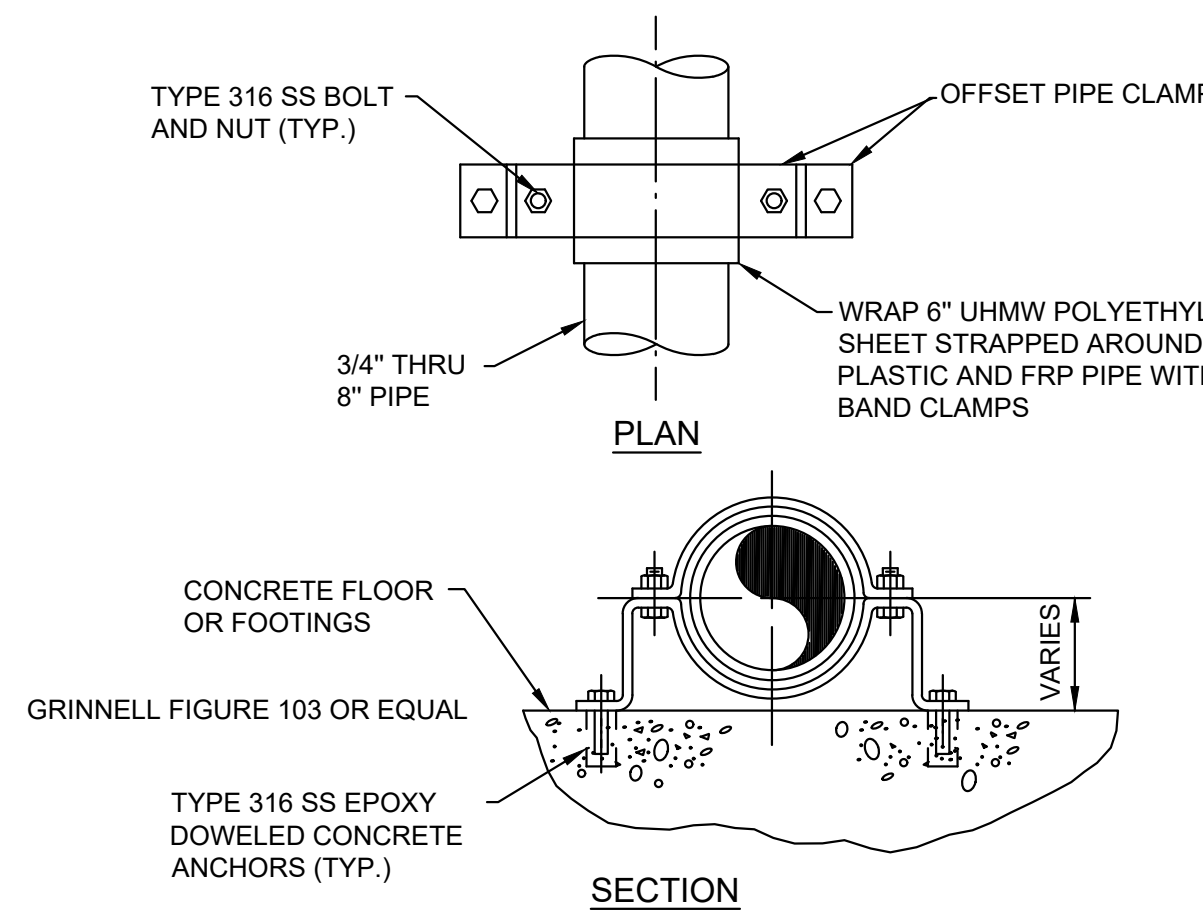

PIPE SUPPORT 429
SCALE: NOT TO SCALE

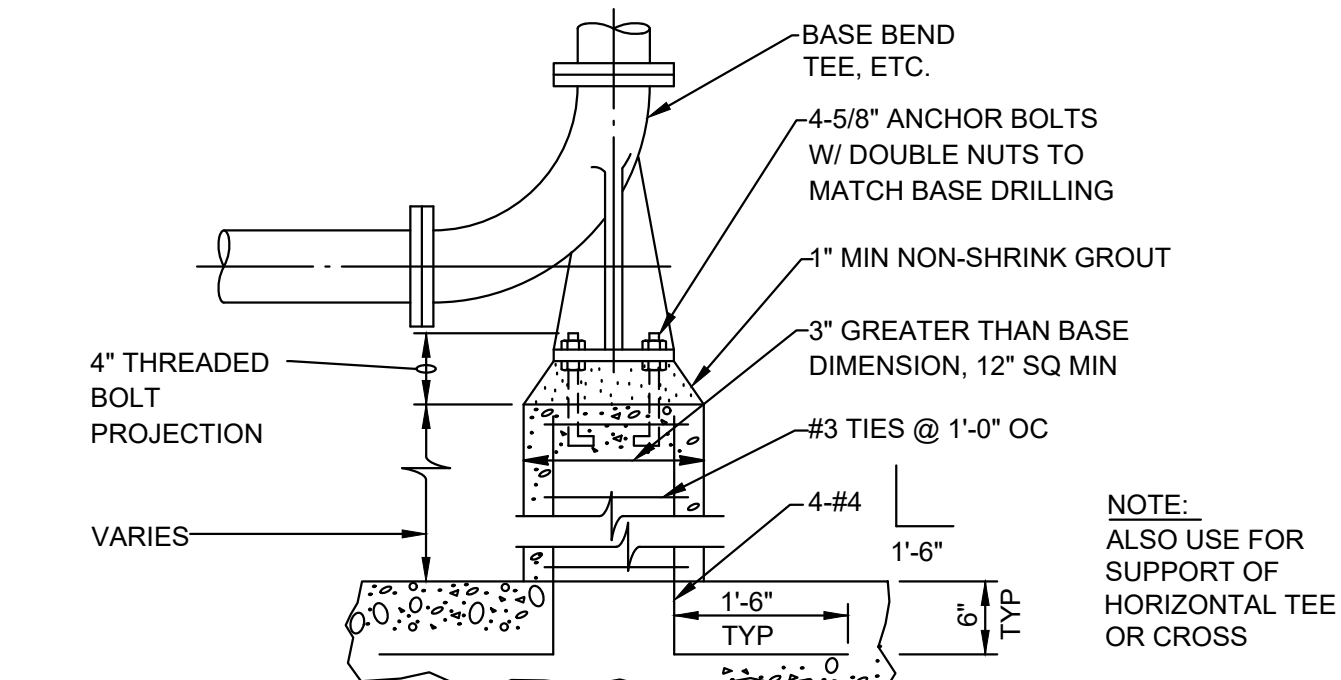

BASE BEND 430
SCALE: NOT TO SCALE

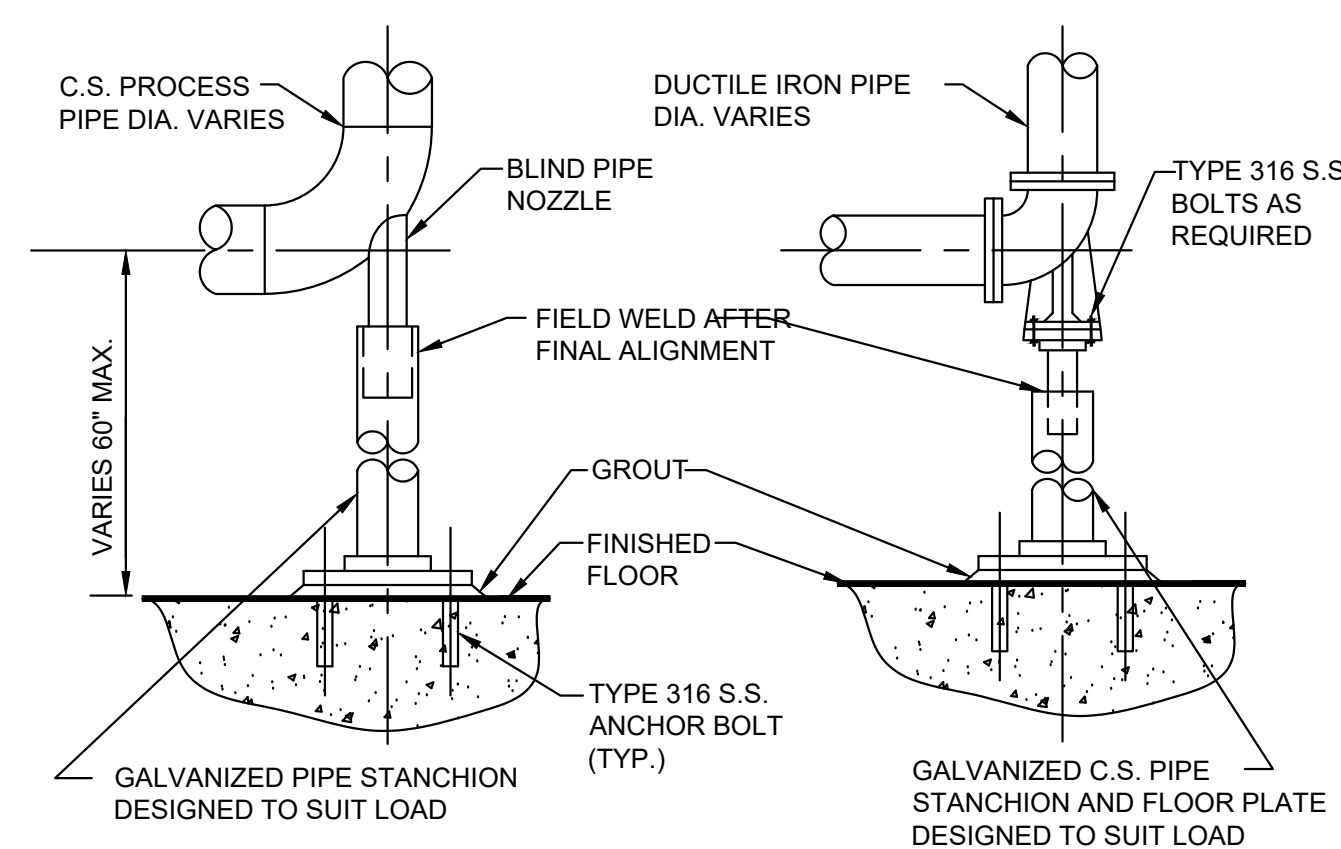

FLOOR PIPE SADDLE 431
SCALE: NOT TO SCALE

PREPARED BY
BETA
www.BETA-Inc.com

REGISTERED PROFESSIONAL



SUBCONSULTANT

PROJECT

**Taunton Wastewater
Treatment Facility
Improvements
Phase 1**

Taunton, MA

TITLE

Mechanical Details II

NO. REVISIONS DATE

DRAWN BY: BM

DESIGNED BY: BM

CHECKED BY: SR

ISSUE DATE: 7/2/2021

BETA JOB NO.: 6050


SCALE

AS SHOWN

UNLESS OTHERWISE NOTED OR CHANGED BY REPRODUCTION

SHEET NO.

MD-2

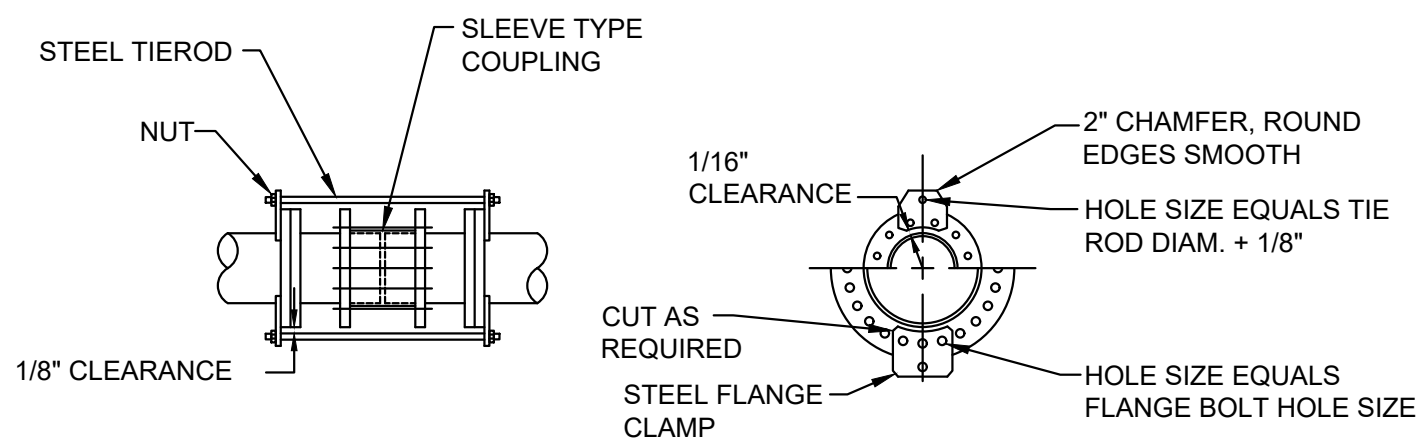


NOTE: TIERODS SHALL BE EQUALLY SPACED AROUND PIPE.

PIPE SIZE	TIERODS		FLANGE CLAMP			
	NO.	DIA.	THICKNESS	NO. OF FLANGE BOLTS PER CLAMP	"A"	"B"
6"	2	1/2"	1/2"	2	2"	7-3/4"
8"	2	5/8"	1/2"	2	2"	8-5/8"
10"	2	3/4"	1/2"	2	2"	7-3/4"
12"	2	1"	1/2"	2	2"	8-1/2"
14"	2	1-1/8"	3/4"	2	2"	9"
16"	2	1-1/4"	7/8"	3	2"	12-1/4"
18"	2	1-3/8"	7/8"	3	2-1/2"	13"
20"	3	1-3/8"	1"	2	2-1/2"	8"
24"	3	1-3/8"	1"	2	2-1/2"	8-3/4"
30"	4	1-3/4"	1"	2	2-1/2"	12-1/4"
36"	4	1-3/4"	1-1/4"	3	2-1/2"	8-1/2"
42"	6	1-3/4"	1-1/4"	2	2-1/2"	12-3/4"
48"	6	1-3/4"	1-1/4"	3	2-1/2"	12-1/2"
	8			3		

SLEEVE COUPLING RESTRAINT
(150 PSI FLANGE CLAMP ASSEMBLY)

SCALE: NOT TO SCALE


432

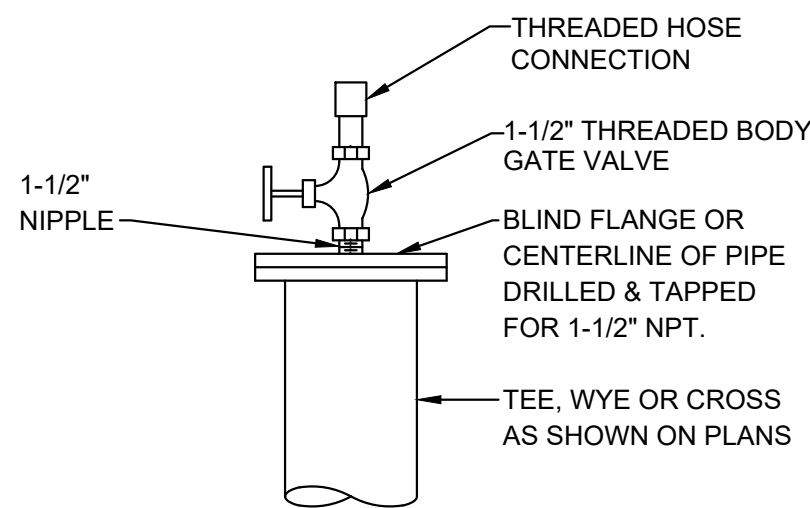

FLUSHING CONNECTION


SCALE: NOT TO SCALE

433

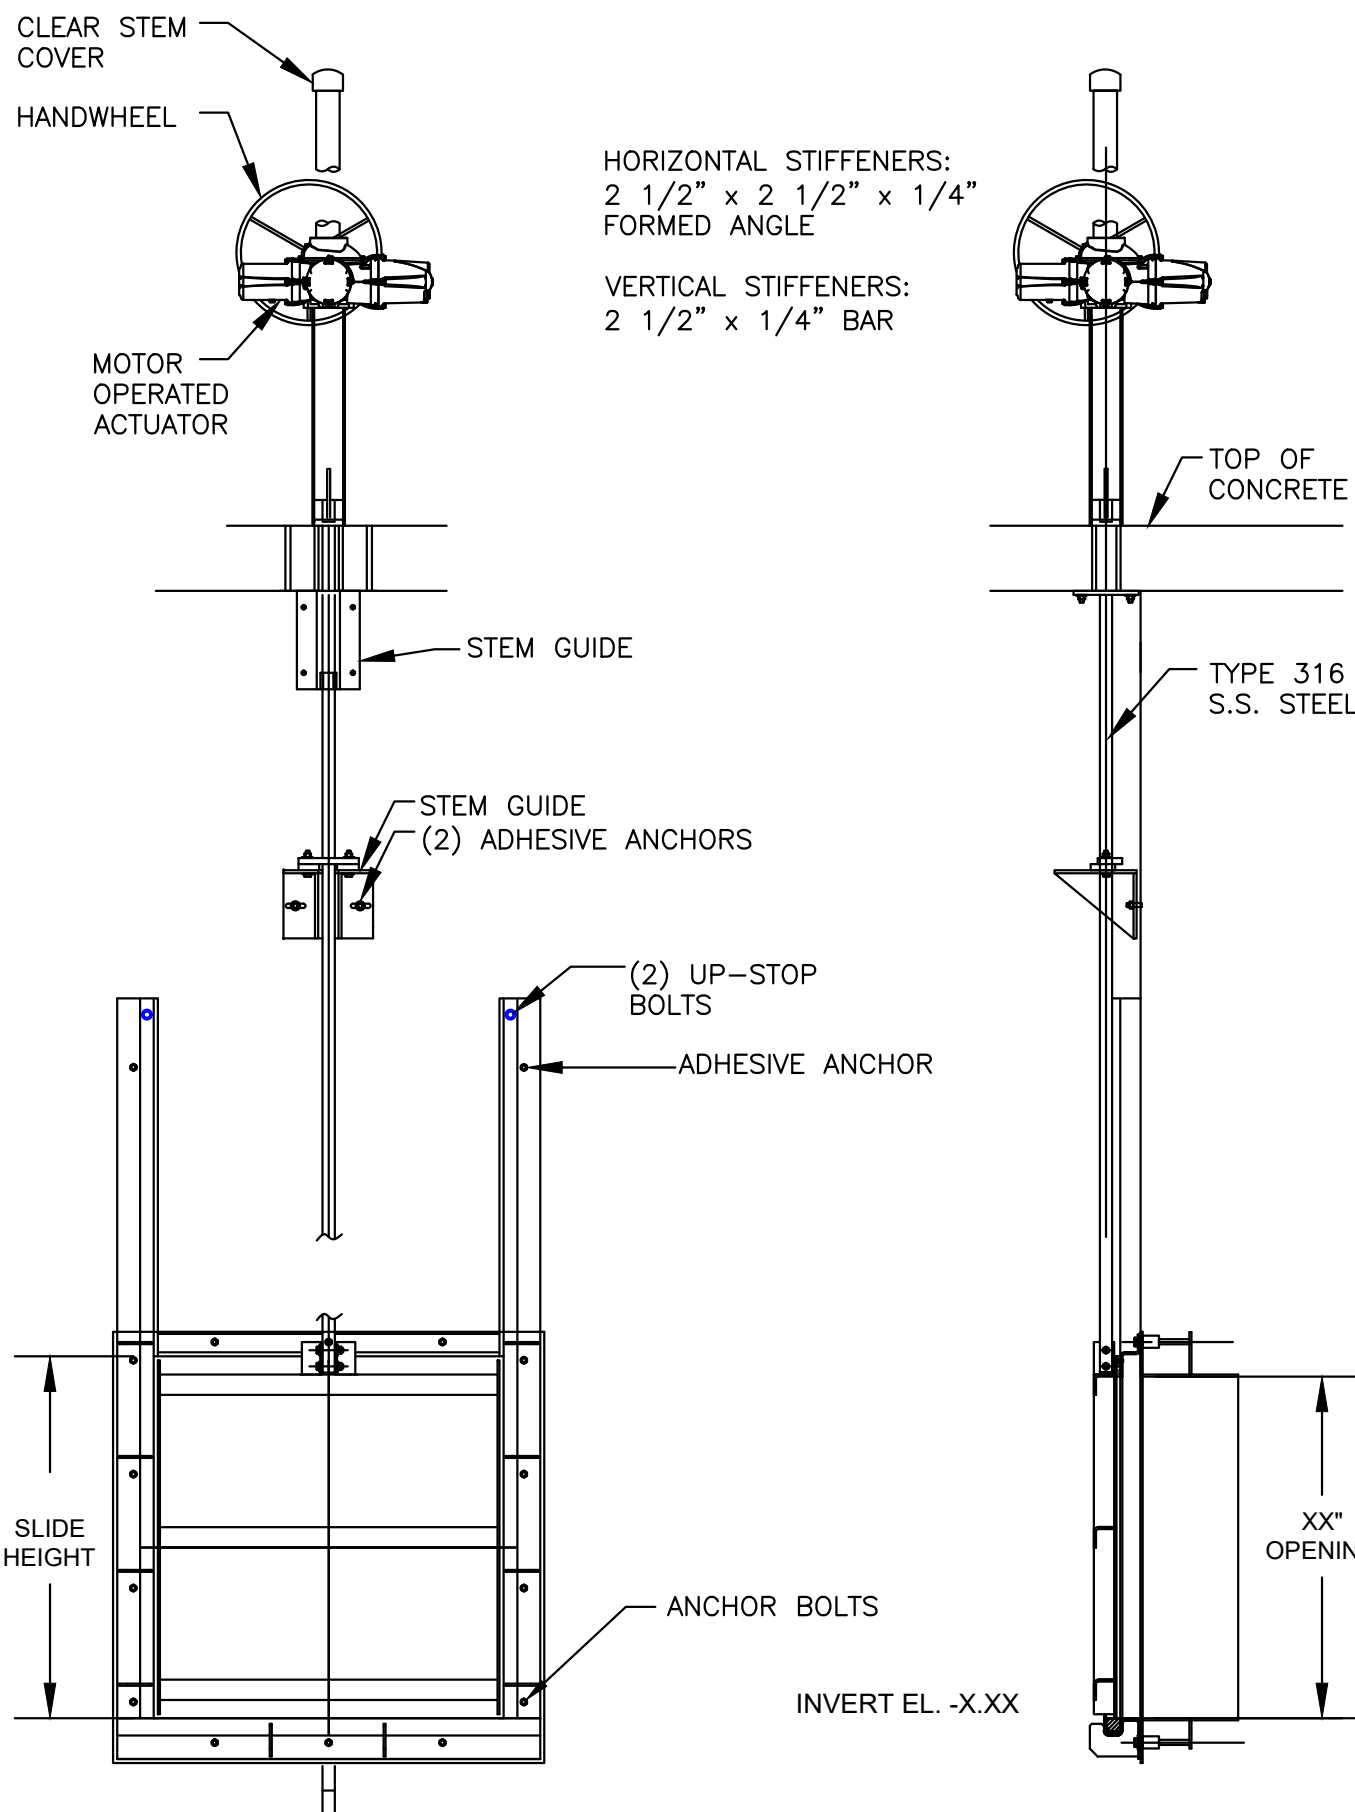


SLIDE GATE

SCALE: NOT TO SCALE

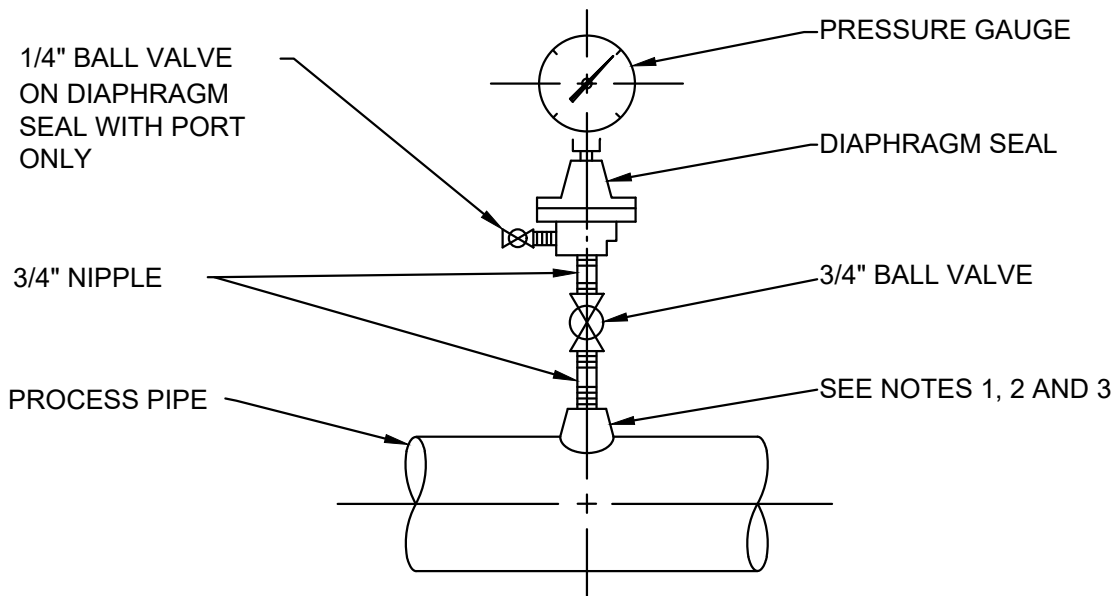

DIAPHRAGM PRESSURE GAUGE

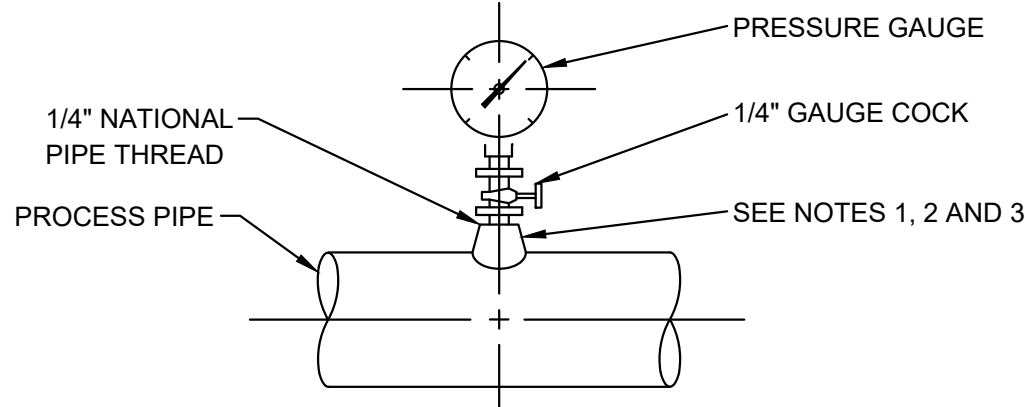

PRESSURE GAUGE

NOTES:

- FOR STEEL, GALVANIZED STEEL, AND PVC 2 1/2" AND SMALLER USE A BUSHING IN A TEE.
- FOR DUCTILE IRON AND FIBERGLASS REINFORCED PLASTIC PIPE, ALL SIZES, USE PIPE SADDLE WITH BUSHING.
- FOR STEEL AND STAINLESS STEEL PIPES 3" AND LARGER, AND PRESSURE VESSELS, USE THRED-O-LET AS SHOWN.
- PROVIDE SNUBBER FOR POSITIVE DISPLACEMENT PUMP INSTALLATIONS.

PRESSURE GAUGE
MOUNTING DETAILS

SCALE: NOT TO SCALE

434

PREPARED BY



REGISTERED PROFESSIONAL



SUBCONSULTANT

PROJECT

Taunton Wastewater
Treatment Facility
Improvements
Phase 1

Taunton, MA

TITLE

Mechanical Details III

NO.	REVISIONS	DATE

SCALE

AS SHOWN

UNLESS OTHERWISE NOTED OR CHANGED BY REPRODUCTION

SHEET NO.

MD-3